



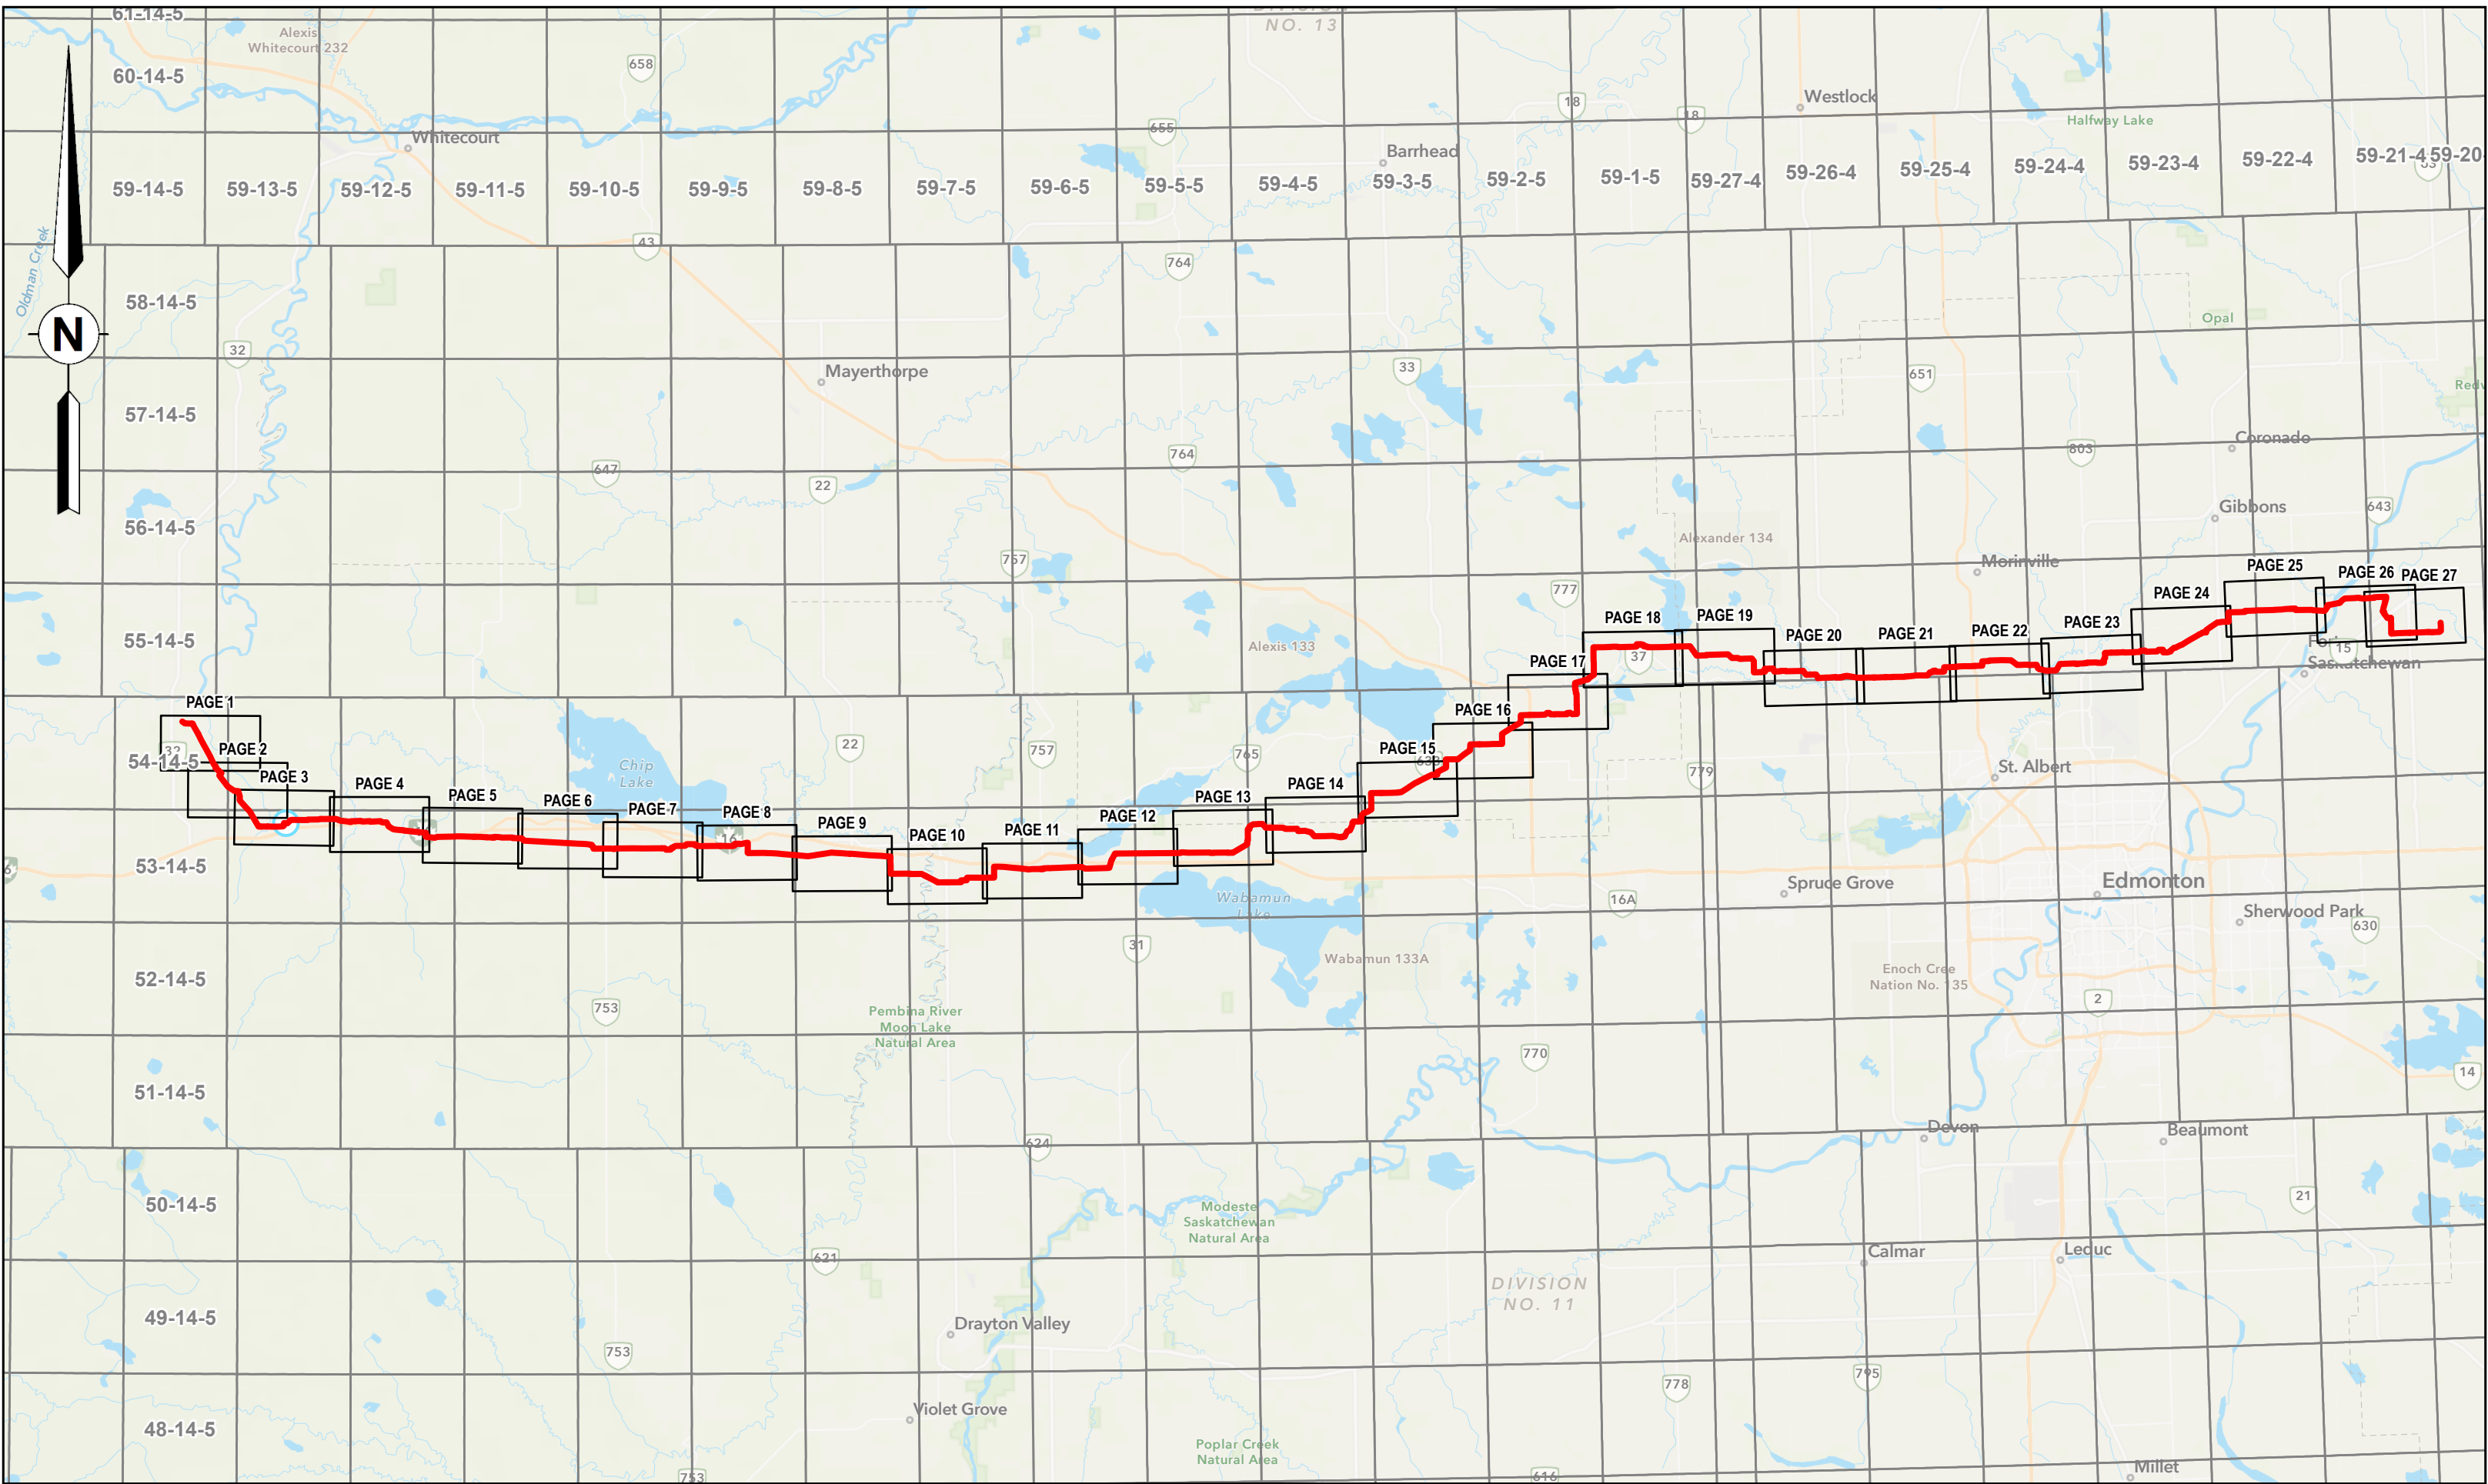


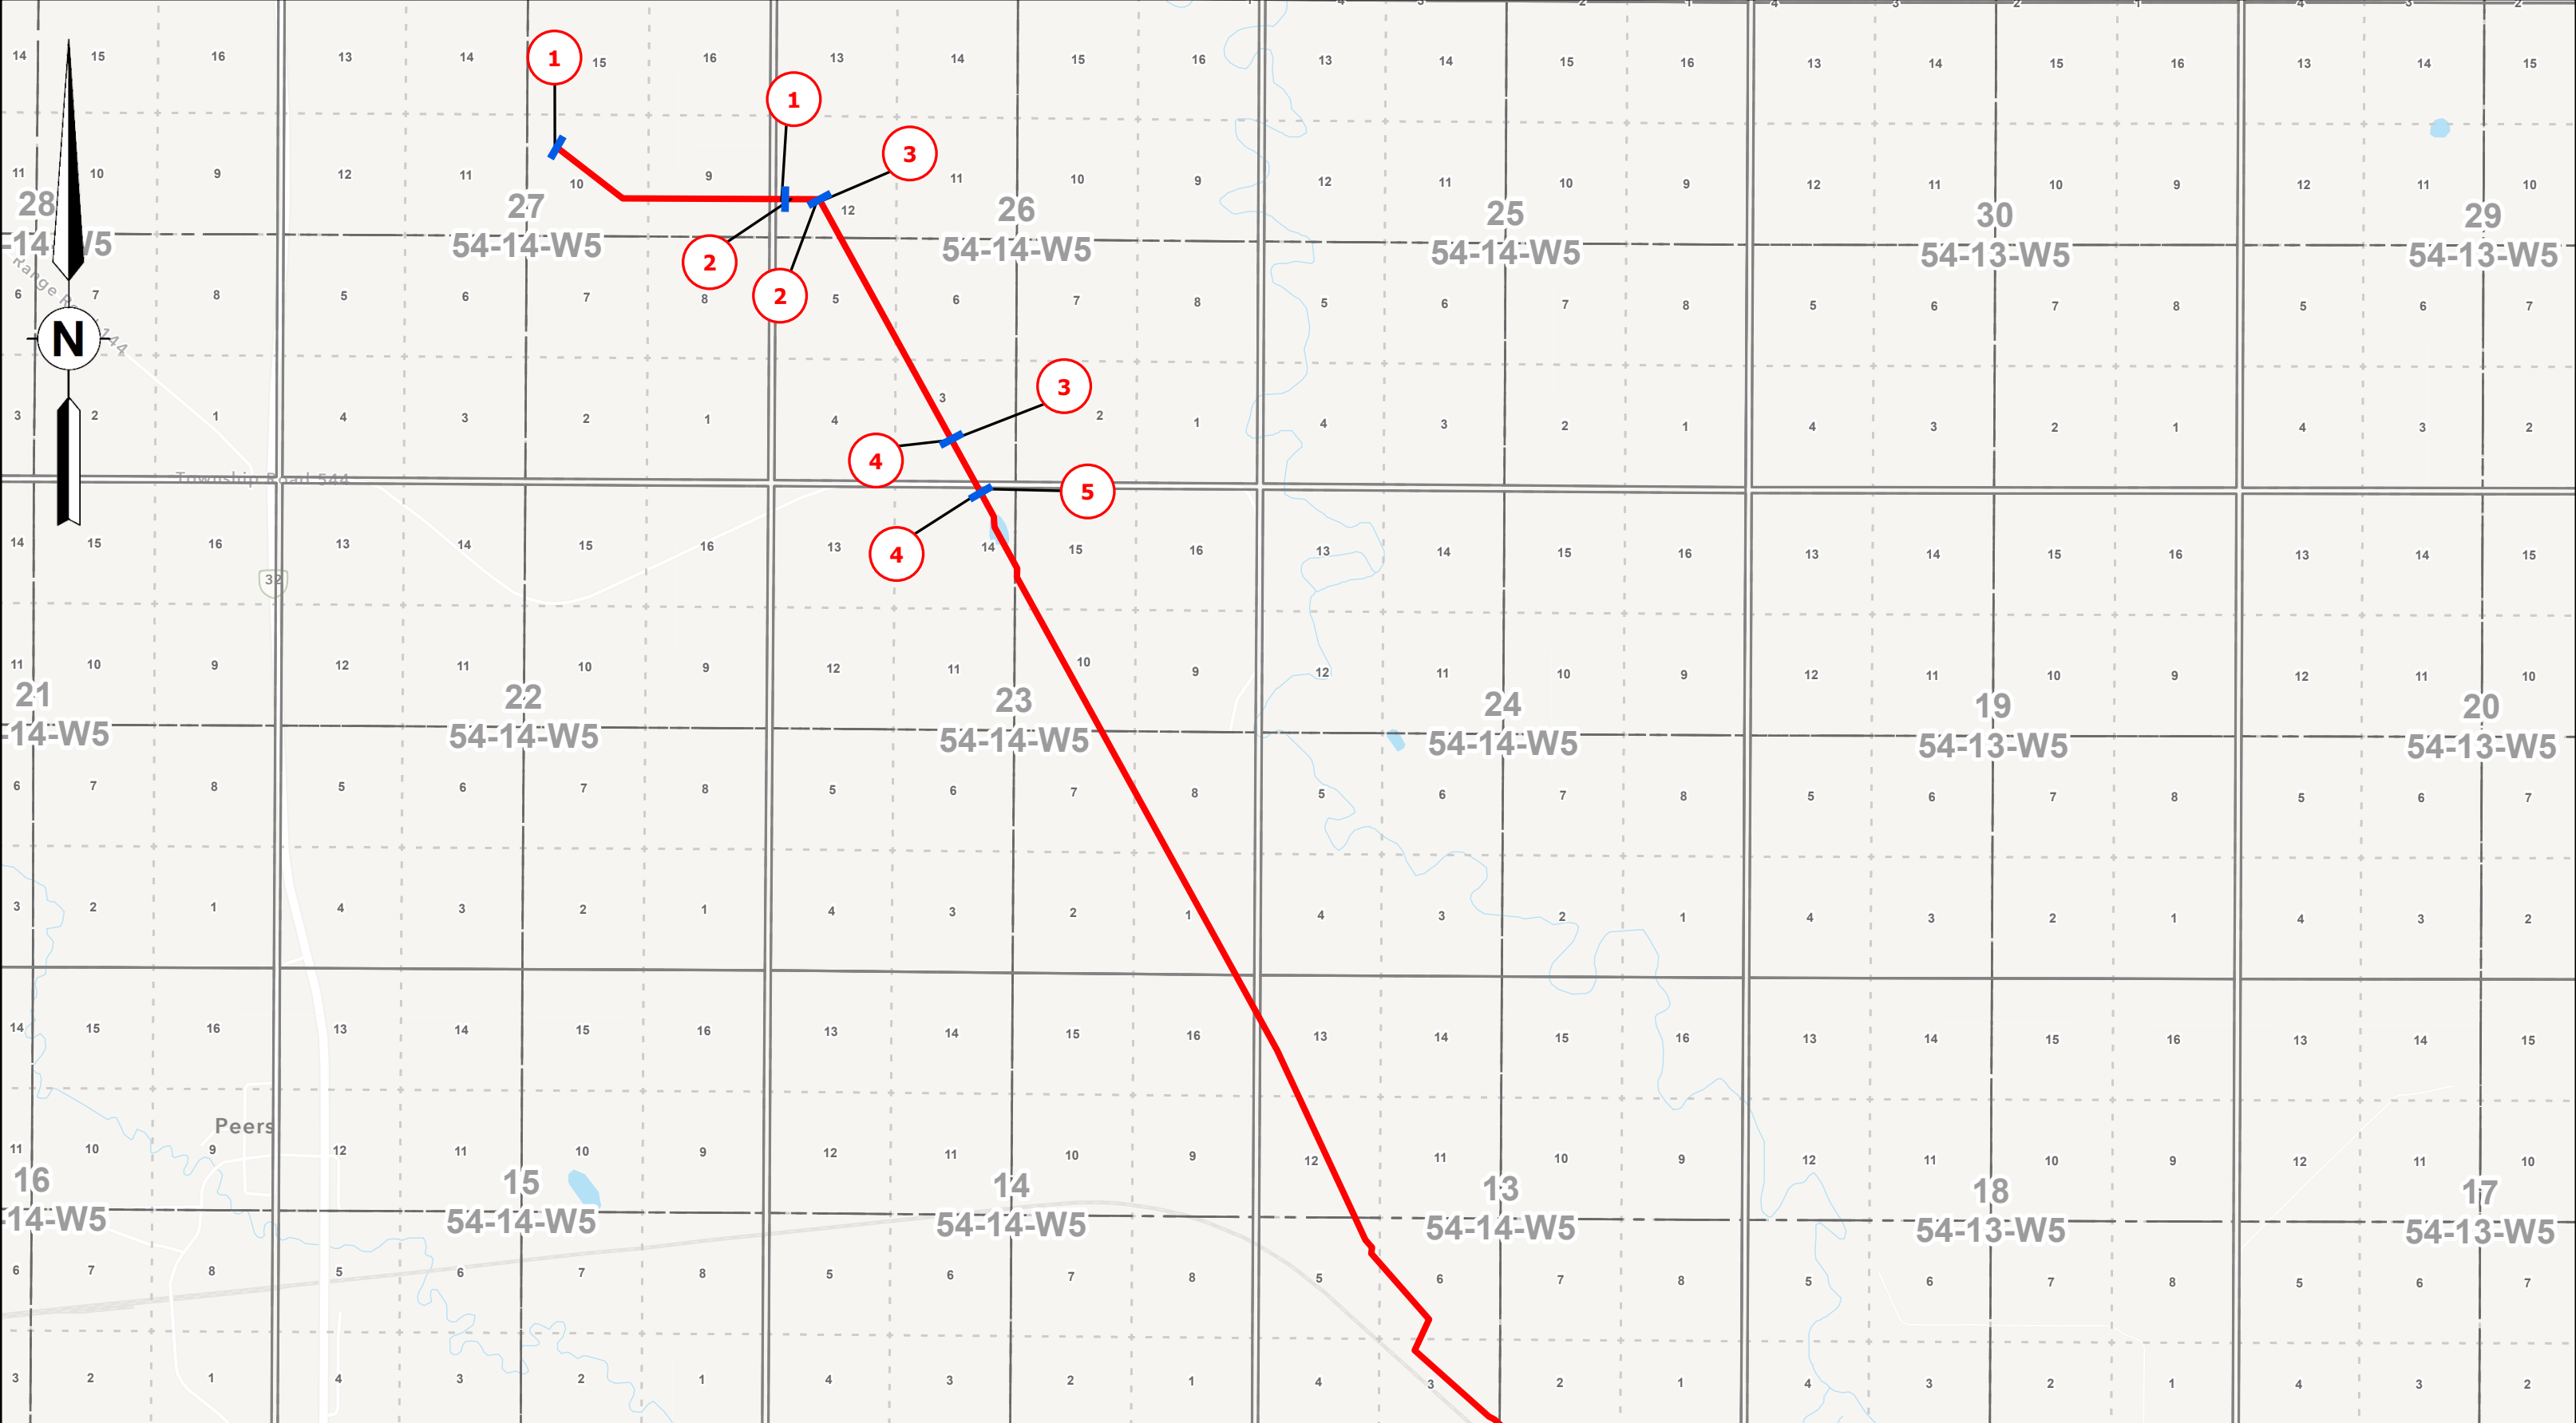



McElhanney Ltd.
100, 402 - 11th Avenue SE
Calgary, Alberta T2G 0Y4
T(403)245-4711



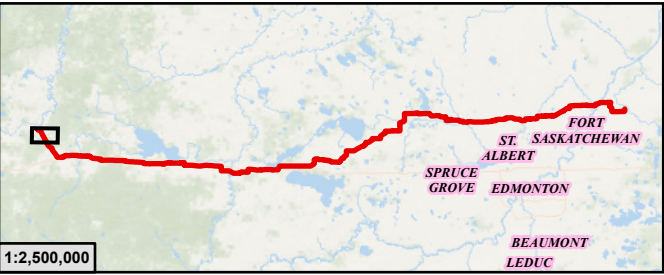

Legend

- PIPELINE PERMITTED, OPERATING OR DE-LICENSED
- ABANDONED OR REMOVED PIPELINE
- PIPELINE SPLIT LOCATION
- LINE NUMBER FOR PERMITTED, OPERATING OR DE-LICENSED PIPELINE
- LINE NUMBER FOR ABANDONED OR REMOVED PIPELINE
- INSTALLATION NUMBER (COMPRESSOR STATION)

**ATCO Yellowhead Pipeline
AUC Facility Application**

**Installation Location and Site Plans within
NE-27-54-14-W5M To SE-15-55-21-W4M**

SCALE: 1:20,000

DC Num: N/A

0 250 500 1,000 Metres

JOB: 301100635

PLAN ID: AUC Facilities Application

License No.:


REV
0

GIS
TH

CHK
RD

DATE
10/14/2025

Page 1 of 27

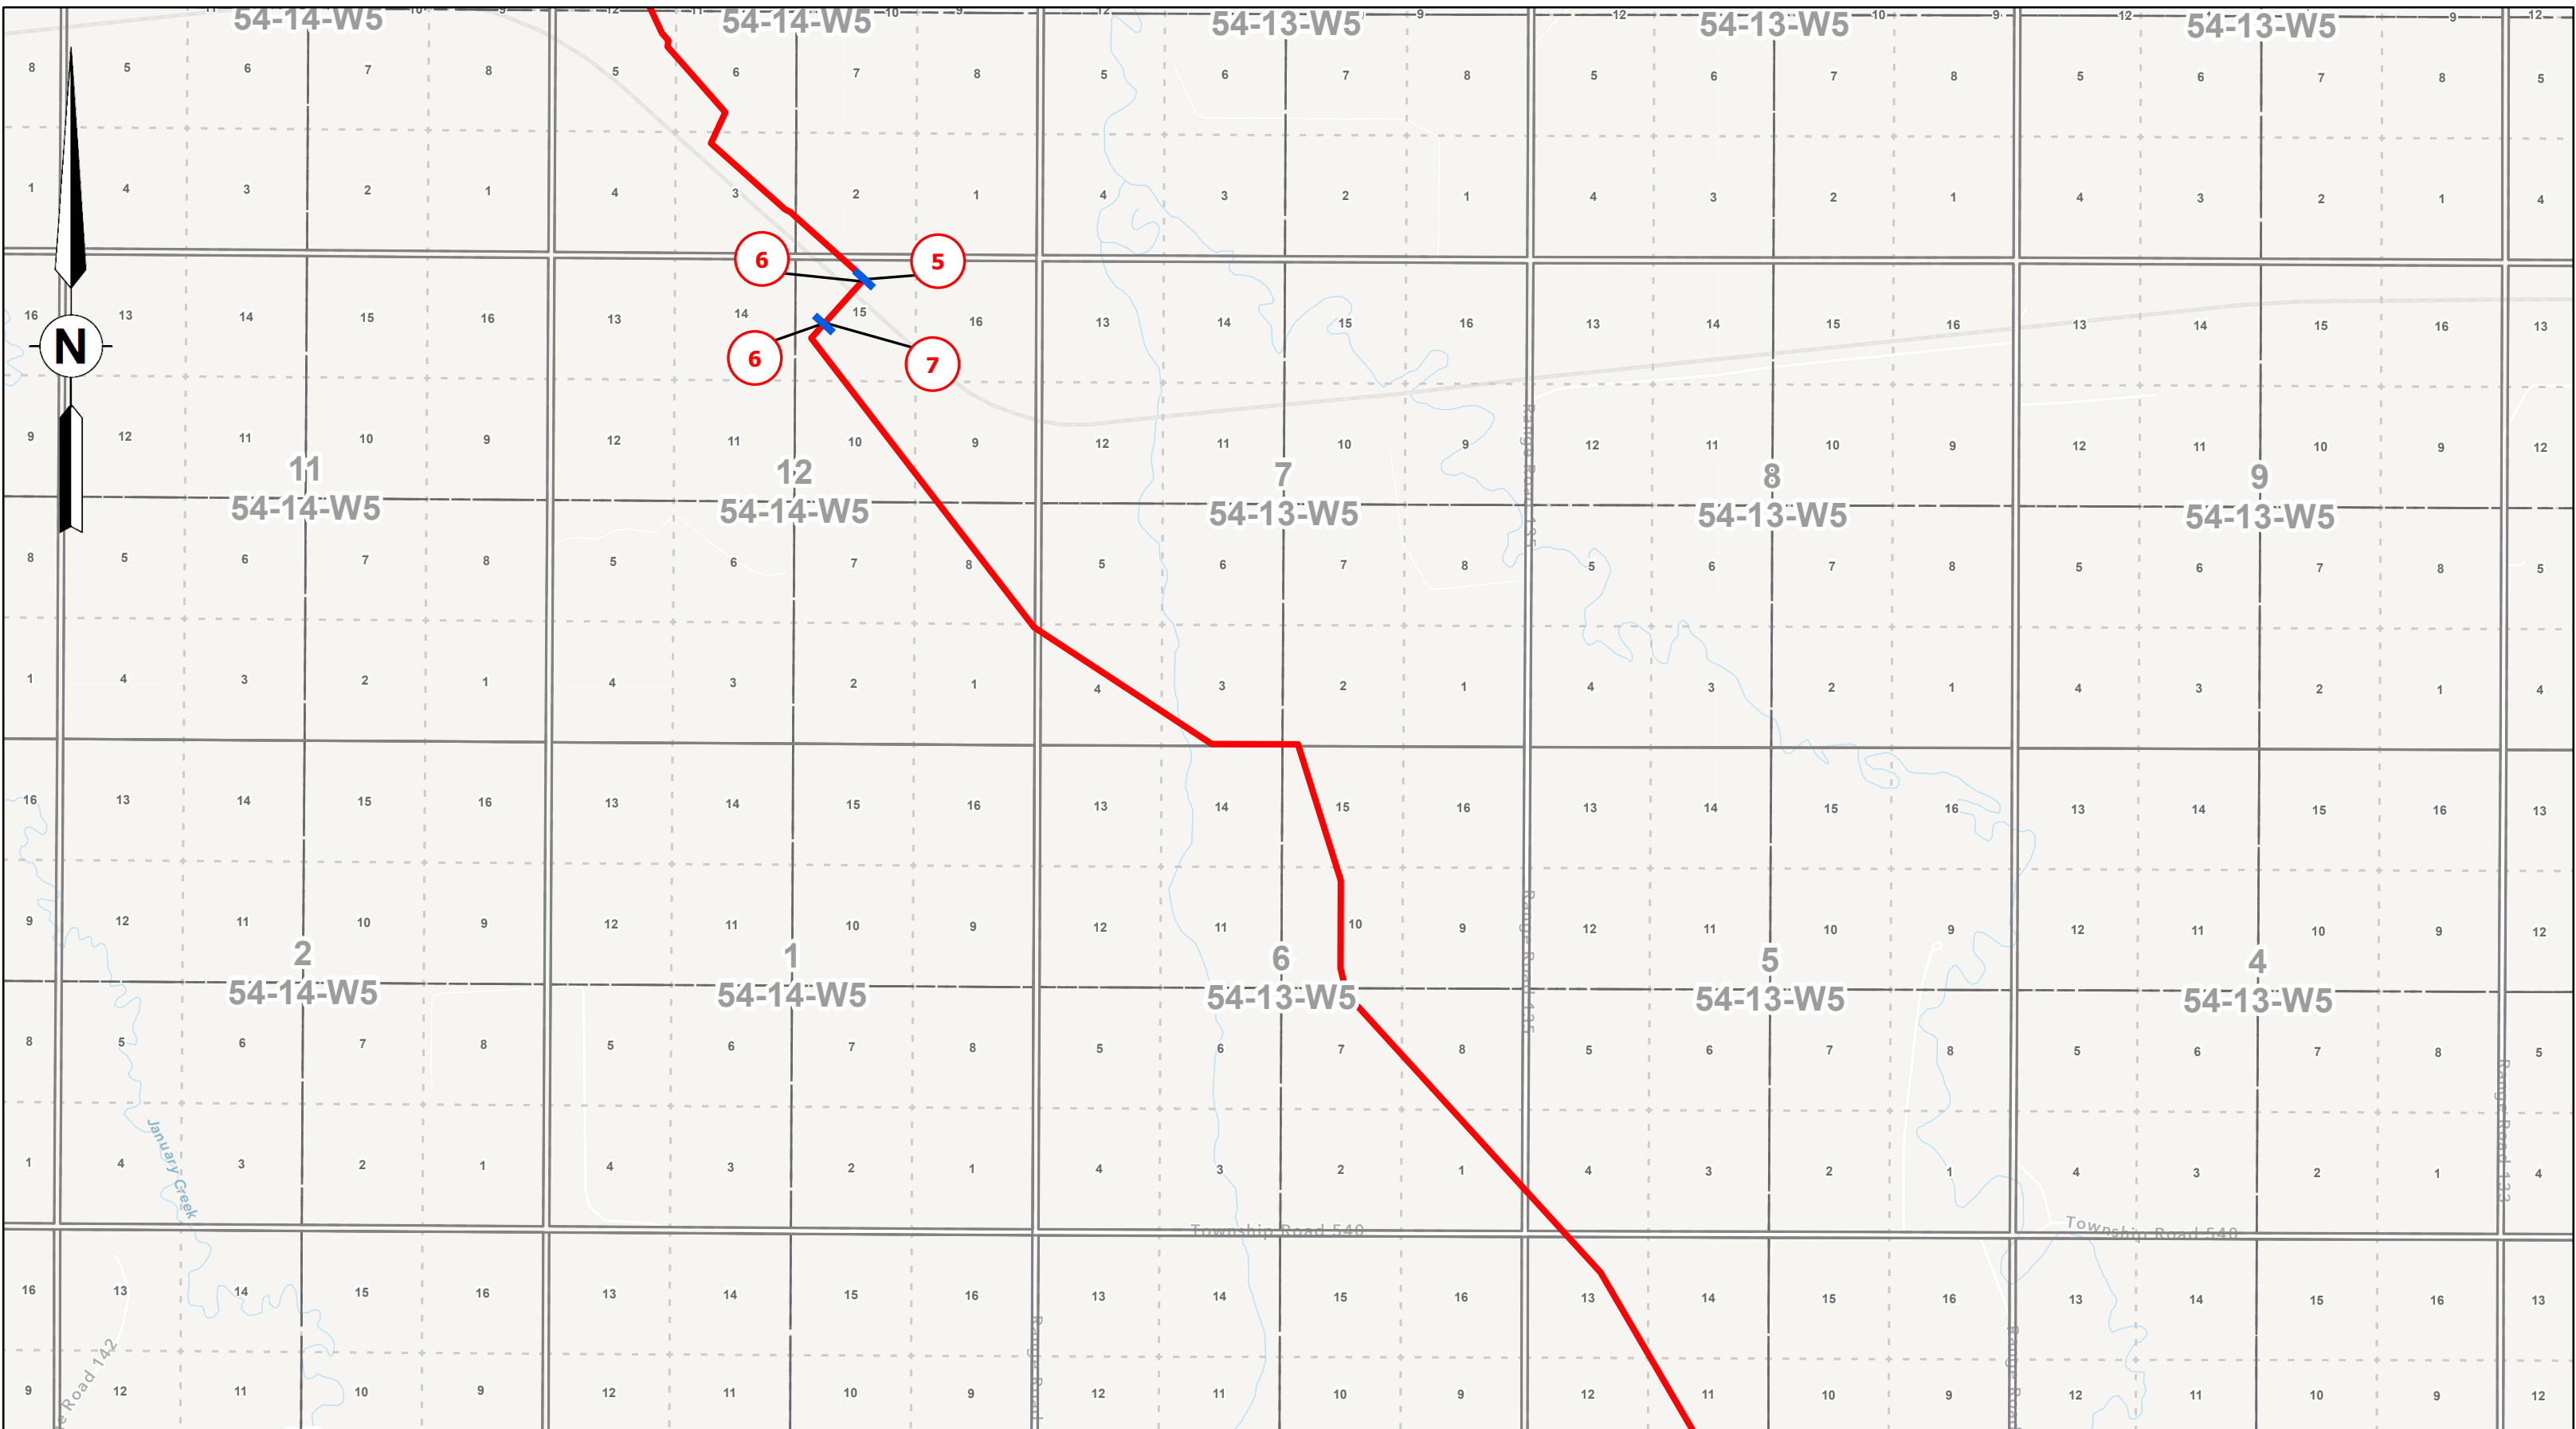




McElhanney Ltd.
100, 402 - 11th Avenue SE
Calgary, Alberta T2G 0Y4
T(403)245-4711



0	10/14/2025	Plan Issued
Rev	Date	Description

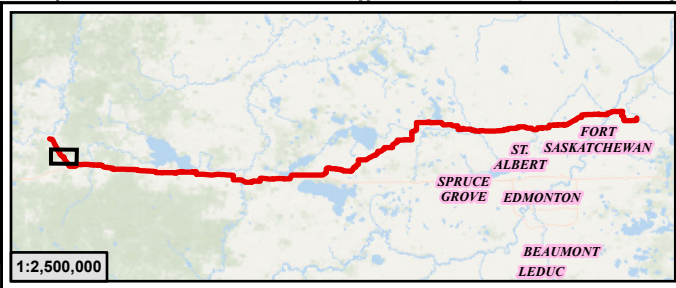

Legend

- PIPELINE PERMITTED, OPERATING OR DE-LICENSED
- ABANDONED OR REMOVED PIPELINE
- PIPELINE SPLIT LOCATION
- LINE NUMBER FOR PERMITTED, OPERATING OR DE-LICENCED PIPELINE
- LINE NUMBER FOR ABANDONED OR REMOVED PIPELINE
- INSTALLATION NUMBER (COMPRESSOR STATION)

**ATCO Yellowhead Pipeline
AUC Facility Application**

Installation Location and Site Plans within
NE-27-54-14-W5M To SE-15-55-21-W4M

SCALE: 1:20,000

DC Num: N/A

0 250 500 1,000 Metres

JOB: 301100635

PLAN ID: AUC Facilities Application

License No.:

REV
0

GIS

TH


CHK

RD

DATE

10/14/2025

Page 2 of 27

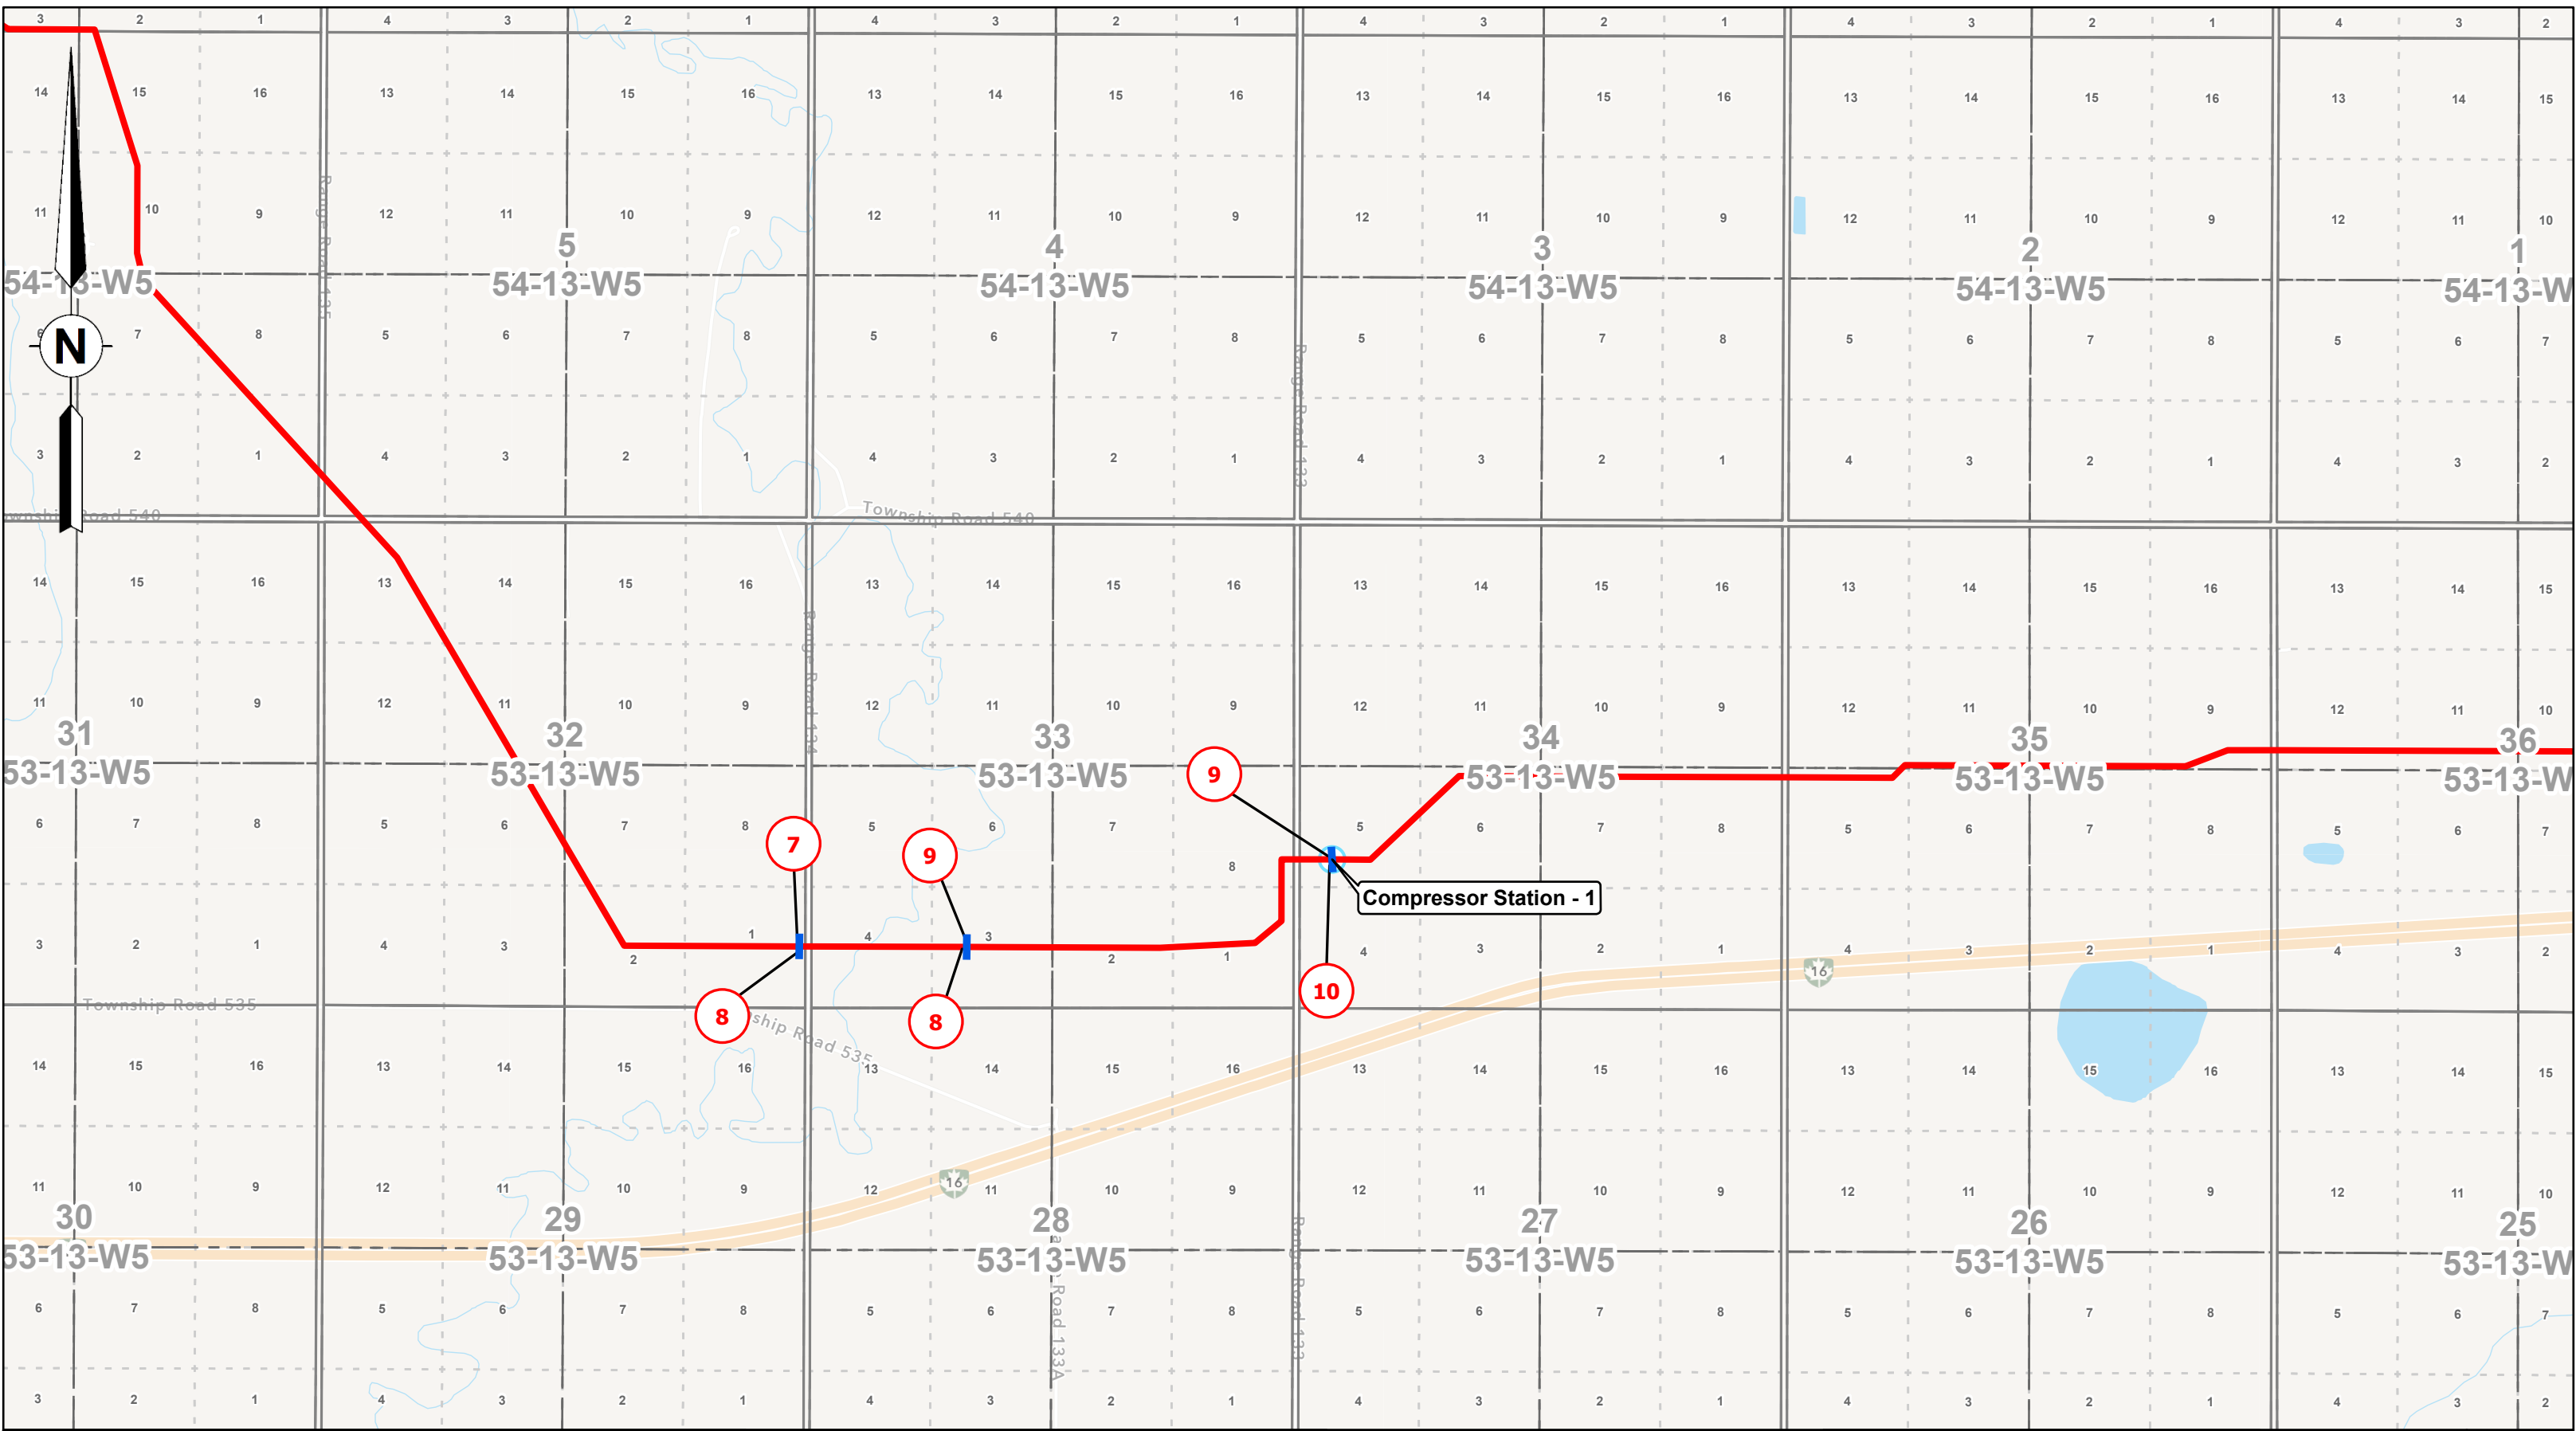




McElhanney Ltd.
100, 402 - 11th Avenue SE
Calgary, Alberta T2G 0Y4
T(403)245-4711



0	10/14/2025	Plan Issued
Rev	Date	Description

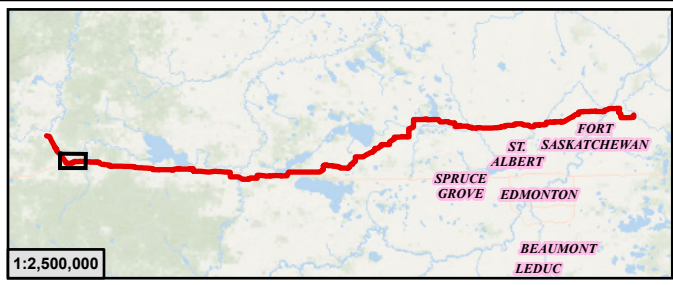

Legend

- PIPELINE PERMITTED, OPERATING OR DE-LICENSED
- ABANDONED OR REMOVED PIPELINE
- PIPELINE SPLIT LOCATION
- LINE NUMBER FOR PERMITTED, OPERATING OR DE-LICENCED PIPELINE
- LINE NUMBER FOR ABANDONED OR REMOVED PIPELINE
- INSTALLATION NUMBER (COMPRESSOR STATION)

**ATCO Yellowhead Pipeline
AUC Facility Application**

Installation Location and Site Plans within
NE-27-54-14-W5M To SE-15-55-21-W4M

SCALE: 1:20,000

DC Num: N/A

02505001,000

Metres

JOB: 301100635

PLAN ID: AUC Facilities Application

License No.:

REV
0

GIS

TH


CHK

RD

DATE

10/14/2025

Page 3 of 27

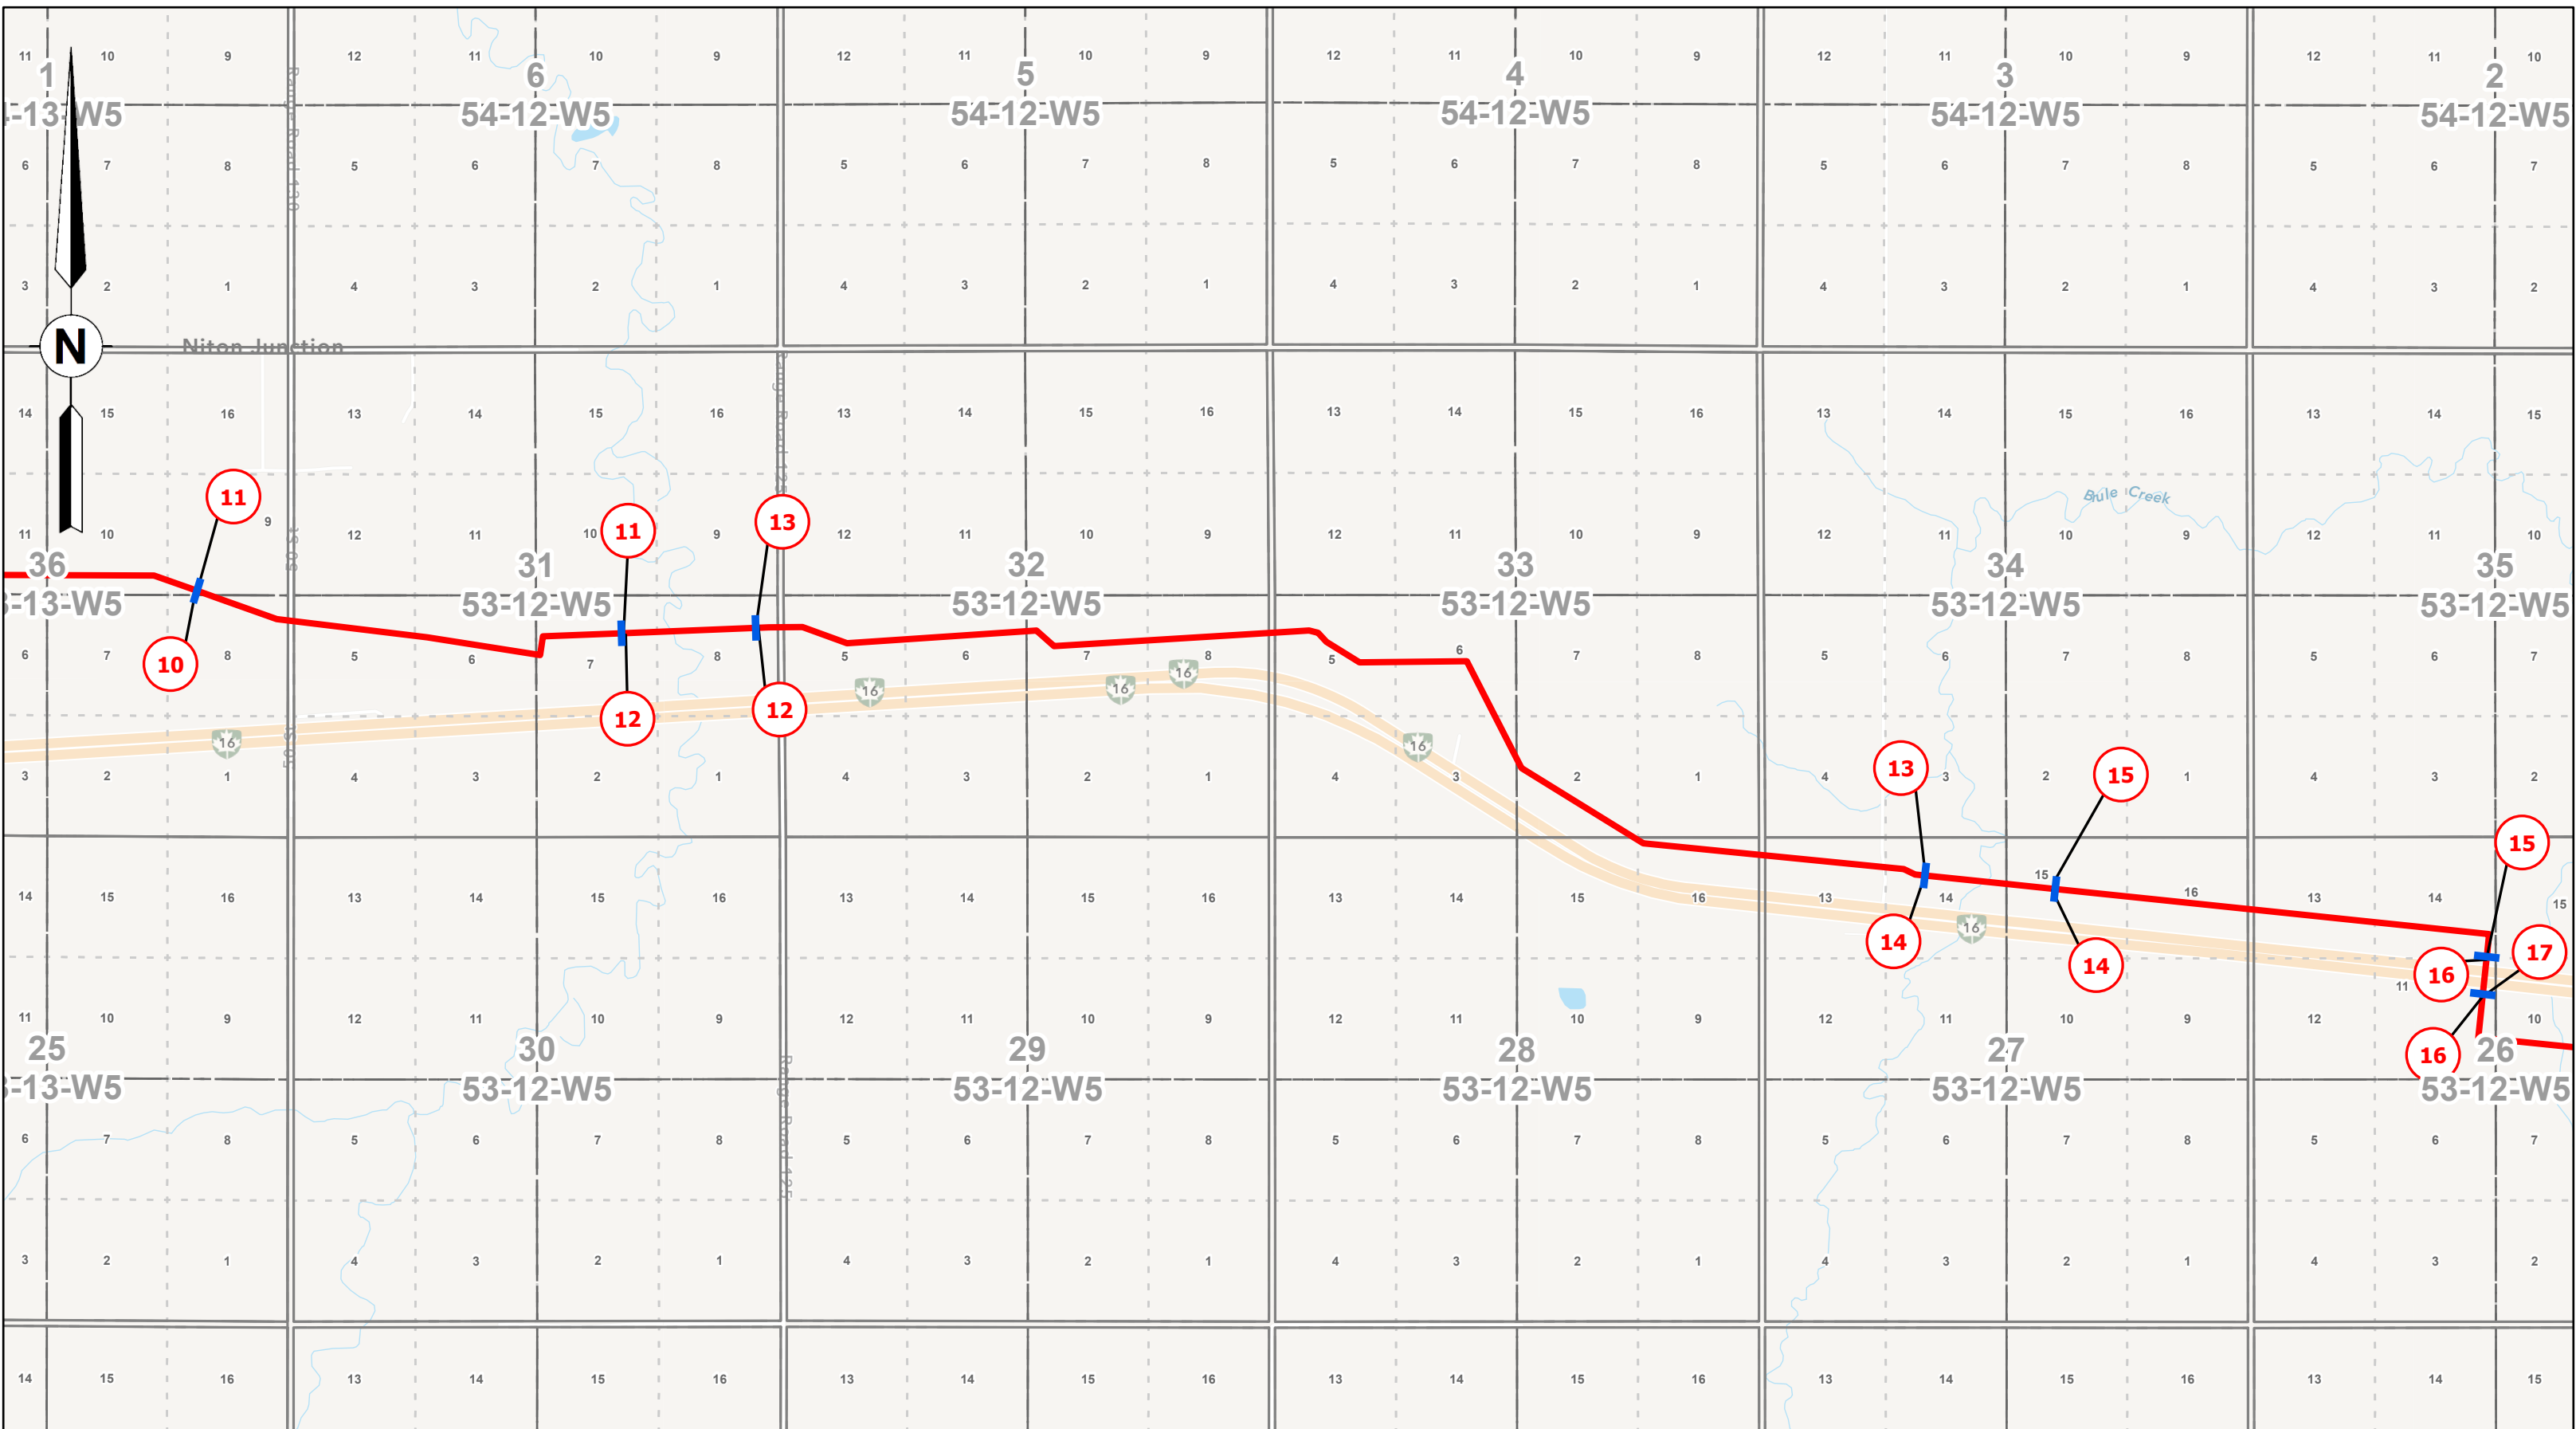




McElhanney Ltd.
100, 402 - 11th Avenue SE
Calgary, Alberta T2G 0Y4
T(403)245-4711



0	10/14/2025	Plan Issued
Rev	Date	Description

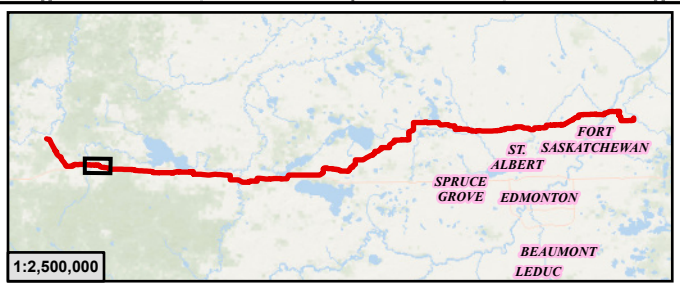

Legend

- PIPELINE PERMITTED, OPERATING OR DE-LICENSED
- ABANDONED OR REMOVED PIPELINE
- PIPELINE SPLIT LOCATION
- LINE NUMBER FOR PERMITTED, OPERATING OR DE-LICENCED PIPELINE
- LINE NUMBER FOR ABANDONED OR REMOVED PIPELINE
- INSTALLATION NUMBER (COMPRESSOR STATION)

**ATCO Yellowhead Pipeline
AUC Facility Application**

**Installation Location and Site Plans within
NE-27-54-14-W5M To SE-15-55-21-W4M**

SCALE: 1:20,000

DC Num: N/A

JOB: 301100635

PLAN ID: AUC Facilities Application

License No.:

REV
0

GIS

TH


CHK

RD

DATE

10/14/2025

Page 4 of 27

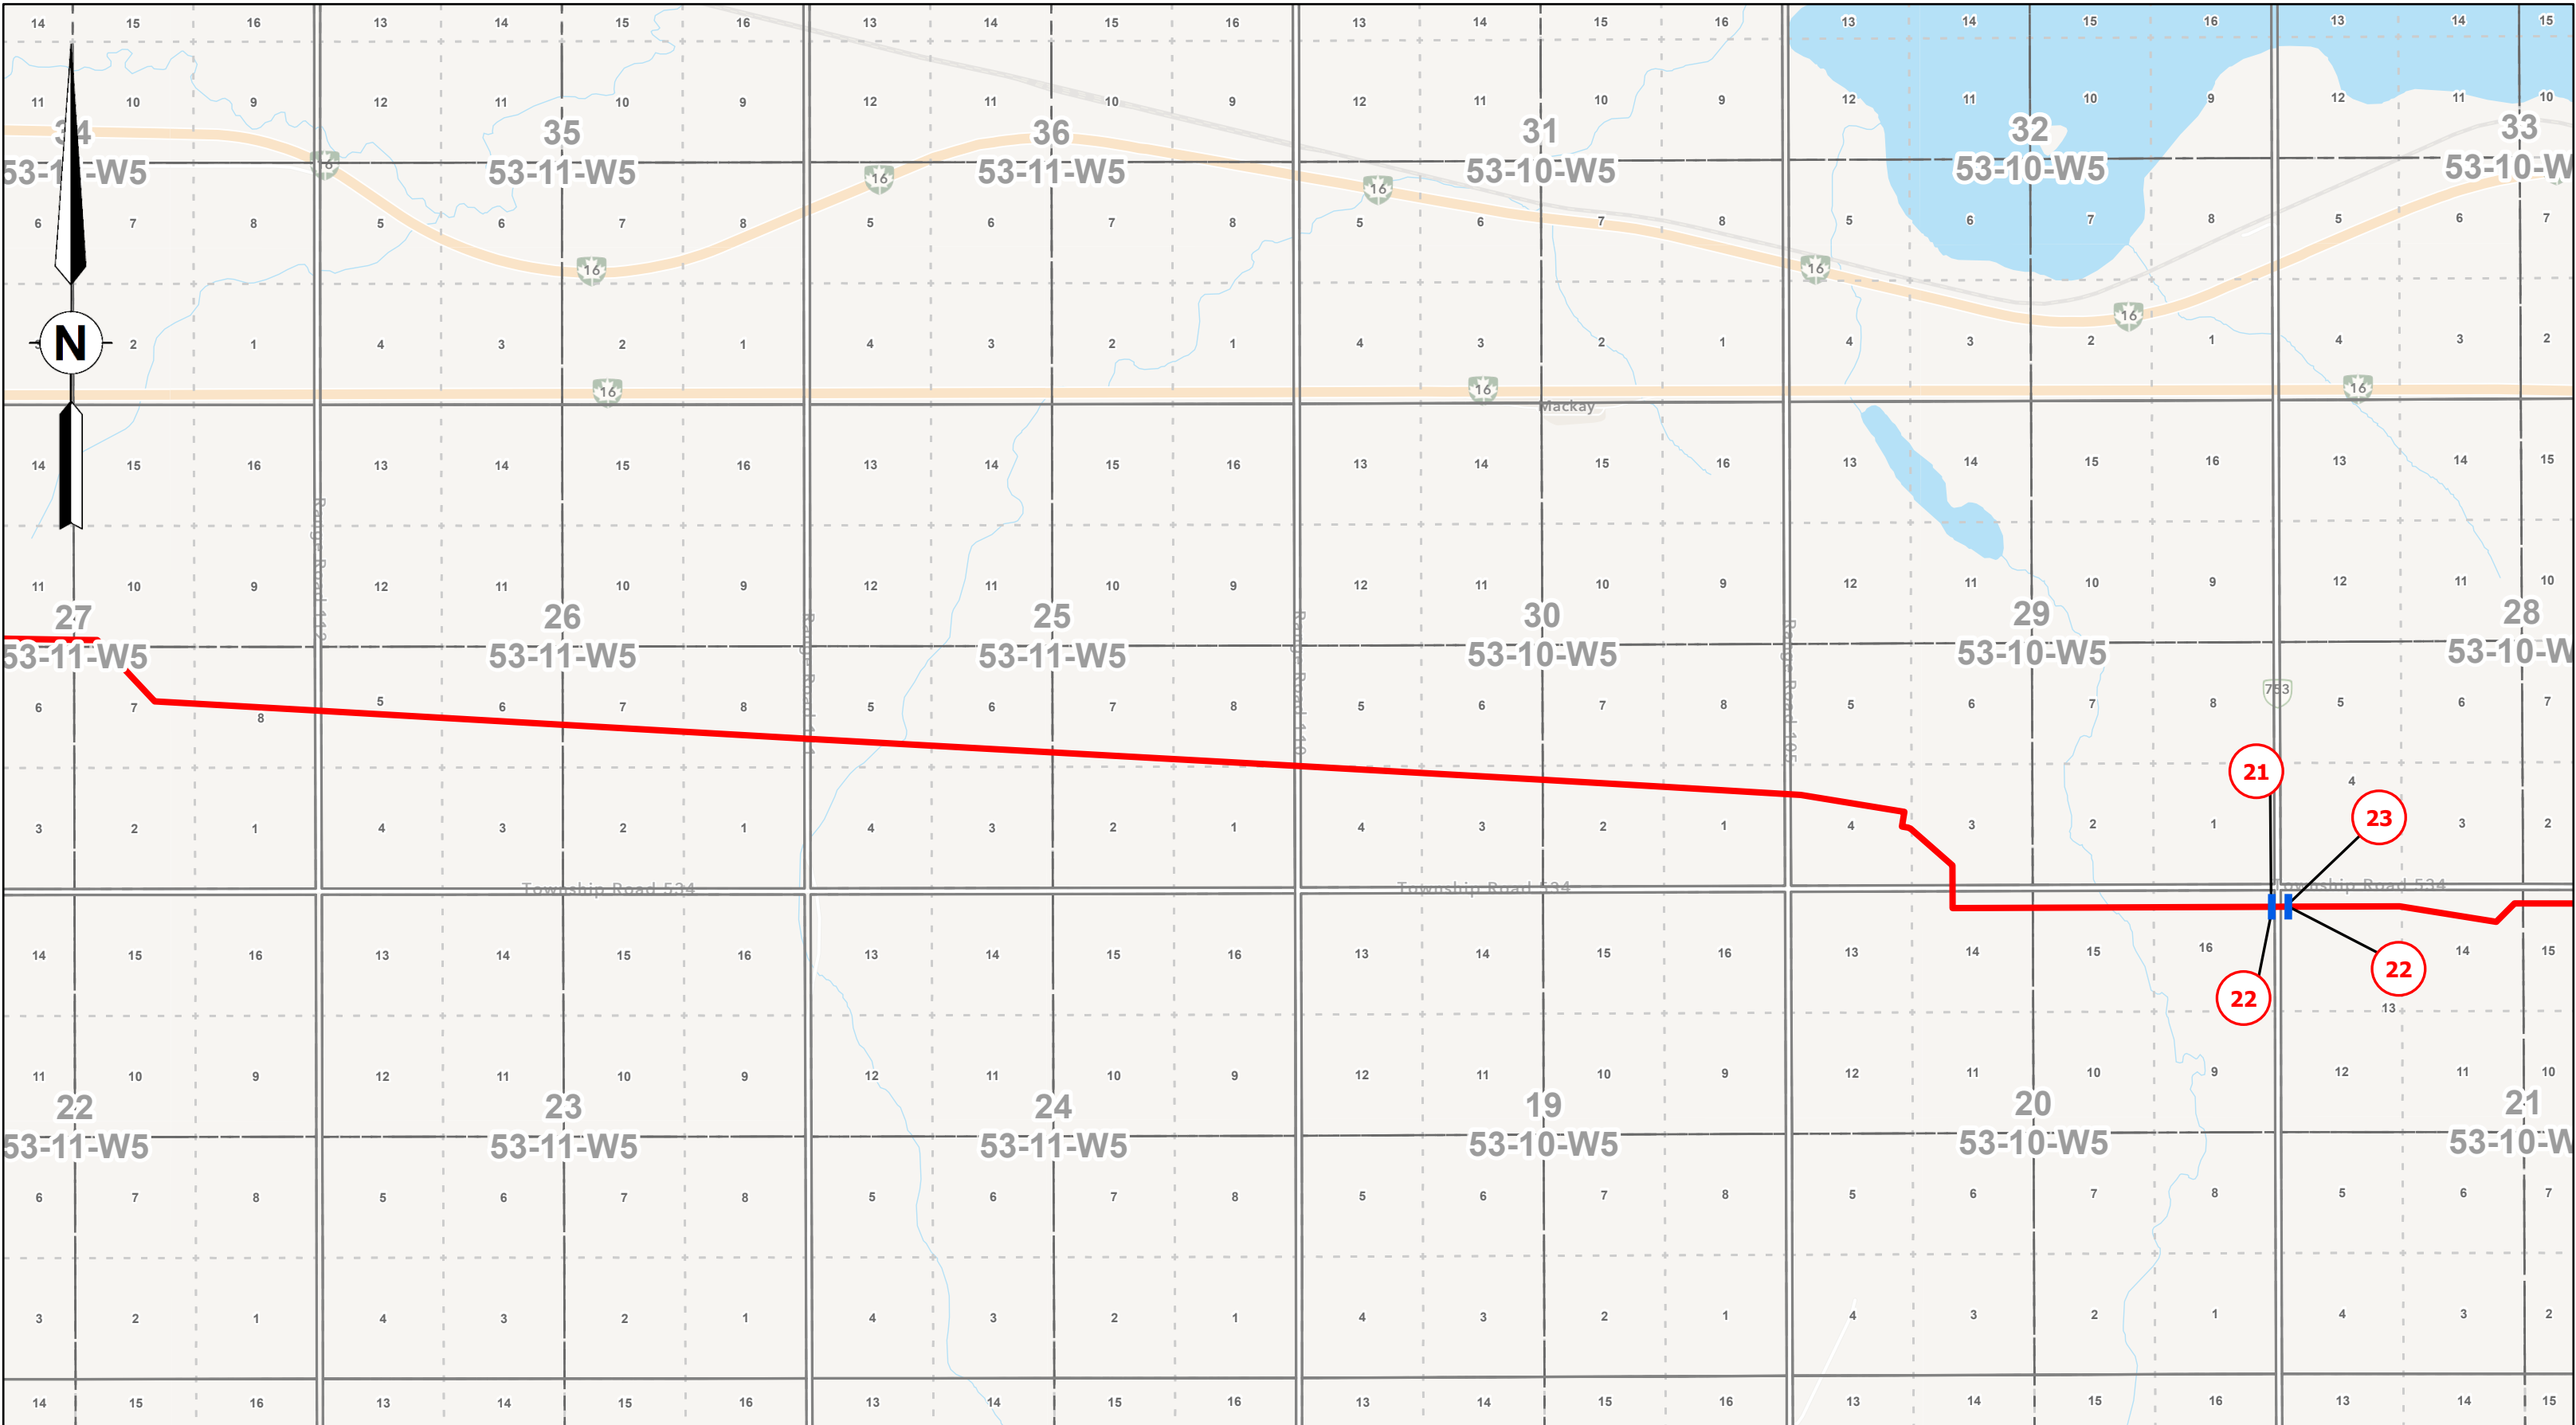




McElhanney Ltd.
100, 402 - 11th Avenue SE
Calgary, Alberta T2G 0Y4
T(403)245-4711



0	10/14/2025	Plan Issued
Rev	Date	Description

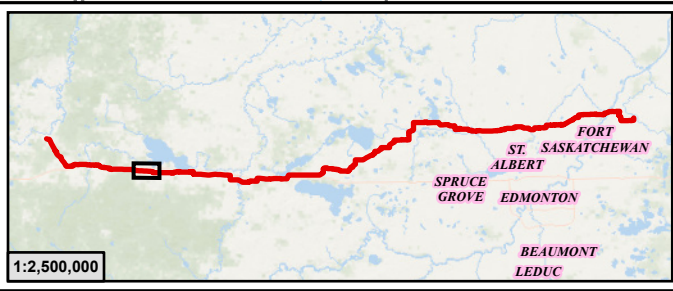

Legend

- PIPELINE PERMITTED, OPERATING OR DE-LICENSED
- ABANDONED OR REMOVED PIPELINE
- PIPELINE SPLIT LOCATION
- LINE NUMBER FOR PERMITTED, OPERATING OR DE-LICENCED PIPELINE
- LINE NUMBER FOR ABANDONED OR REMOVED PIPELINE
- INSTALLATION NUMBER (COMPRESSOR STATION)

**ATCO Yellowhead Pipeline
AUC Facility Application**

Installation Location and Site Plans within
NE-27-54-14-W5M To SE-15-55-21-W4M

SCALE: 1:20,000

DC Num: N/A

0 250 500 1,000 Metres

JOB: 301100635

PLAN ID: AUC Facilities Application

License No.:

REV
0

GIS

TH


CHK

RD

DATE

10/14/2025

Page 6 of 27

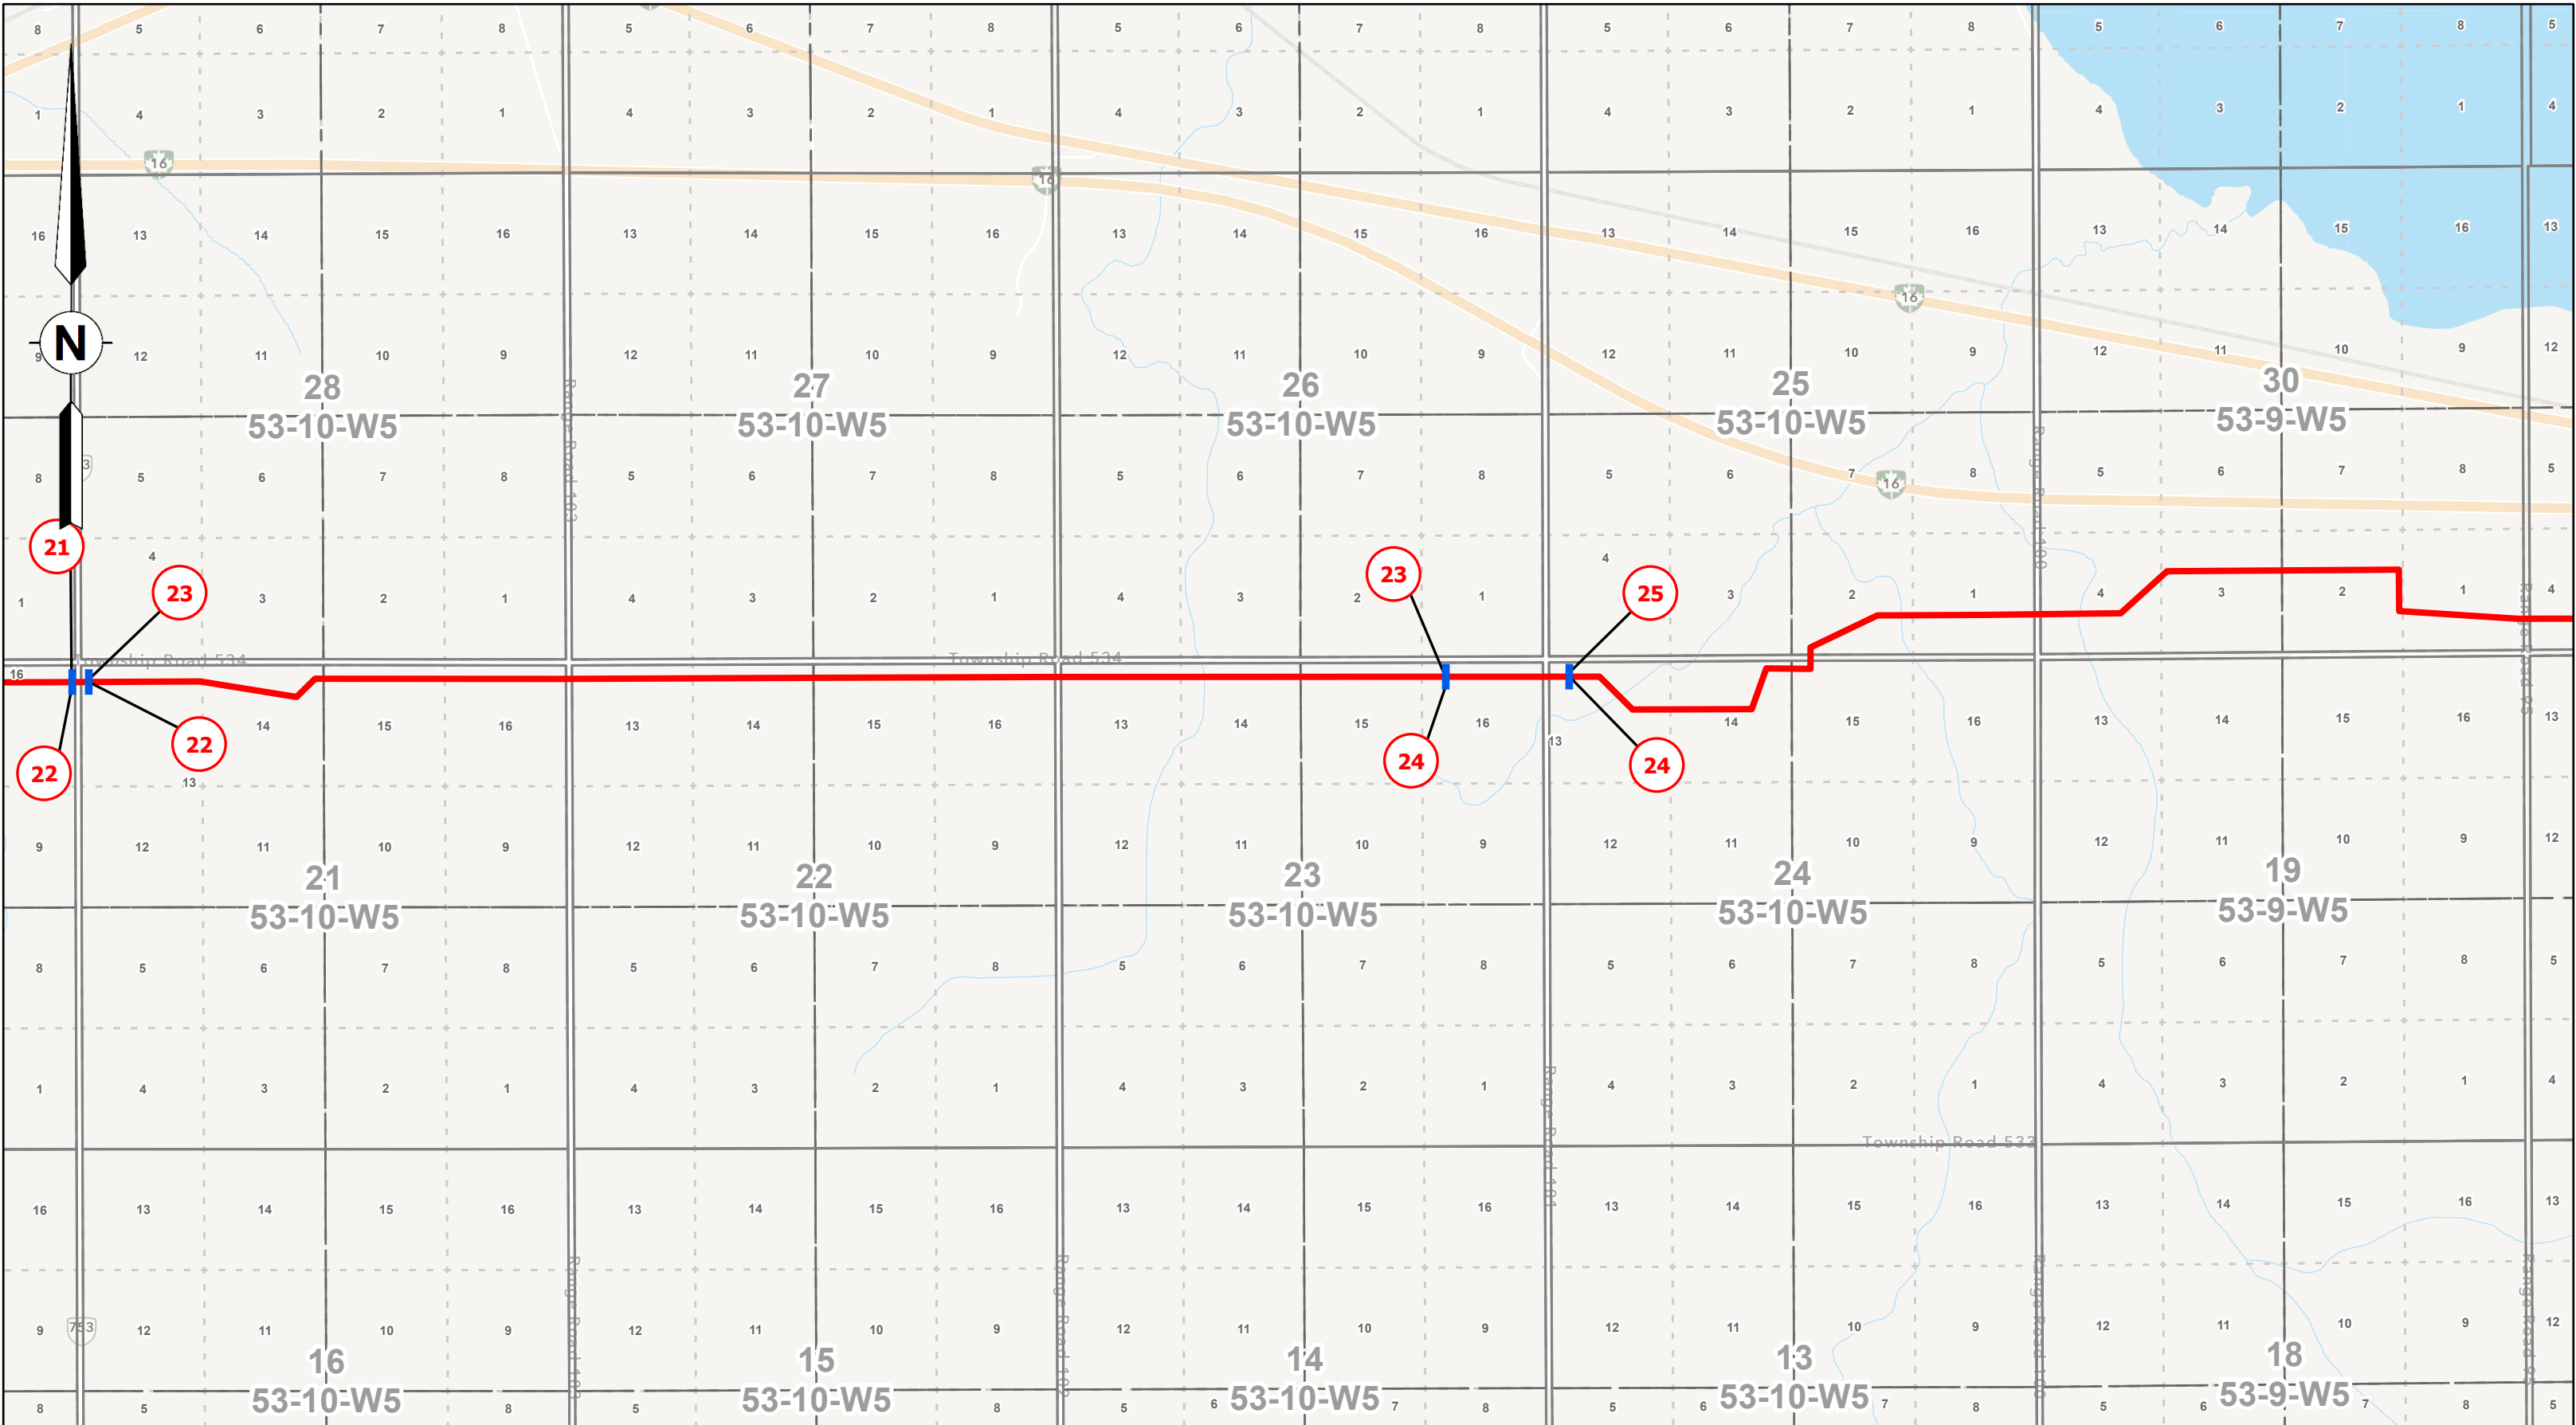




McElhanney Ltd.
100, 402 - 11th Avenue SE
Calgary, Alberta T2G 0Y4
T(403)245-4711



0	10/14/2025	Plan Issued
Rev	Date	Description

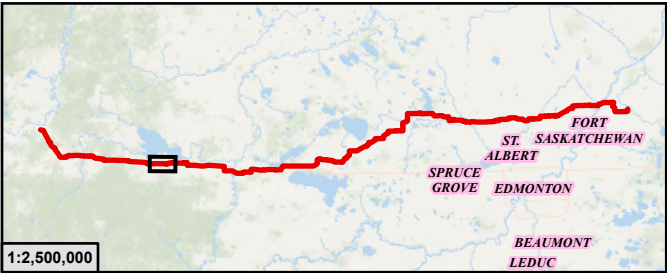


- Legend**
- PIPELINE PERMITTED, OPERATING OR DE-LICENSED
 - ABANDONED OR REMOVED PIPELINE
 - PIPELINE SPLIT LOCATION
 - LINE NUMBER FOR PERMITTED, OPERATING OR DE-LICENCED PIPELINE
 - LINE NUMBER FOR ABANDONED OR REMOVED PIPELINE
 - INSTALLATION NUMBER (COMPRESSOR STATION)

**ATCO Yellowhead Pipeline
AUC Facility Application**

**Installation Location and Site Plans with
NE-27-54-14-W5M To SE-15-55-21-W4M**

SCALE: 1:20,000

 DC Num: N/A



JOB: 301100635

PLAN ID: AUC Facilities Application

License No.:

REV
0

GIS

TH


CHK

RD

DATE

10/14/2025

Page 7 of 27

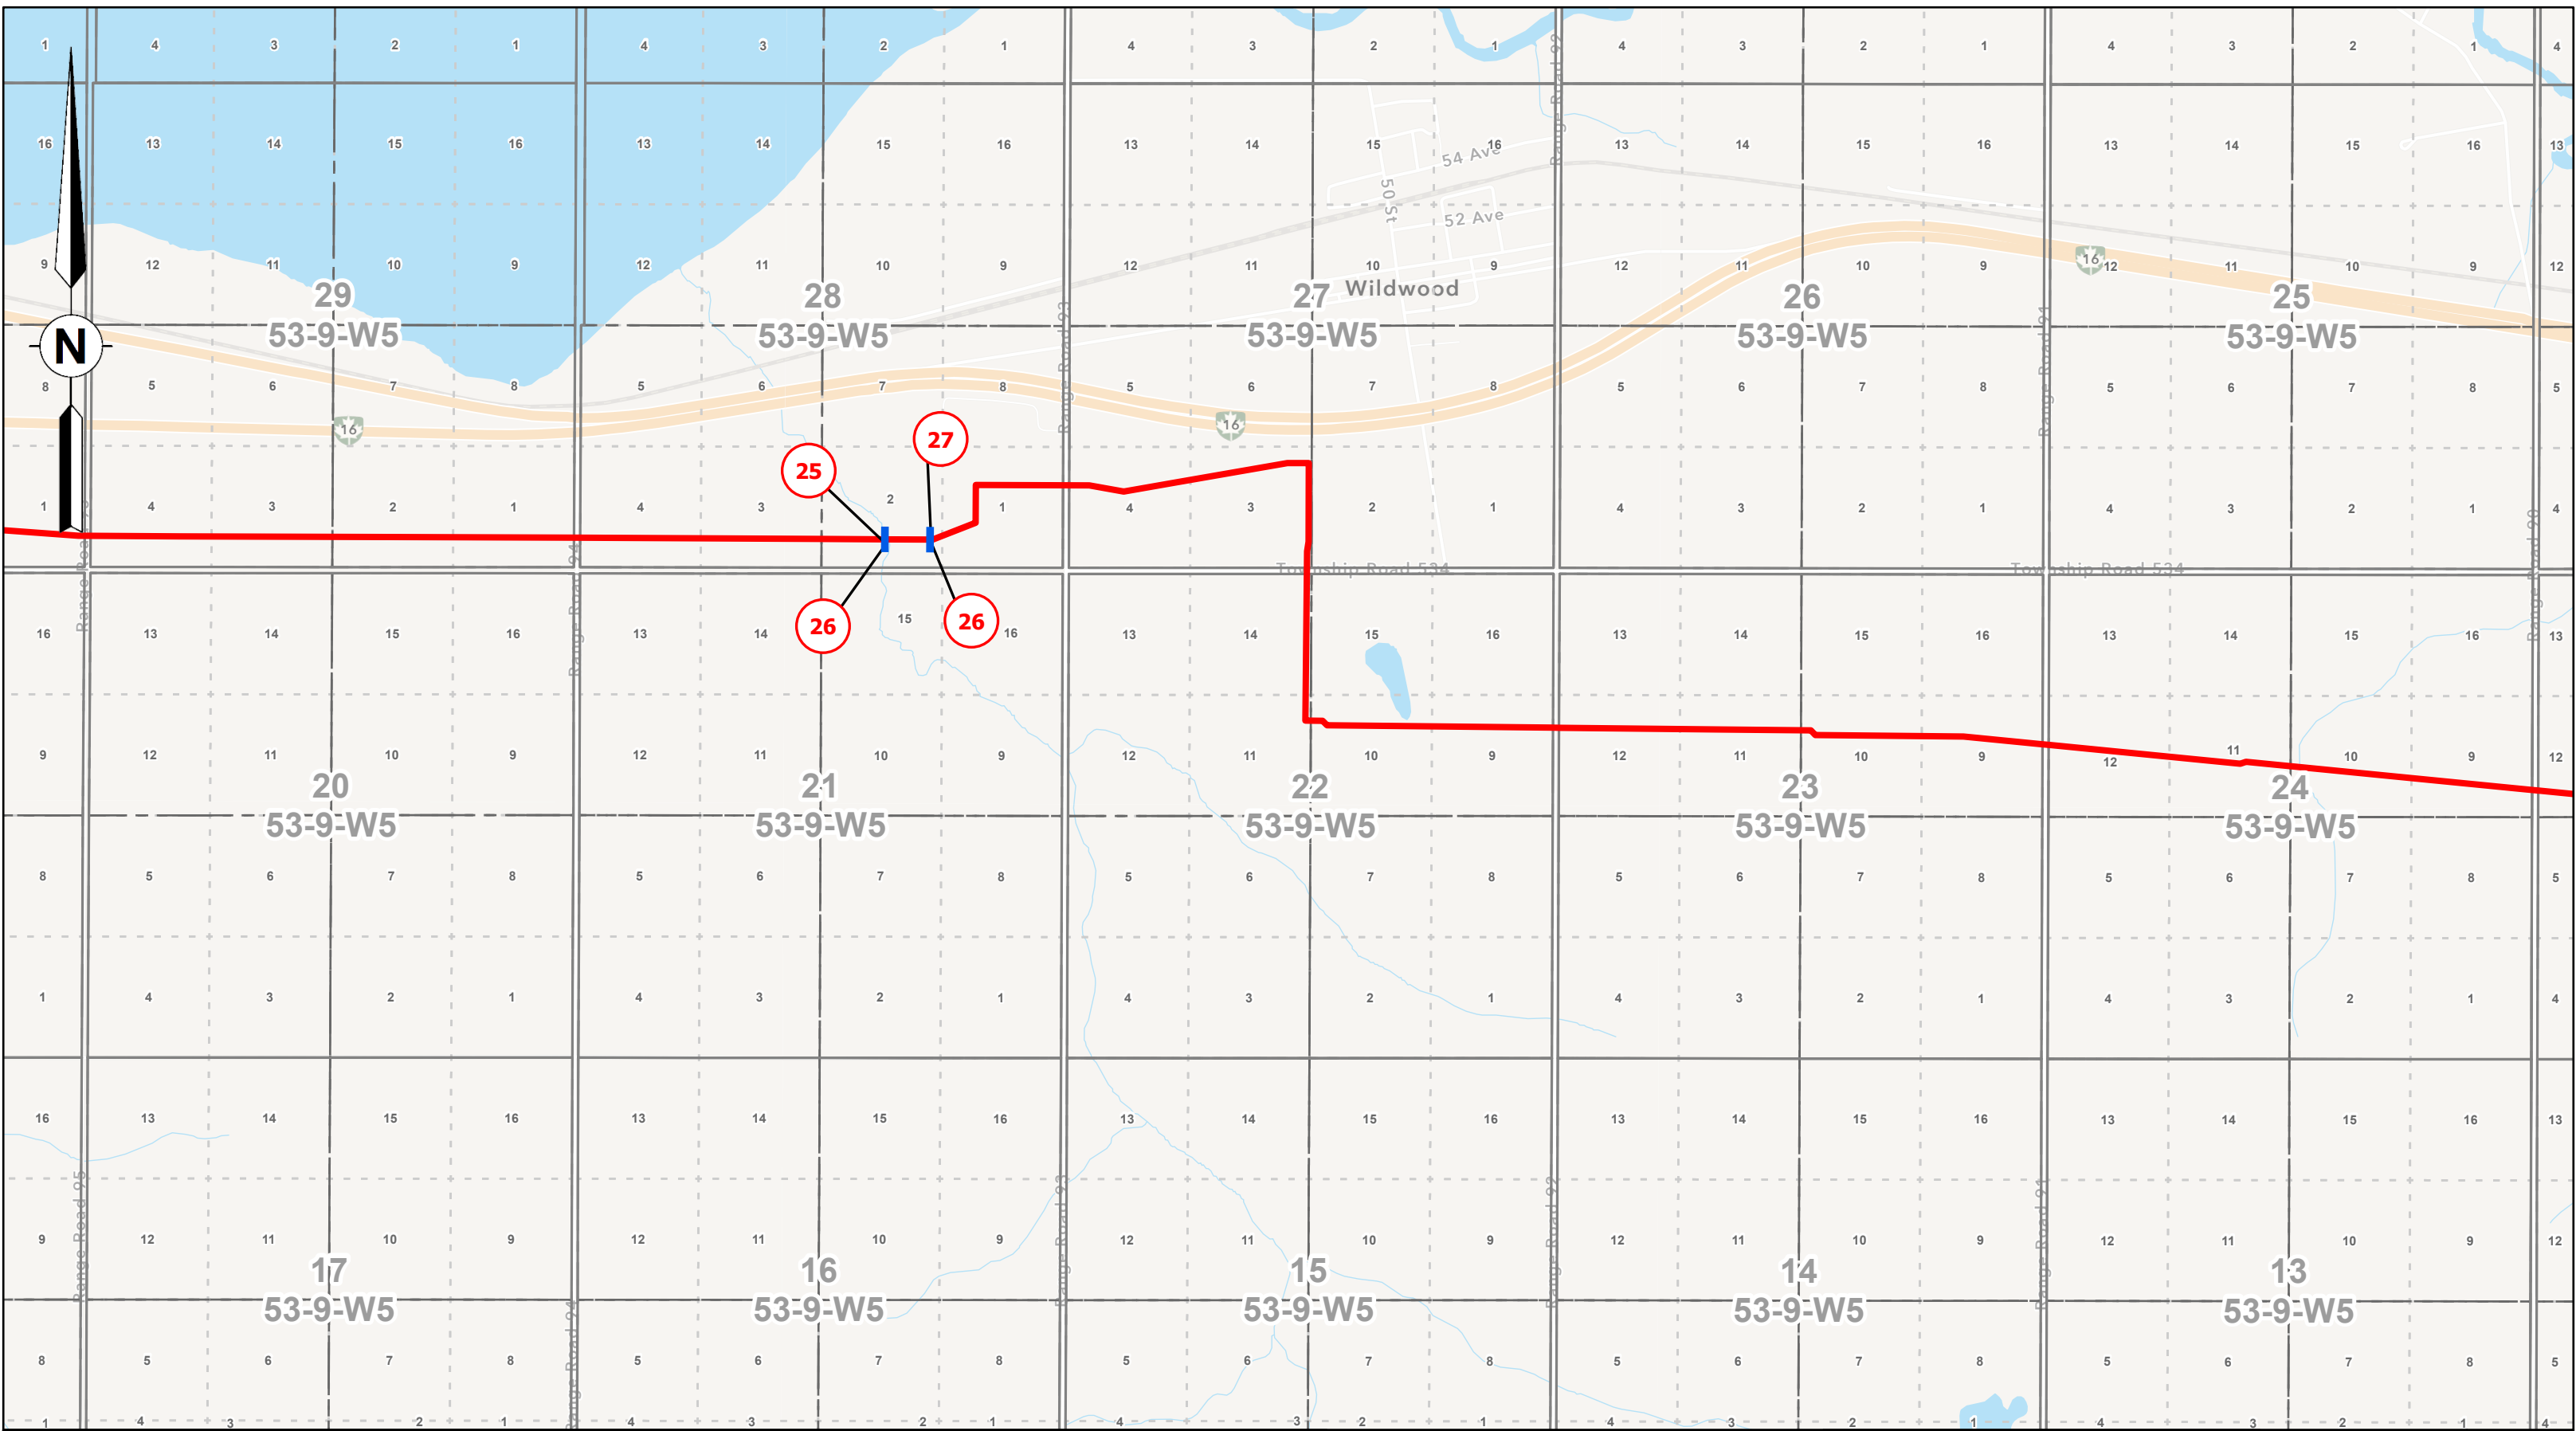




McElhanney Ltd.
100, 402 - 11th Avenue SE
Calgary, Alberta T2G 0Y4
T(403)245-4711



0	10/14/2025	Plan Issued
Rev	Date	Description

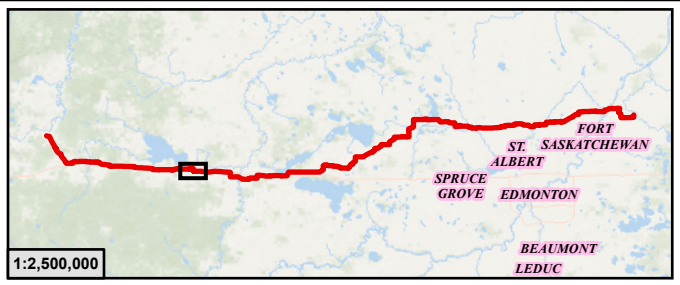

Legend

- PIPELINE PERMITTED, OPERATING OR DE-LICENSED
- ABANDONED OR REMOVED PIPELINE
- PIPELINE SPLIT LOCATION
- LINE NUMBER FOR PERMITTED, OPERATING OR DE-LICENCED PIPELINE
- LINE NUMBER FOR ABANDONED OR REMOVED PIPELINE
- INSTALLATION NUMBER (COMPRESSOR STATION)

**ATCO Yellowhead Pipeline
AUC Facility Application**

Installation Location and Site Plans within
NE-27-54-14-W5M To SE-15-55-21-W4M

SCALE: 1:20,000

DC Num: N/A

0 250 500 1,000 Metres

JOB: 301100635

PLAN ID: AUC Facilities Application

License No.:

REV
0

GIS

TH


CHK

RD

DATE

10/14/2025

Page 8 of 27

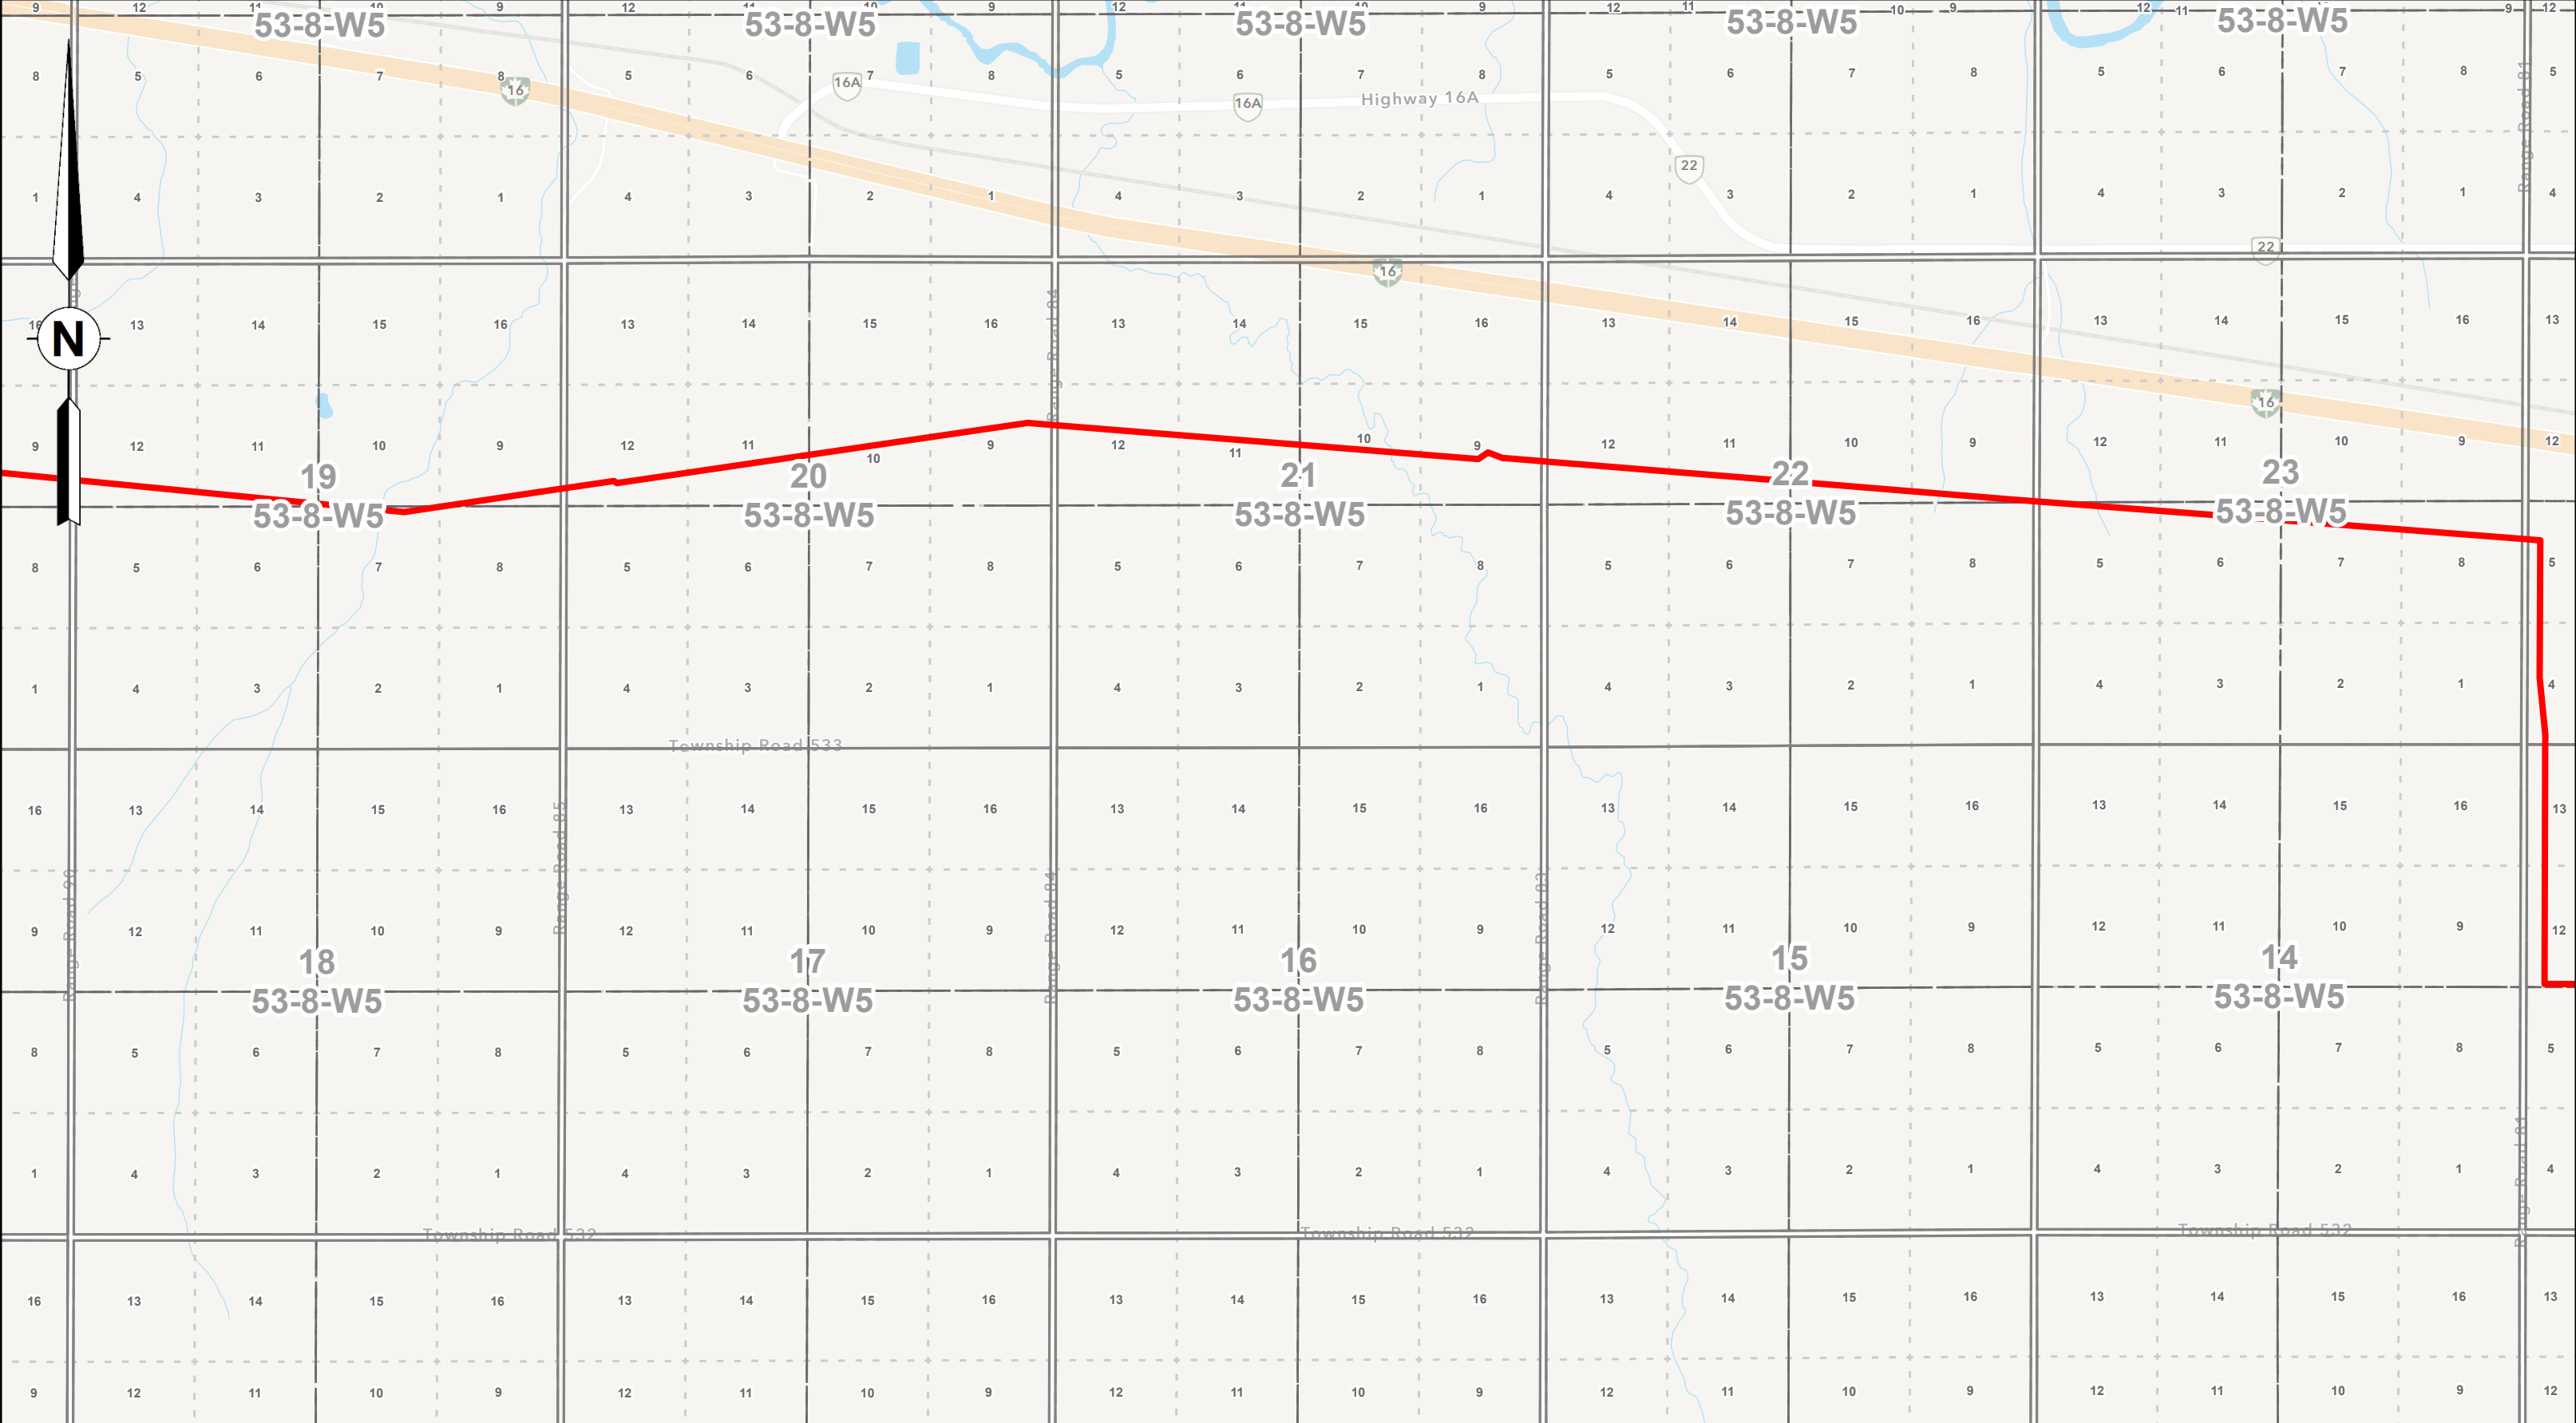




McElhanney Ltd.
100, 402 - 11th Avenue SE
Calgary, Alberta T2G 0Y4
T(403)245-4711



0	10/14/2025	Plan Issued
Rev	Date	Description

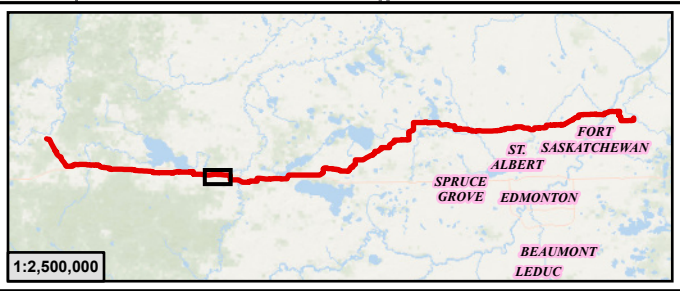

Legend

 
- PIPELINE PERMITTED, OPERATING OR DE-LICENSED
- ABANDONED OR REMOVED PIPELINE
- PIPELINE SPLIT LOCATION
- LINE NUMBER FOR PERMITTED, OPERATING OR DE-LICENCED PIPELINE
- LINE NUMBER FOR ABANDONED OR REMOVED PIPELINE
- INSTALLATION NUMBER (COMPRESSOR STATION)

**ATCO Yellowhead Pipeline
AUC Facility Application**

Installation Location and Site Plans within
NE-27-54-14-W5M To SE-15-55-21-W4M

SCALE: 1:20,000

DC Num: N/A



JOB: 301100635

PLAN ID: AUC Facilities Application

License No.:

REV
0

GIS

TH


CHK

RD

DATE

10/14/2025


Page 9 of 27

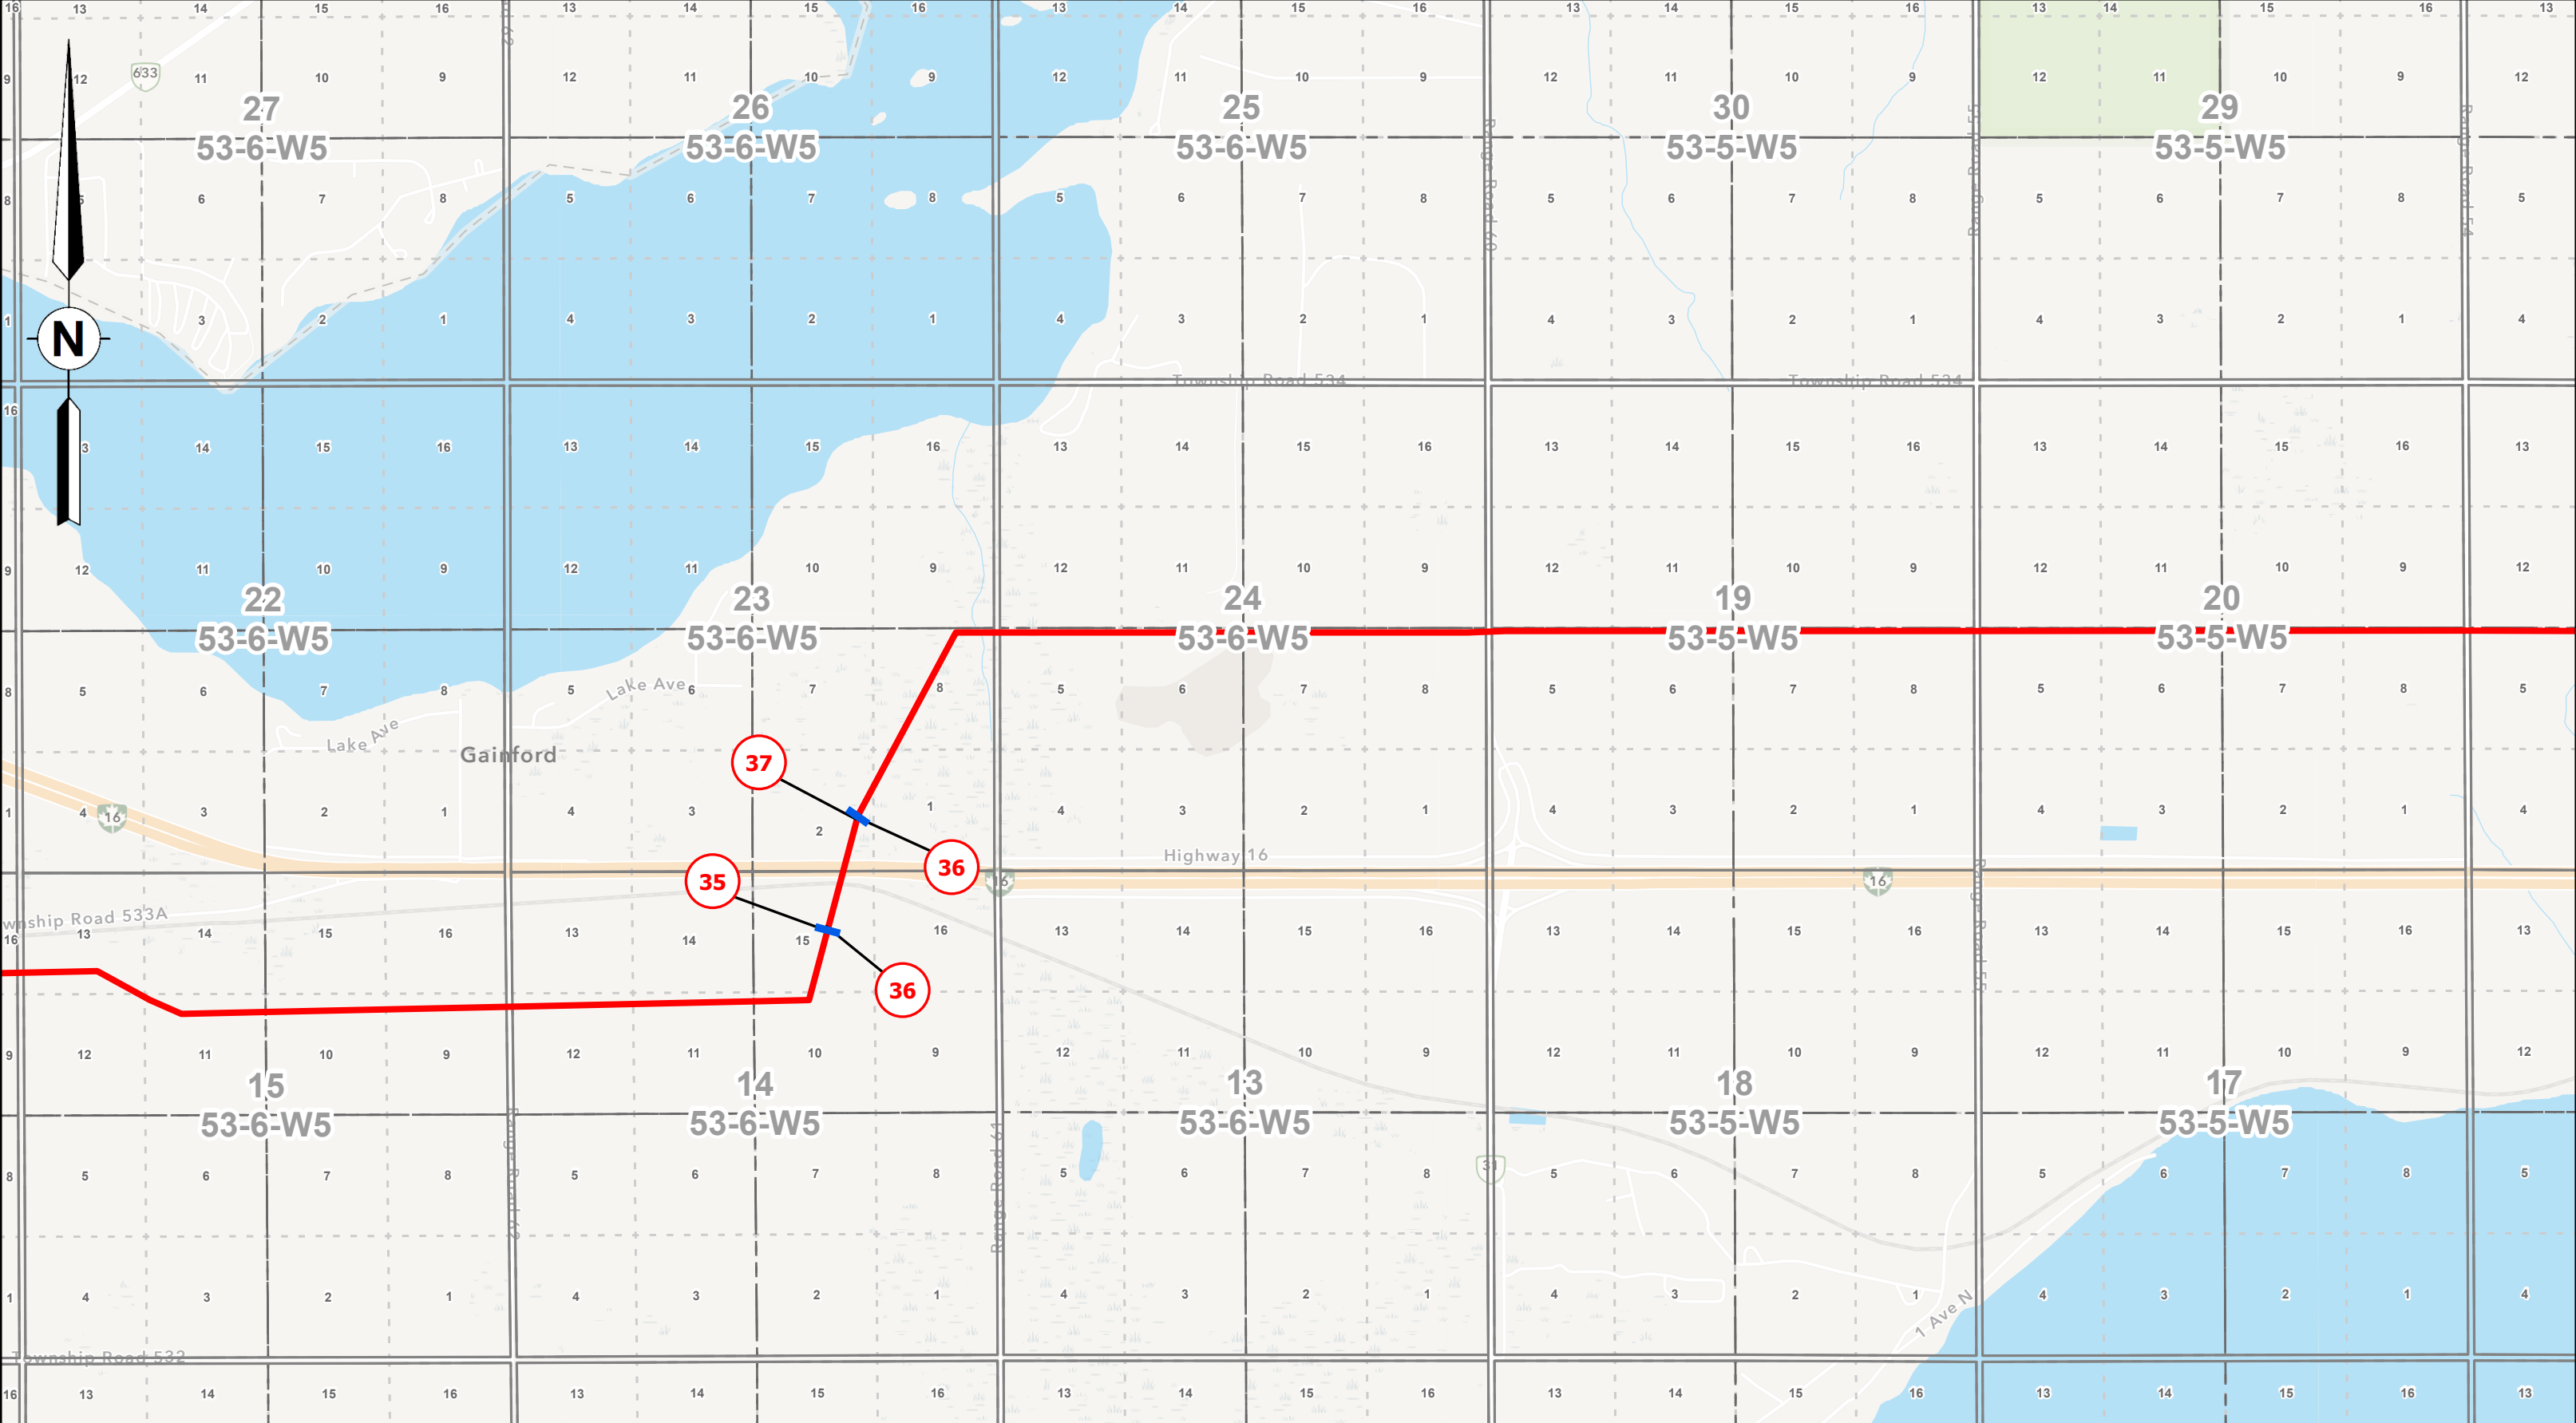



McElhanney Ltd.
100, 402 - 11th Avenue SE
Calgary, Alberta T2G 0Y4
T(403)245-4711



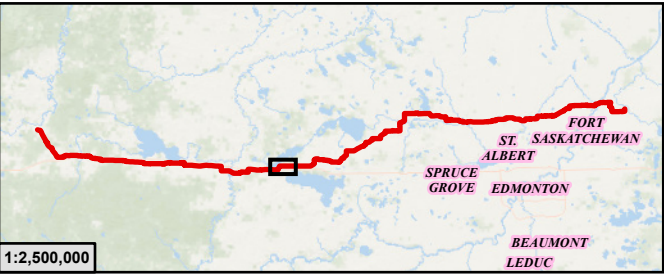

Legend

- PIPELINE PERMITTED, OPERATING OR DE-LICENSED
- ABANDONED OR REMOVED PIPELINE
- PIPELINE SPLIT LOCATION
- LINE NUMBER FOR PERMITTED, OPERATING OR DE-LICENCED PIPELINE
- LINE NUMBER FOR ABANDONED OR REMOVED PIPELINE
- INSTALLATION NUMBER (COMPRESSOR STATION)

**ATCO Yellowhead Pipeline
AUC Facility Application**

**Installation Location and Site Plans within
NE-27-54-14-W5M To SE-15-55-21-W4M**

SCALE: 1:20,000

DC Num: N/A

02505001,000

Metres

JOB: 301100635

PLAN ID: AUC Facilities Application

License No.:

REV
0

GIS

TH

CHK


RD

DATE

10/14/2025

Page 12 of 27

0	10/14/2025	Plan Issued
Rev	Date	Description

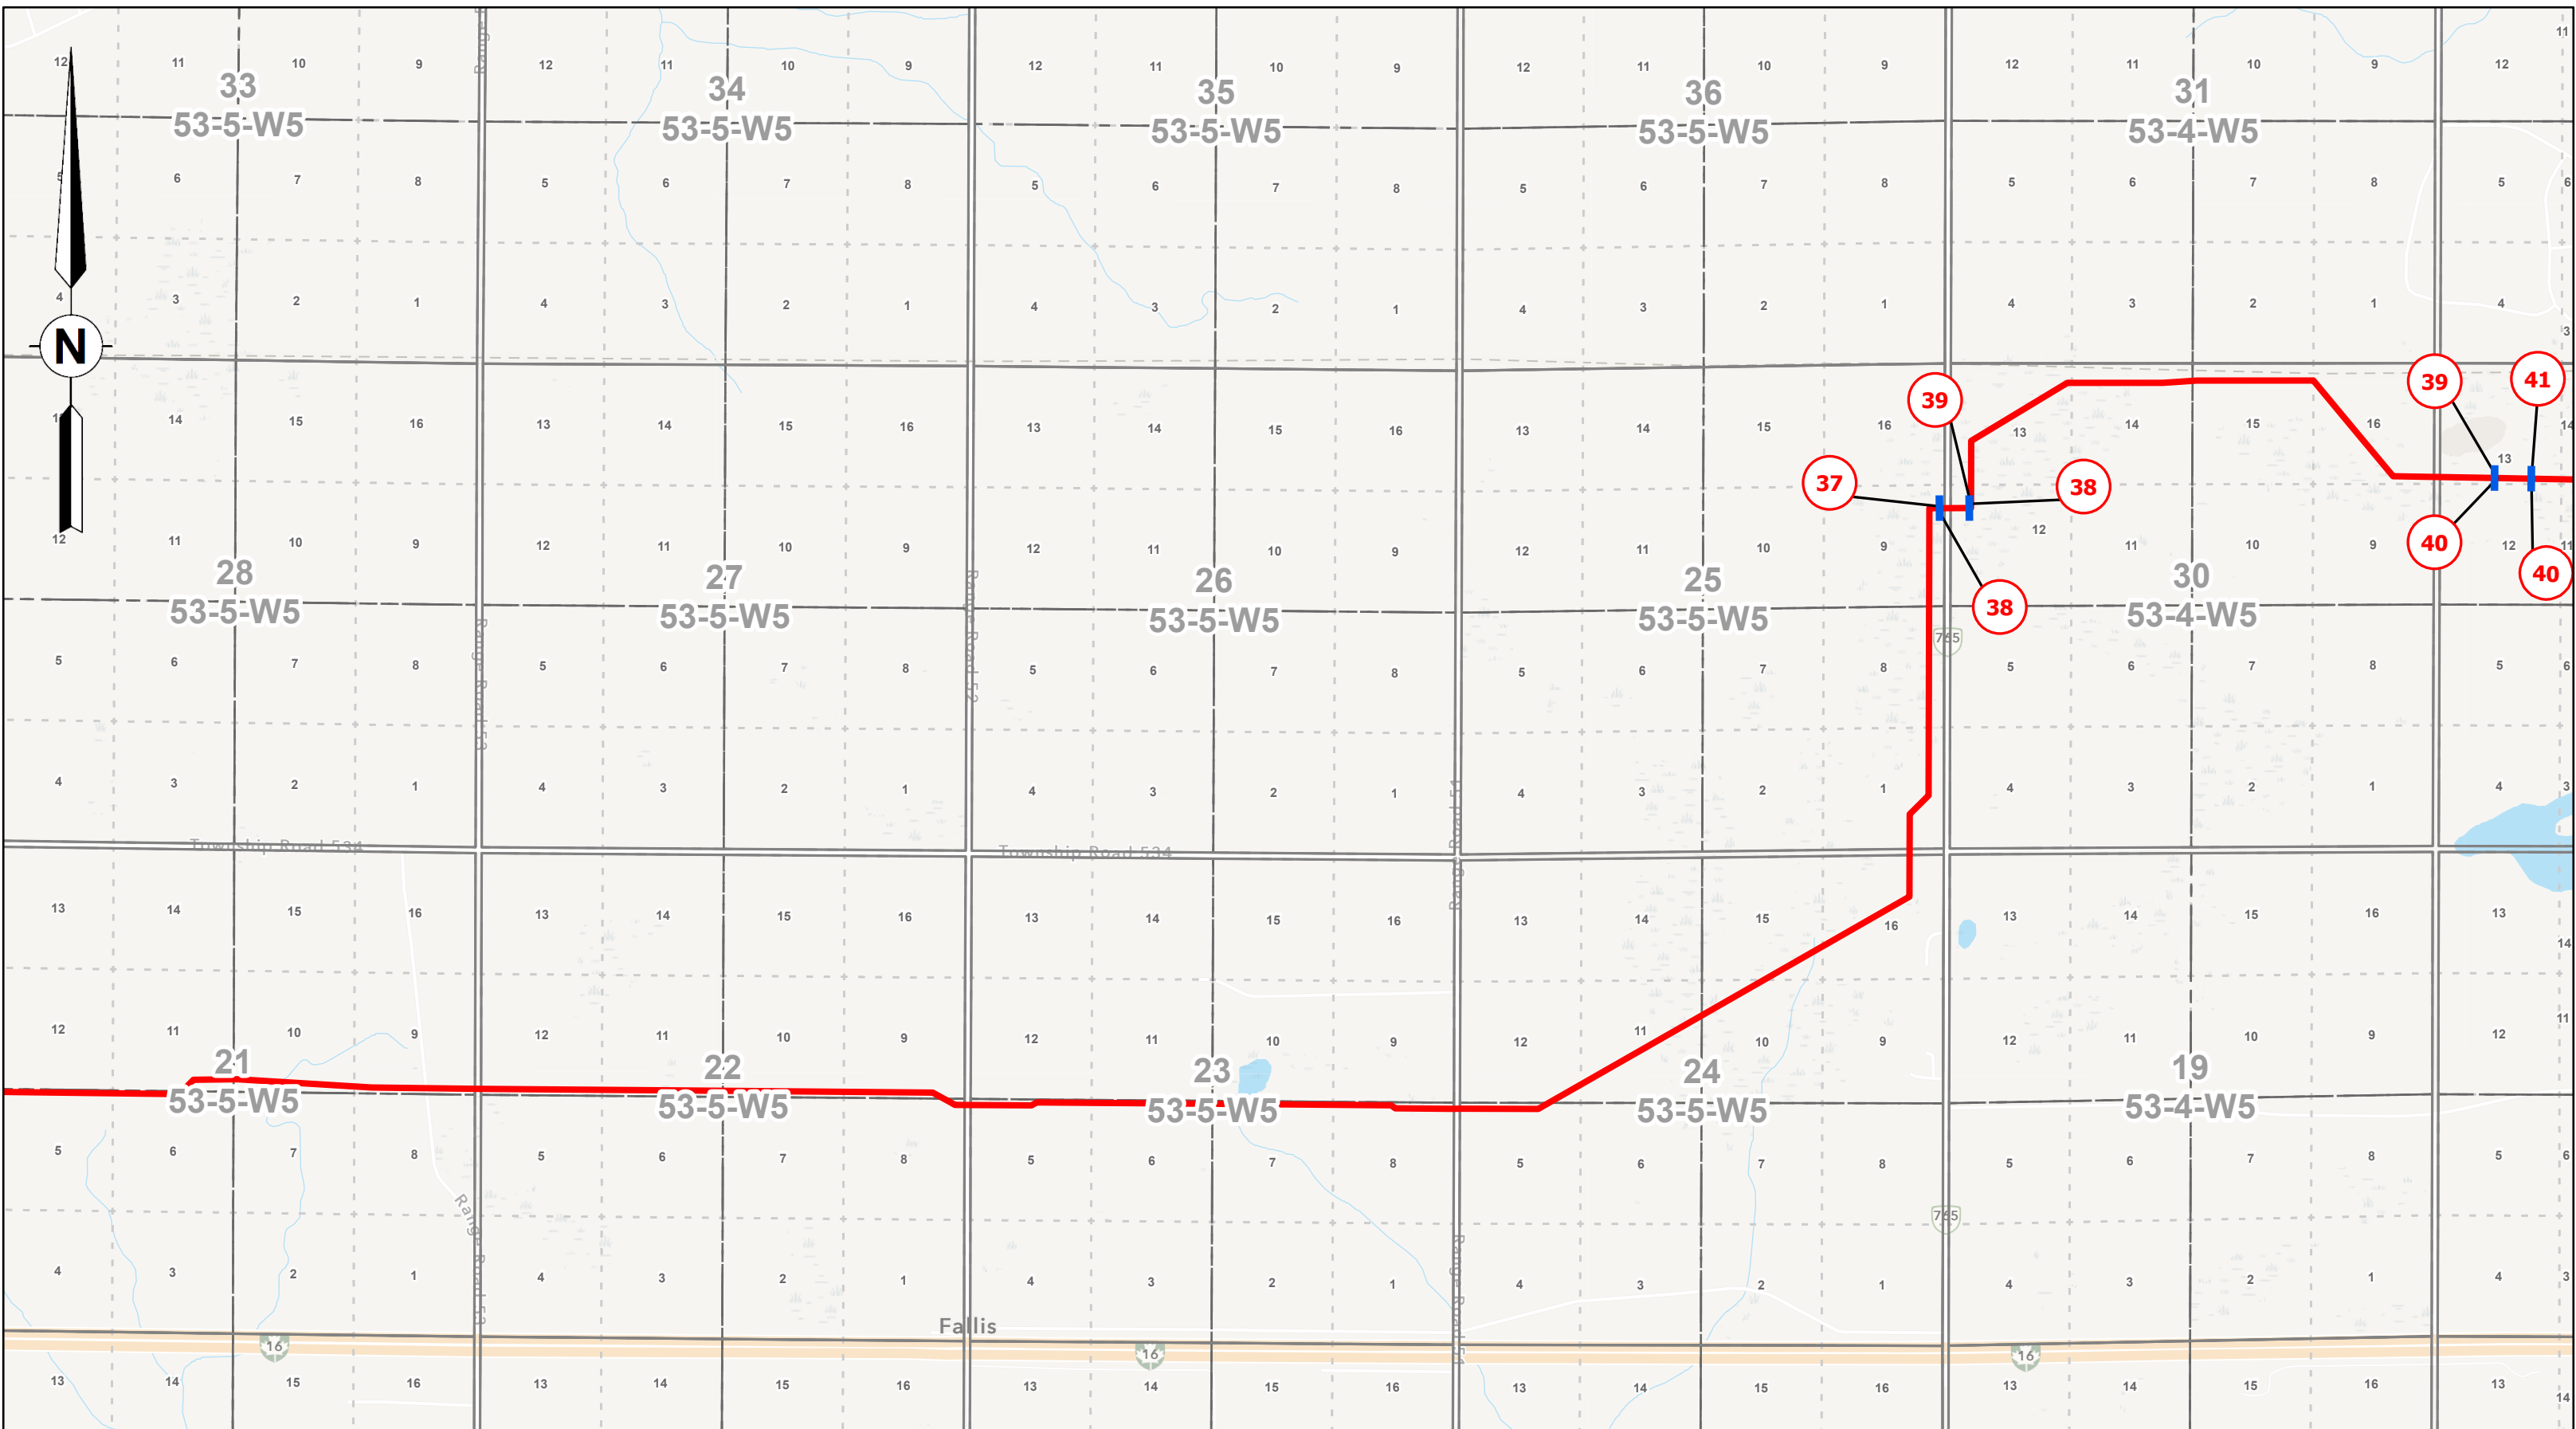




McElhanney Ltd.
100, 402 - 11th Avenue SE
Calgary, Alberta T2G 0Y4
T(403)245-4711



0	10/14/2025	Plan Issued
Rev	Date	Description

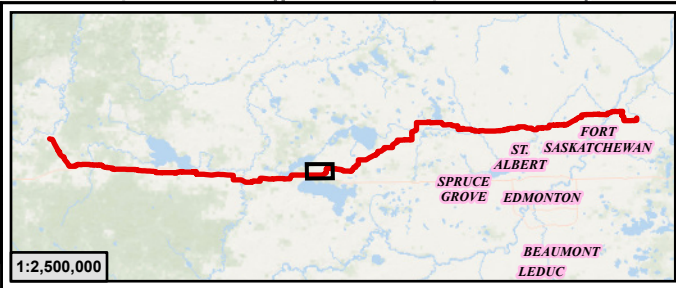

Legend

- PIPELINE PERMITTED, OPERATING OR DE-LICENSED
- ABANDONED OR REMOVED PIPELINE
- PIPELINE SPLIT LOCATION
- LINE NUMBER FOR PERMITTED, OPERATING OR DE-LICENCED PIPELINE
- LINE NUMBER FOR ABANDONED OR REMOVED PIPELINE
- INSTALLATION NUMBER (COMPRESSOR STATION)

ATCO Yellowhead Pipeline
AUC Facility Application

Installation Location and Site Plans within
NE-27-54-14-W5M To SE-15-55-21-W4M

SCALE: 1:20,000

DC Num: N/A

0 250 500 1,000 Metres

JOB: 301100635

PLAN ID: AUC Facilities Application

License No.:

REV
0


GIS TH

CHK RD

DATE 10/14/2025


Page 13 of 27

ATCO Yellowhead Pipeline AUC Facility Application				REV 0	
				GIS	TH
Installation Location and Site Plans within NE-27-54-14-W5M To SE-15-55-21-W4M				CHK	RD
				DATE	10/14/2023
SCALE: 1:20,000					
DC Num: N/A	JOB: 301100635	PLAN ID: AUC Facilities Application	License No.:	Page 14 of 27	

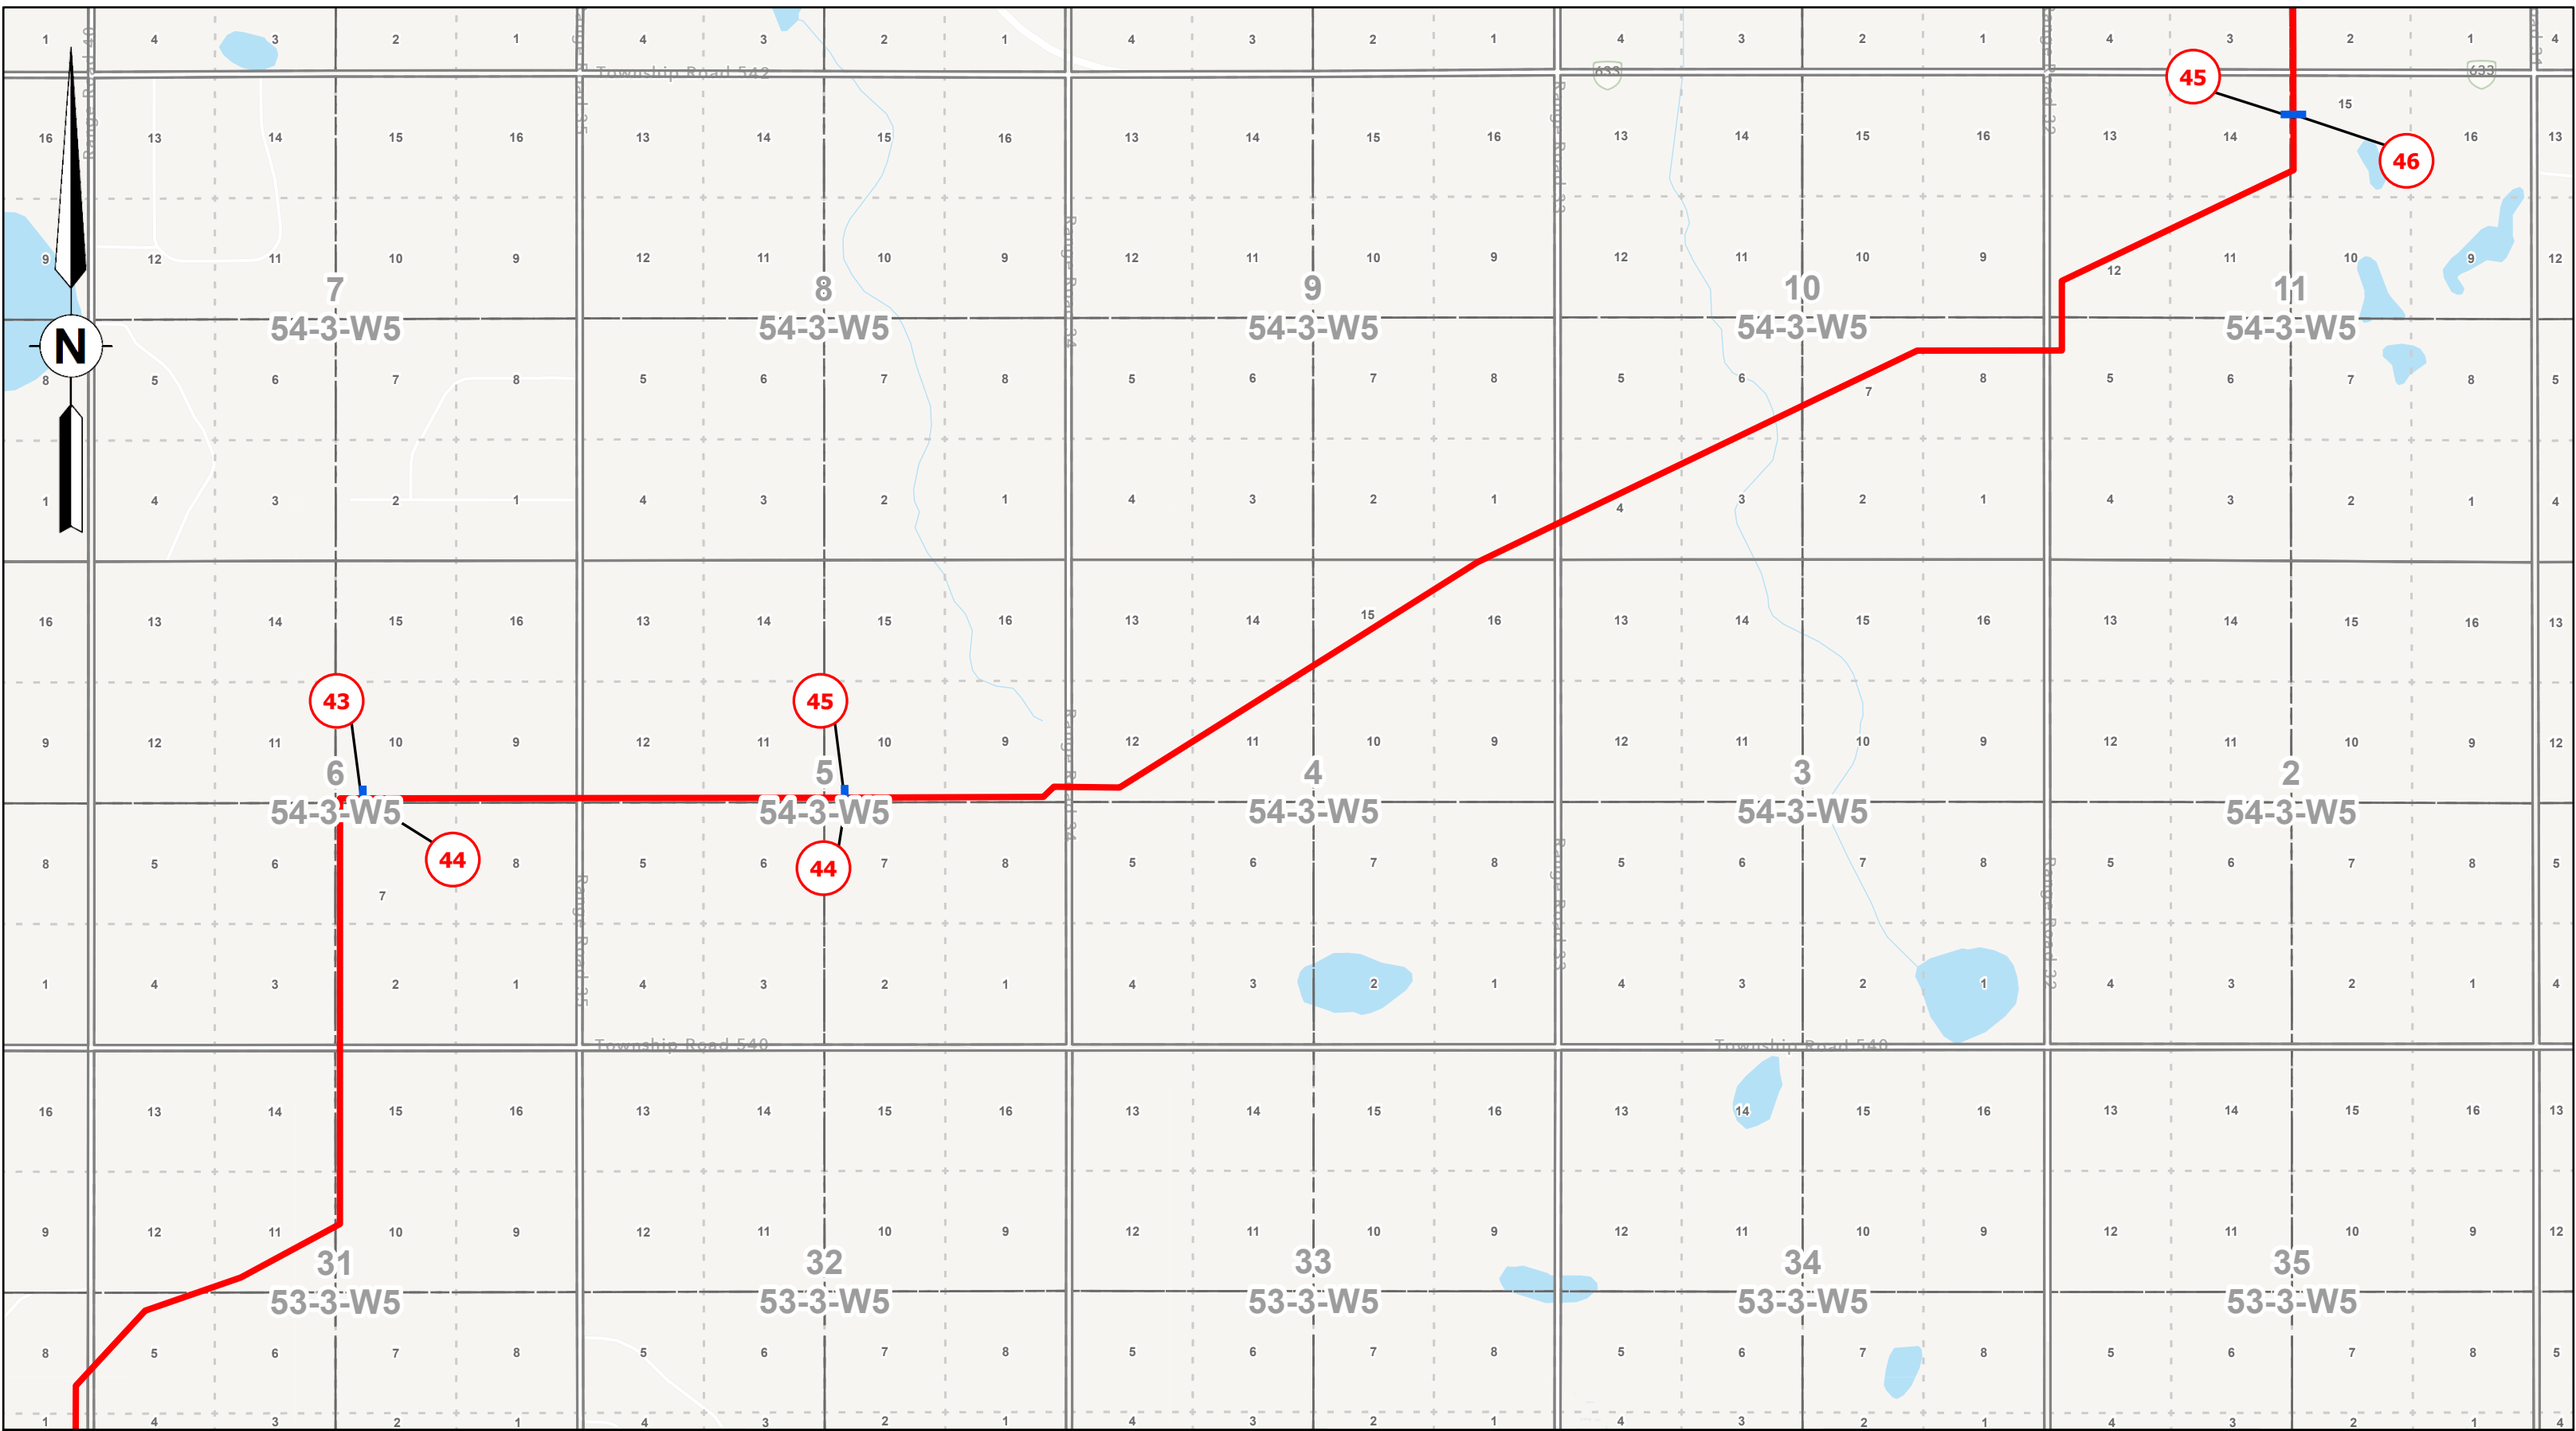



McElhanney Ltd.
100, 402 - 11th Avenue SE
Calgary, Alberta T2G 0Y4
T(403)245-4711

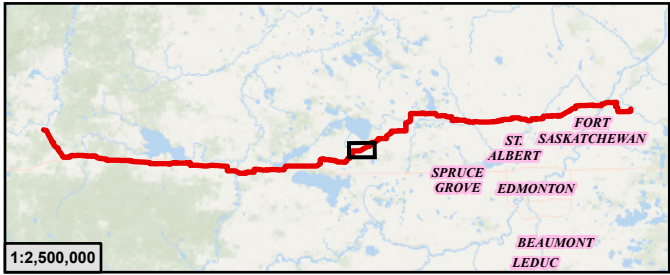


Legend

- PIPELINE PERMITTED, OPERATING OR DE-LICENSED
- ABANDONED OR REMOVED PIPELINE
- | PIPELINE SPLIT LOCATION
- LINE NUMBER FOR PERMITTED, OPERATING OR DE-LICENCED PIPELINE
- LINE NUMBER FOR ABANDONED OR REMOVED PIPELINE
- INSTALLATION NUMBER (COMPRESSOR STATION)

ATCO Yellowhead Pipeline AUC Facility Application

 Installation Location and Site Plans within NE-27-54-14-W5M To SE-15-55-21-W4M

SCALE: 1:20,000		DC Num: N/A	JOB: 301100635	PLAN ID: AUC Facilities Application	License No.:
-----------------	---	-------------	----------------	-------------------------------------	--------------

REV


0

GIS TH

CHK RD

DATE 10/14/2025

Page 15 of 27

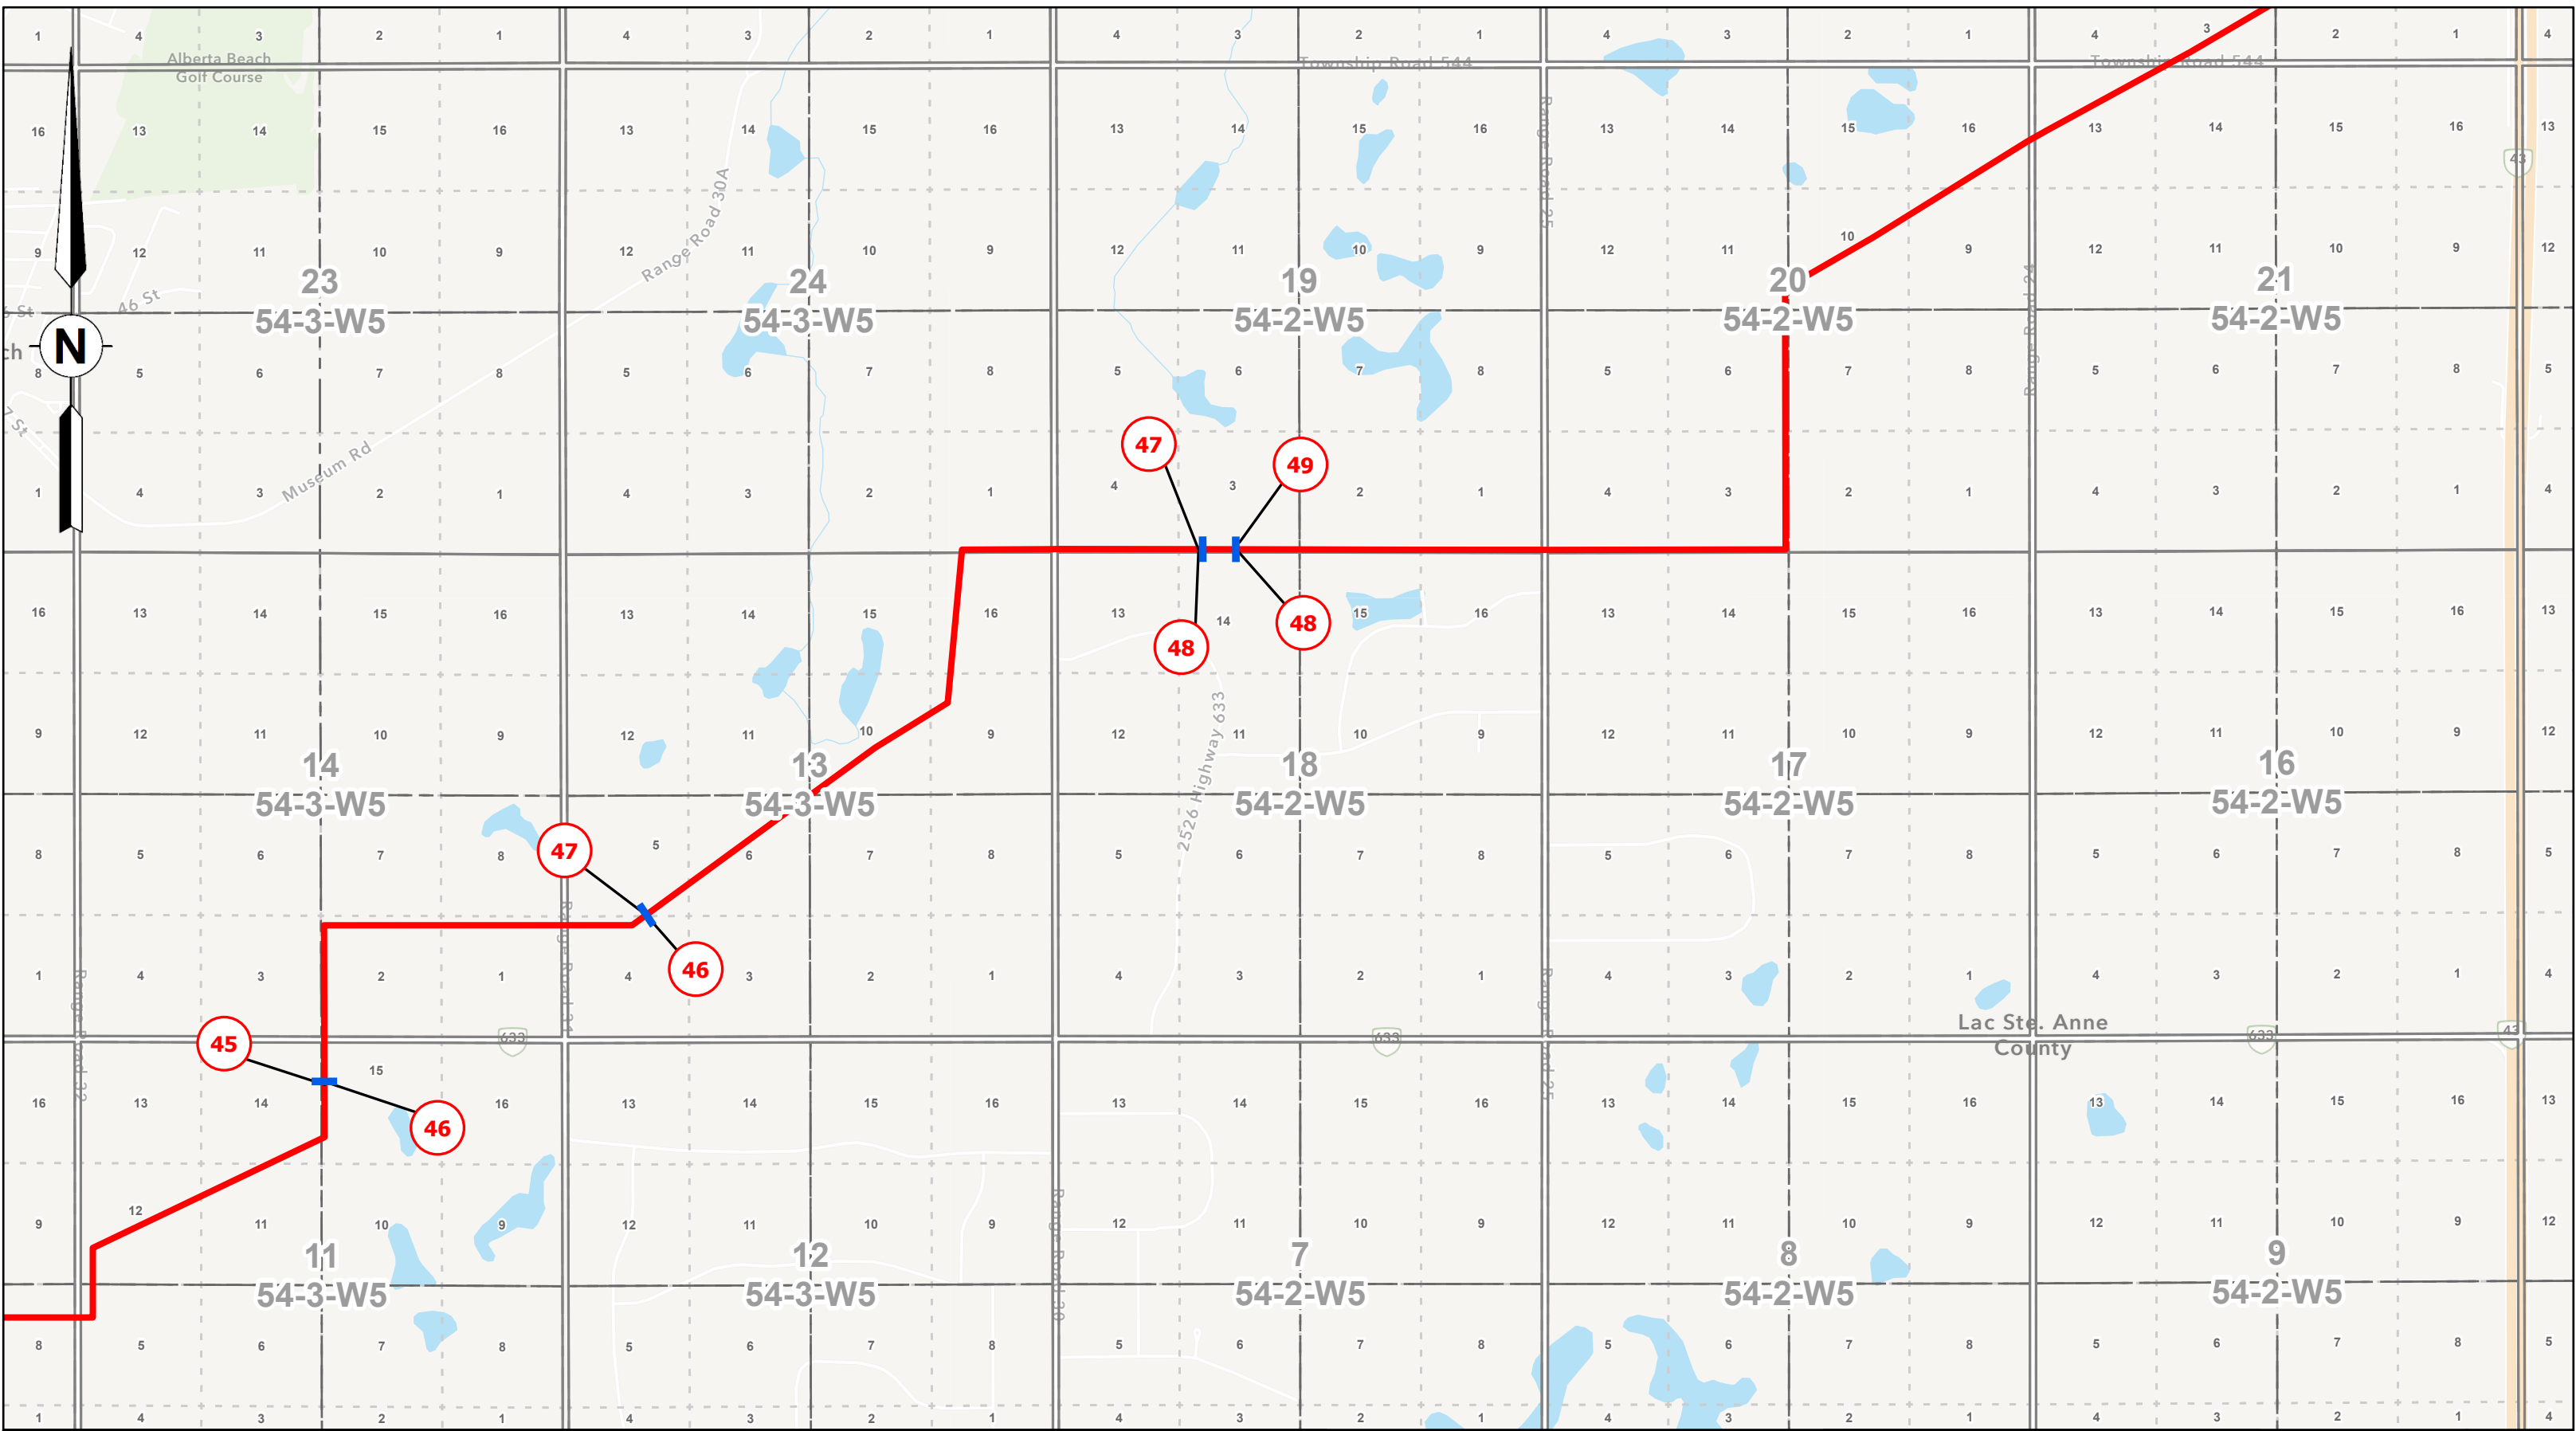




McElhanney Ltd.
100, 402 - 11th Avenue SE
Calgary, Alberta T2G 0Y4
T(403)245-4711



0	10/14/2025	Plan Issued
Rev	Date	Description

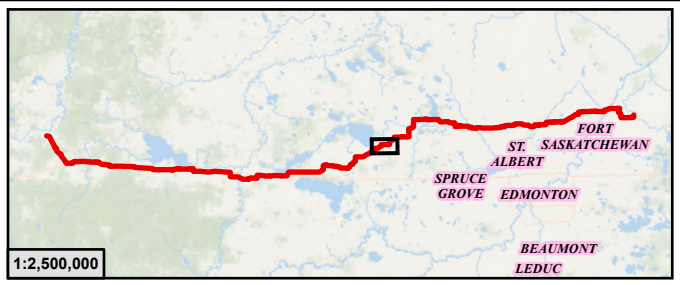

Legend

- PIPELINE PERMITTED, OPERATING OR DE-LICENSED
- ABANDONED OR REMOVED PIPELINE
- PIPELINE SPLIT LOCATION
- LINE NUMBER FOR PERMITTED, OPERATING OR DE-LICENCED PIPELINE
- LINE NUMBER FOR ABANDONED OR REMOVED PIPELINE
- INSTALLATION NUMBER (COMPRESSOR STATION)

**ATCO Yellowhead Pipeline
AUC Facility Application**

**Installation Location and Site Plans within
NE-27-54-14-W5M To SE-15-55-21-W4M**

SCALE: 1:20,000

DC Num: N/A

02505001,000Metres

JOB: 301100635

PLAN ID: AUC Facilities Application

License No.:

REV
0

GIS

TH


CHK

RD

DATE

10/14/2025

Page 16 of 27

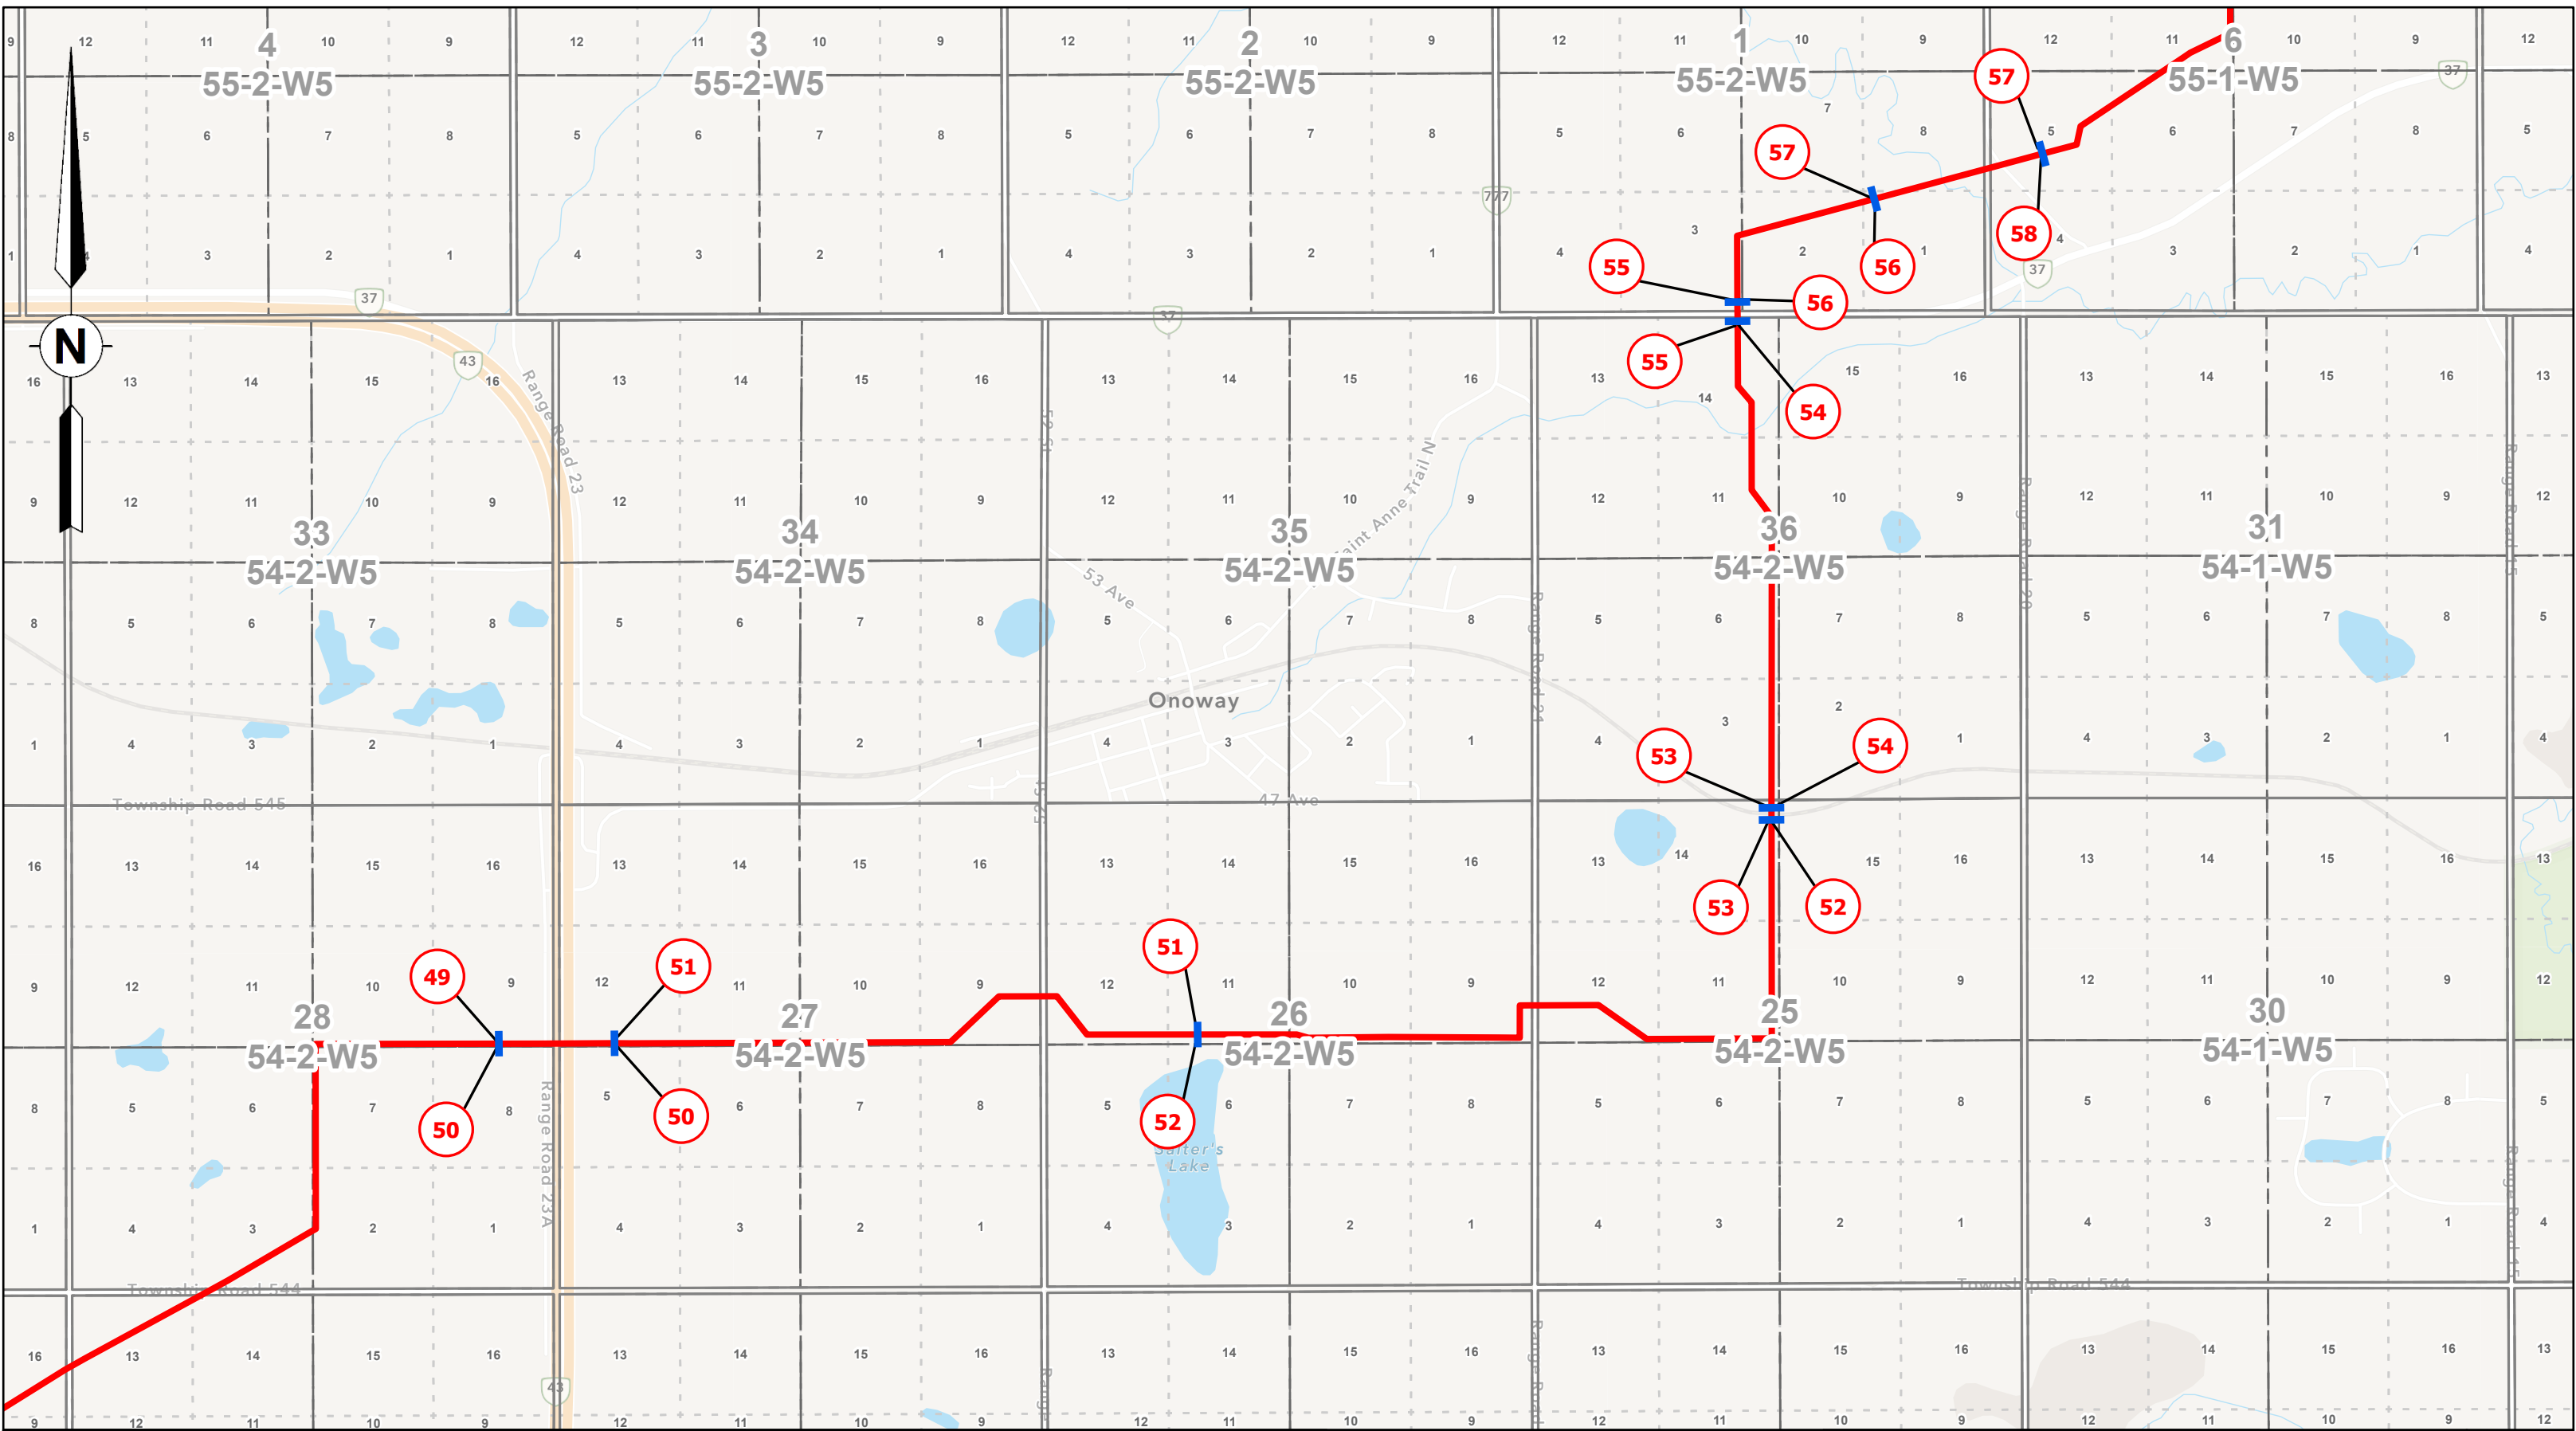




McElhanney Ltd.
100, 402 - 11th Avenue SE
Calgary, Alberta T2G 0Y4
T(403)245-4711

0	10/14/2025	Plan Issued
Rev	Date	Description



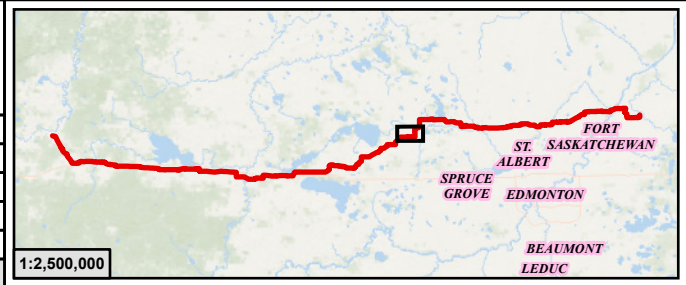

Legend

 
- PIPELINE PERMITTED, OPERATING OR DE-LICENSED
- ABANDONED OR REMOVED PIPELINE
- PIPELINE SPLIT LOCATION
- LINE NUMBER FOR PERMITTED, OPERATING OR DE-LICENCED PIPELINE
- LINE NUMBER FOR ABANDONED OR REMOVED PIPELINE
- INSTALLATION NUMBER (COMPRESSOR STATION)

**ATCO Yellowhead Pipeline
AUC Facility Application**

**Installation Location and Site Plans within
NE-27-54-14-W5M To SE-15-55-21-W4M**

SCALE: 1:20,000

DC Num: N/A



JOB: 301100635

PLAN ID: AUC Facilities Application

License No.:

REV
0

GIS

TH


CHK

RD

DATE

10/14/2025

Page 17 of 27

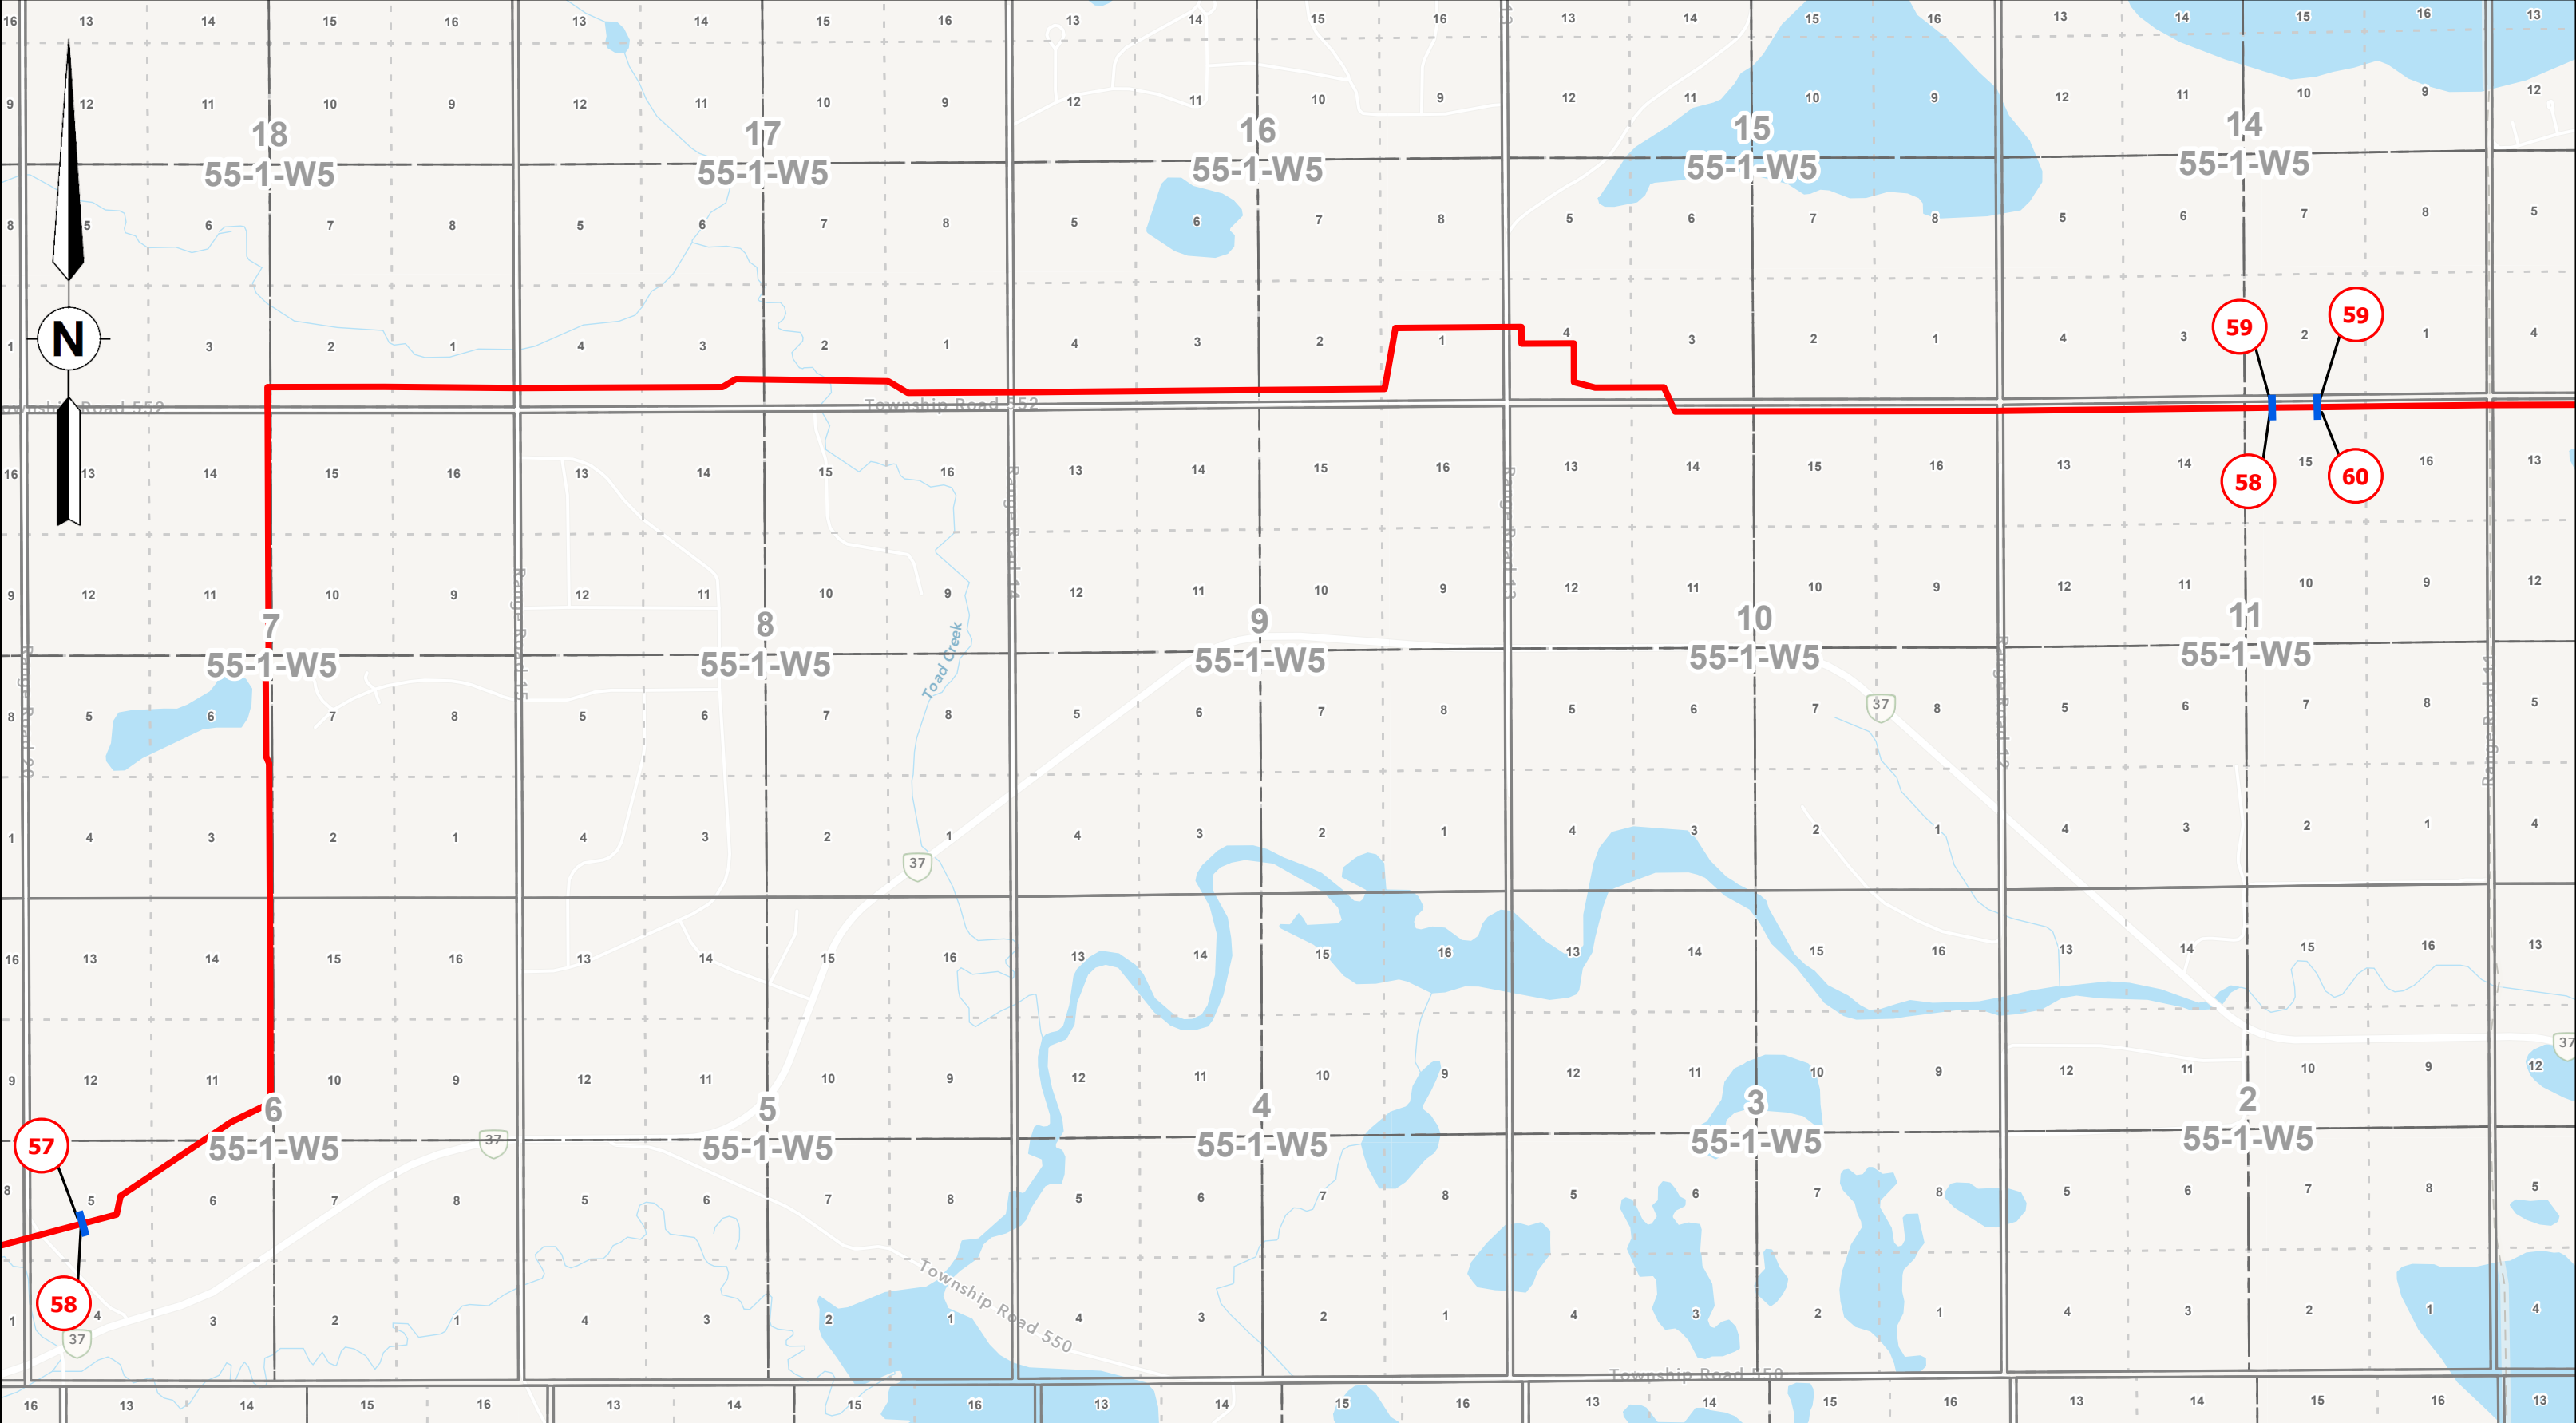




McElhanney Ltd.
100, 402 - 11th Avenue SE
Calgary, Alberta T2G 0Y4
T(403)245-4711



0	10/14/2025	Plan Issued
Rev	Date	Description

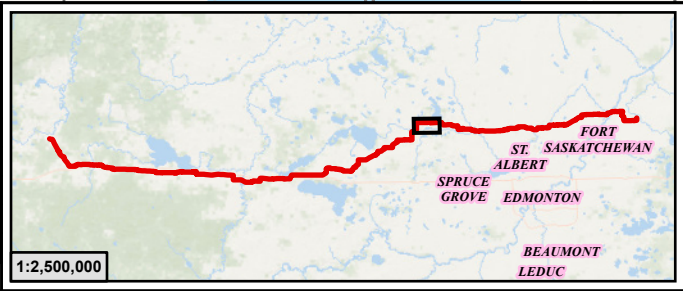

Legend

- PIPELINE PERMITTED, OPERATING OR DE-LICENSED
- ABANDONED OR REMOVED PIPELINE
- PIPELINE SPLIT LOCATION
- LINE NUMBER FOR PERMITTED, OPERATING OR DE-LICENCED PIPELINE
- LINE NUMBER FOR ABANDONED OR REMOVED PIPELINE
- INSTALLATION NUMBER (COMPRESSOR STATION)

**ATCO Yellowhead Pipeline
AUC Facility Application**

**Installation Location and Site Plans within
NE-27-54-14-W5M To SE-15-55-21-W4M**

SCALE: 1:20,000

DC Num: N/A

0 250 500 1,000 Metres

JOB: 301100635

PLAN ID: AUC Facilities Application

License No.:


REV
0

GIS TH



CHK RD

DATE 10/14/2025

Page 18 of 27

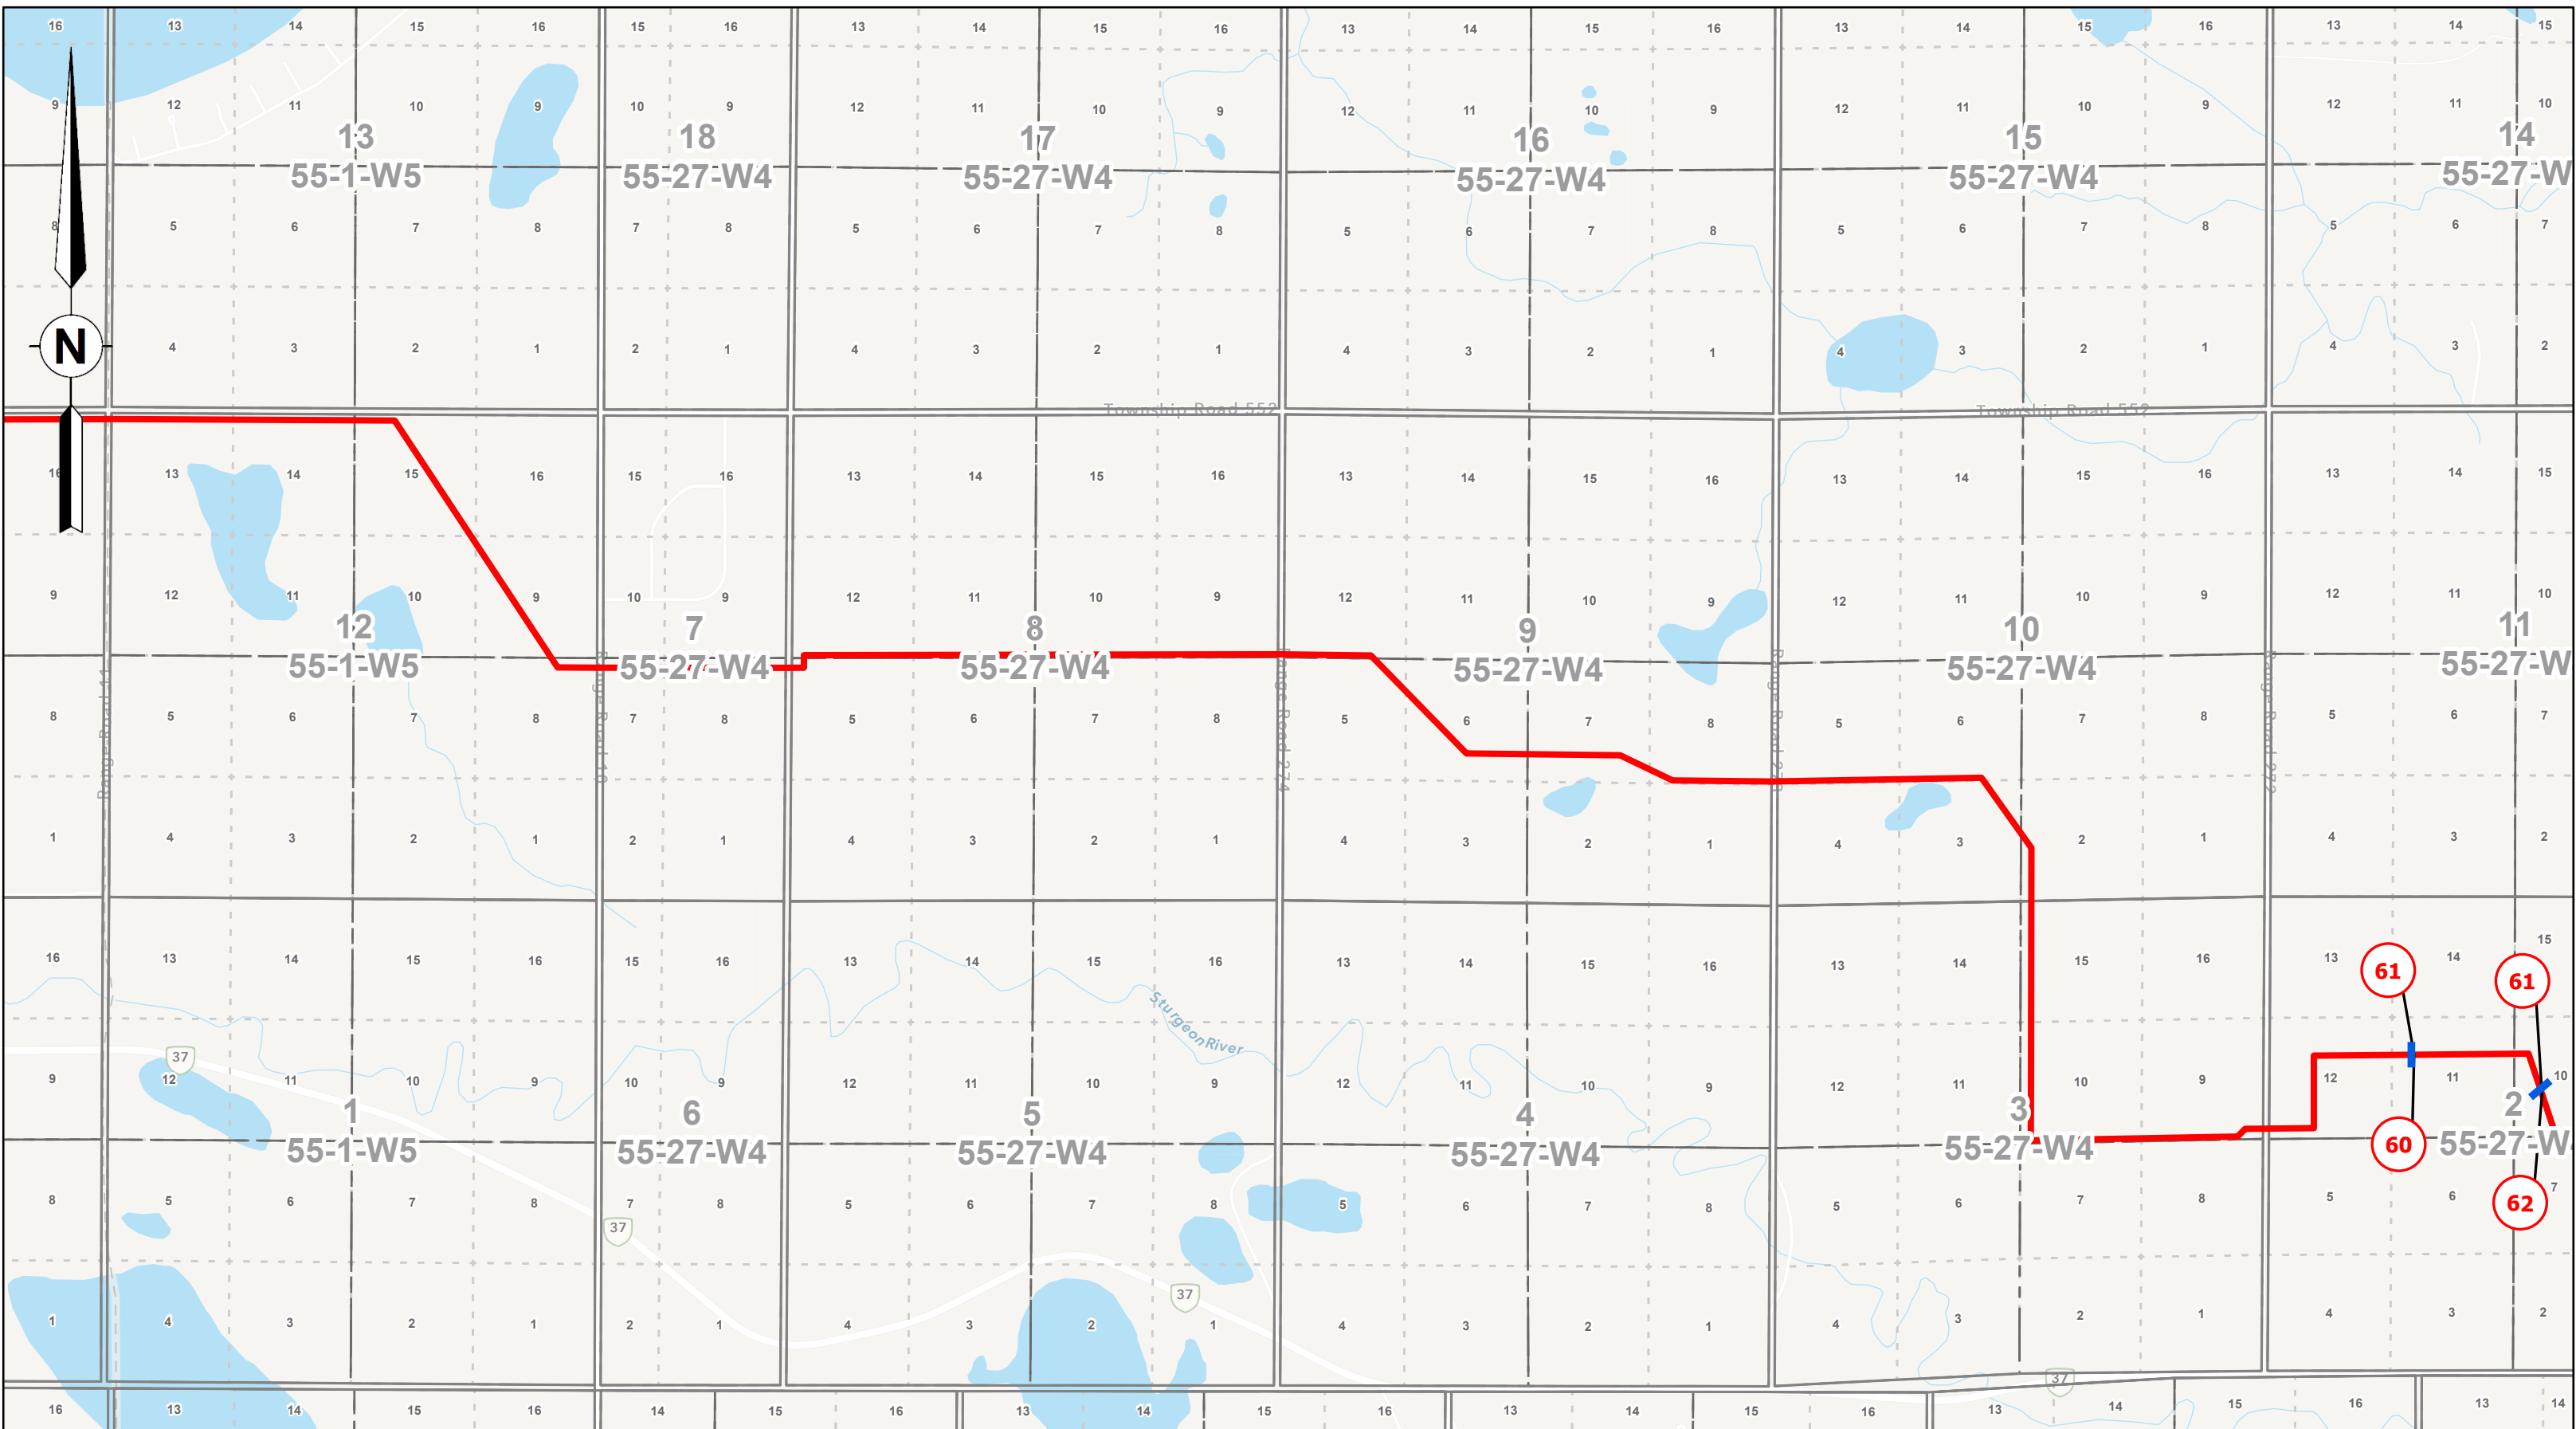

 McElhanney Ltd. 100, 402 - 11th Avenue SE Calgary, Alberta T2G 0Y4 T(403)245-4711						 1:2,500,000			Legend - PIPELINE PERMITTED, OPERATING OR DE-LICENSED - ABANDONED OR REMOVED PIPELINE - PIPELINE SPLIT LOCATION - LINE NUMBER FOR PERMITTED, OPERATING OR DE-LICENCED PIPELINE - LINE NUMBER FOR ABANDONED OR REMOVED PIPELINE - INSTALLATION NUMBER (COMPRESSOR STATION)			ATCO Yellowhead Pipeline AUC Facility Application Installation Location and Site Plans within NE-27-54-14-W5M To SE-15-55-21-W4M SCALE: 1:20,000 DC Num: N/A			REV 0 GIS: TH CHK: RD DATE: 10/14/2025 Page 19 of 27		
0	10/14/2025	Plan Issued															
Rev	Date	Description															

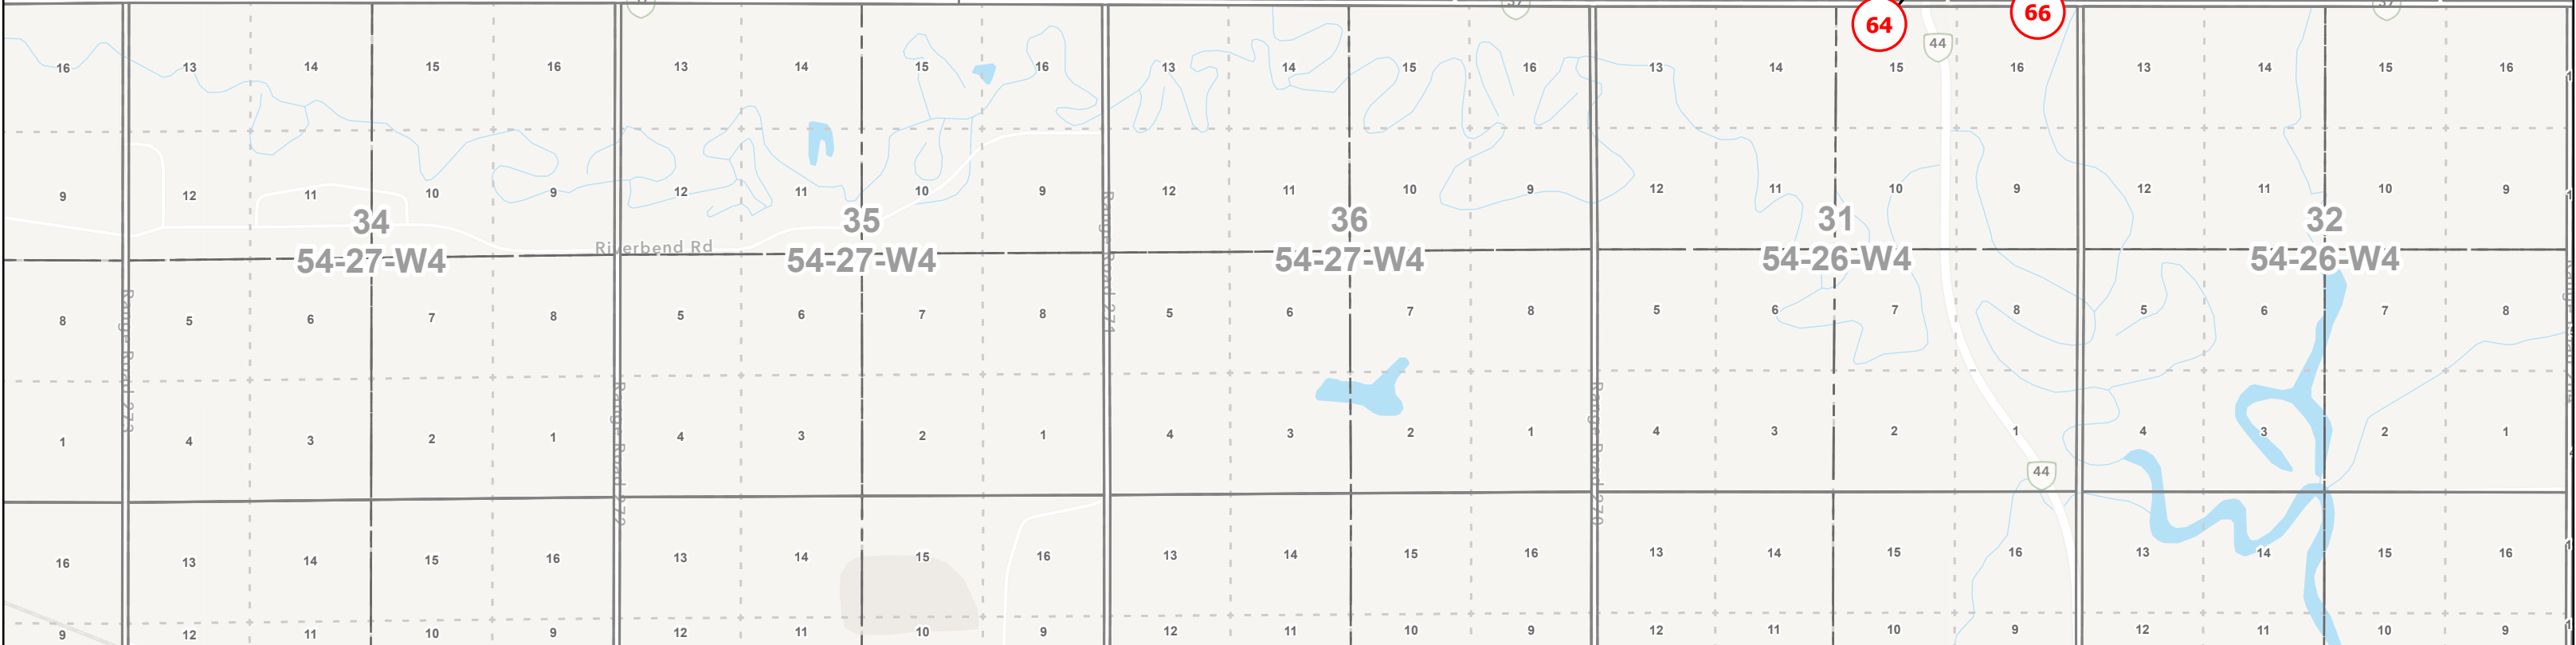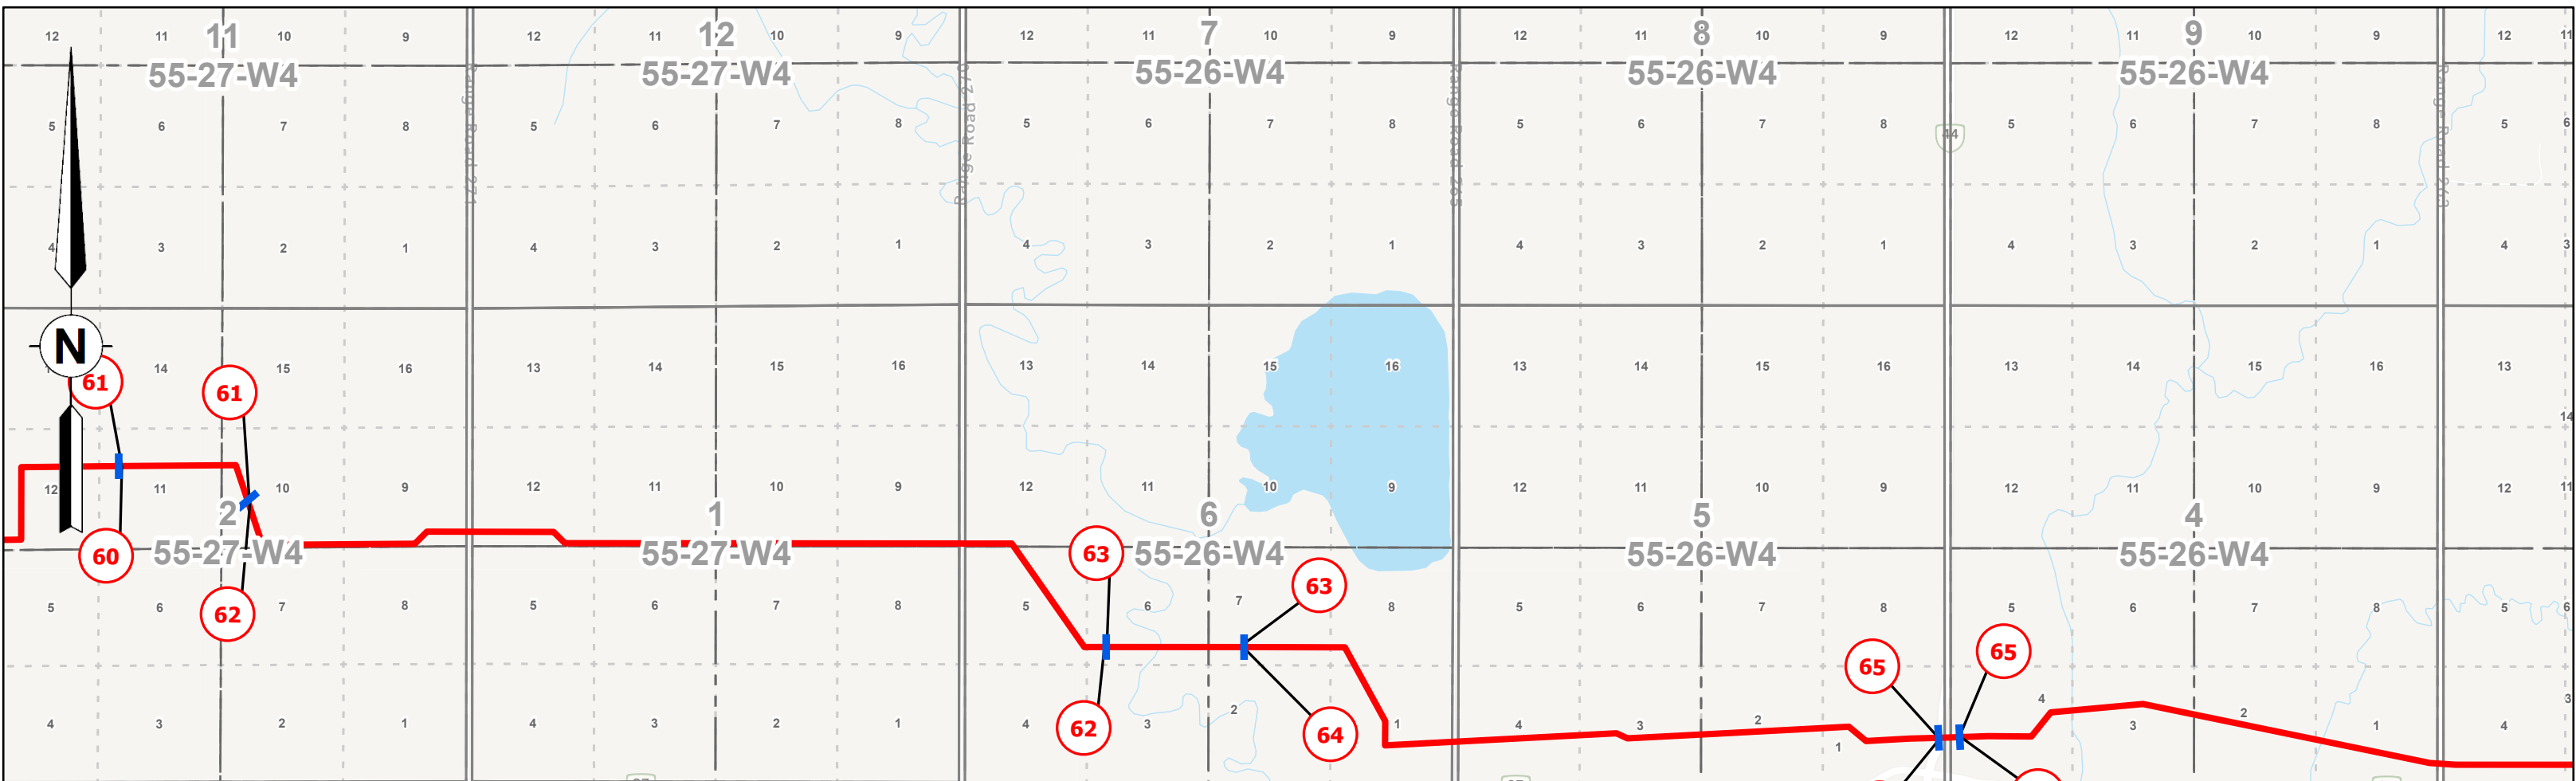




McElhanney Ltd.
100, 402 - 11th Avenue SE
Calgary, Alberta T2G 0Y4
T(403)245-4711



0	10/14/2025	Plan Issued
Rev	Date	Description

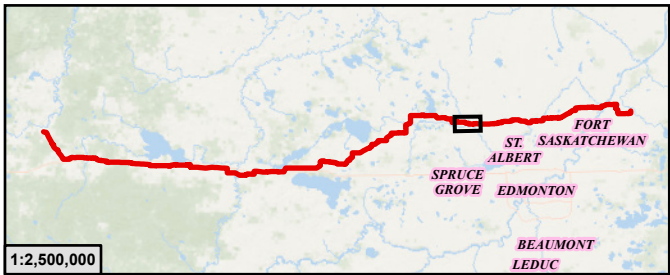

- Legend**
- PIPELINE PERMITTED, OPERATING OR DE-LICENSED
 - ABANDONED OR REMOVED PIPELINE
 - PIPELINE SPLIT LOCATION
 - LINE NUMBER FOR PERMITTED, OPERATING OR DE-LICENCED PIPELINE
 - LINE NUMBER FOR ABANDONED OR REMOVED PIPELINE
 - INSTALLATION NUMBER (COMPRESSOR STATION)

**ATCO Yellowhead Pipeline
AUC Facility Application**

Installation Location and Site Plans within
NE-27-54-14-W5M To SE-15-55-21-W4M

SCALE: 1:20,000

DC Num: N/A

0 250 500 1,000 Metres

JOB: 301100635

PLAN ID: AUC Facilities Application

License No.:

REV
0

GIS

TH


CHK

RD

DATE

10/14/2025

Page 20 of 27

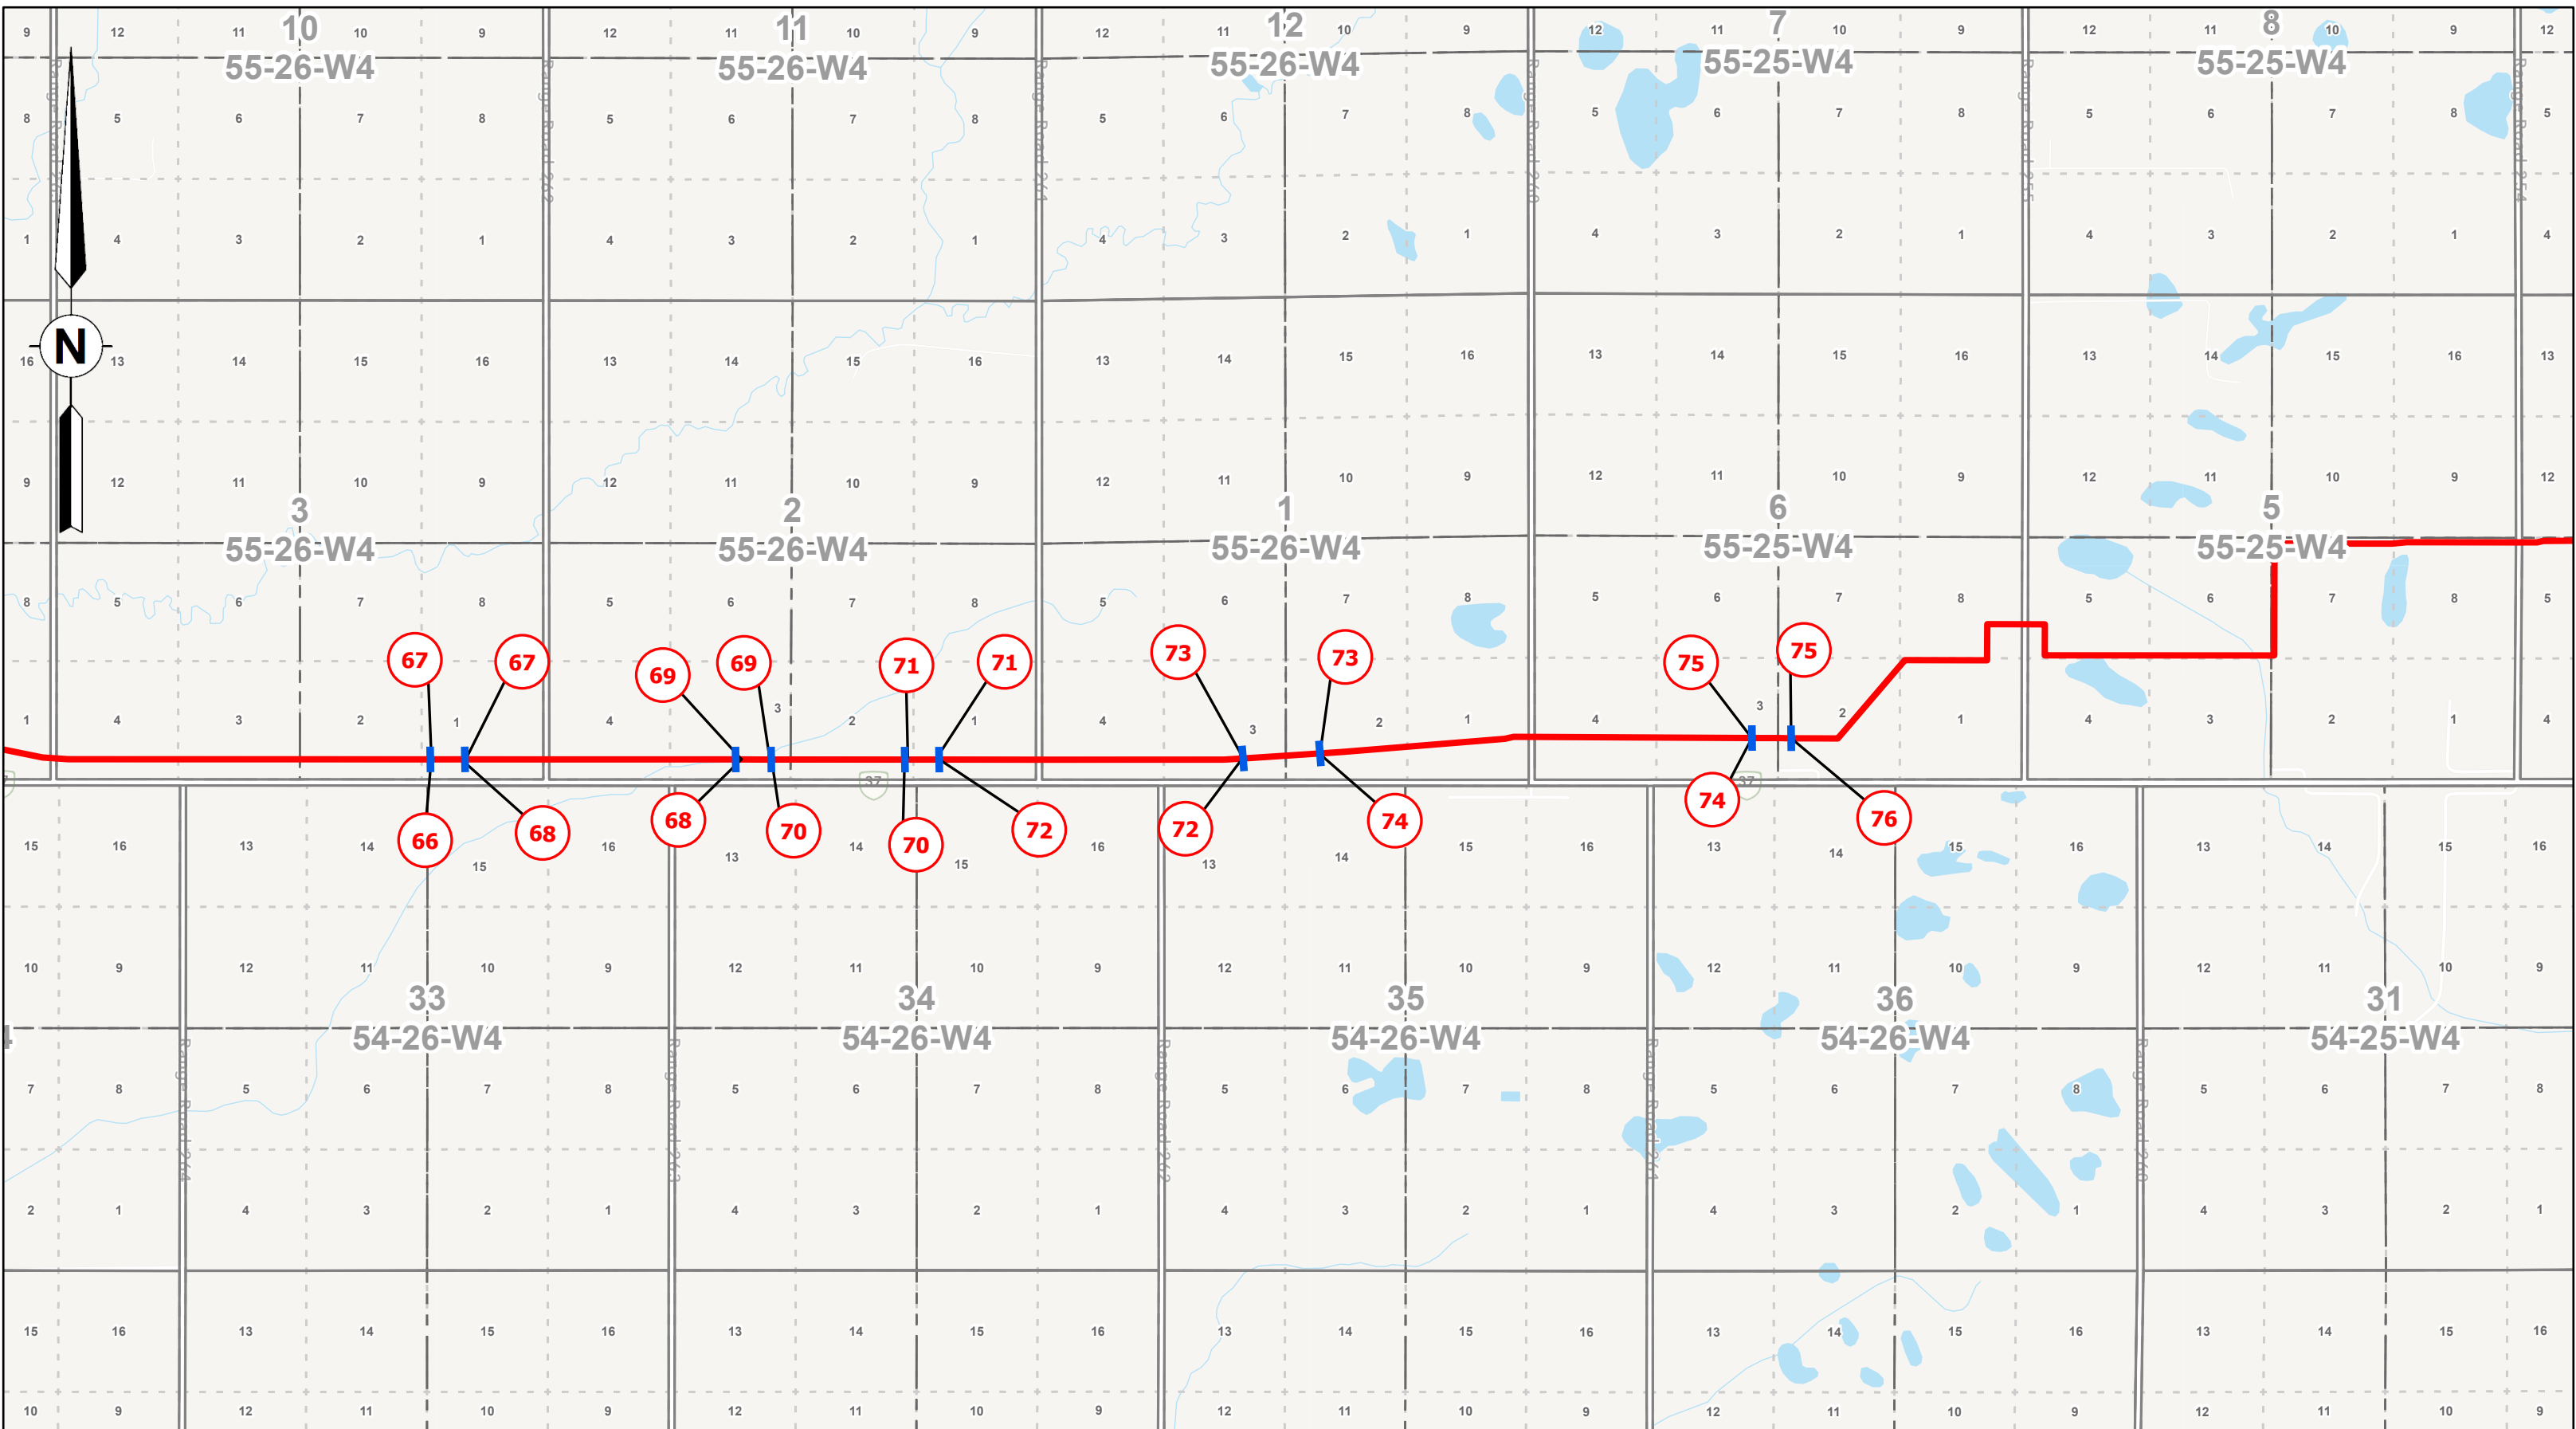



McElhanney Ltd.
100, 402 - 11th Avenue SE
Calgary, Alberta T2G 0Y4
T(403)245-4711





Legend

- PIPELINE PERMITTED, OPERATING OR DE-LICENSED
- ABANDONED OR REMOVED PIPELINE
- PIPELINE SPLIT LOCATION
- LINE NUMBER FOR PERMITTED, OPERATING OR DE-LICENCED PIPELINE
- LINE NUMBER FOR ABANDONED OR REMOVED PIPELINE
- INSTALLATION NUMBER (COMPRESSOR STATION)

**ATCO Yellowhead Pipeline
AUC Facility Application**

**Installation Location and Site Plans within
NE-27-54-14-W5M To SE-15-55-21-W4M**

SCALE: 1:20,000

DC Num: N/A

0 250 500 1,000 Metres

JOB: 301100635

PLAN ID: AUC Facilities Application

License No.:

REV
0

GIS

TH


CHK

RD

DATE

10/14/2025

Page 21 of 27

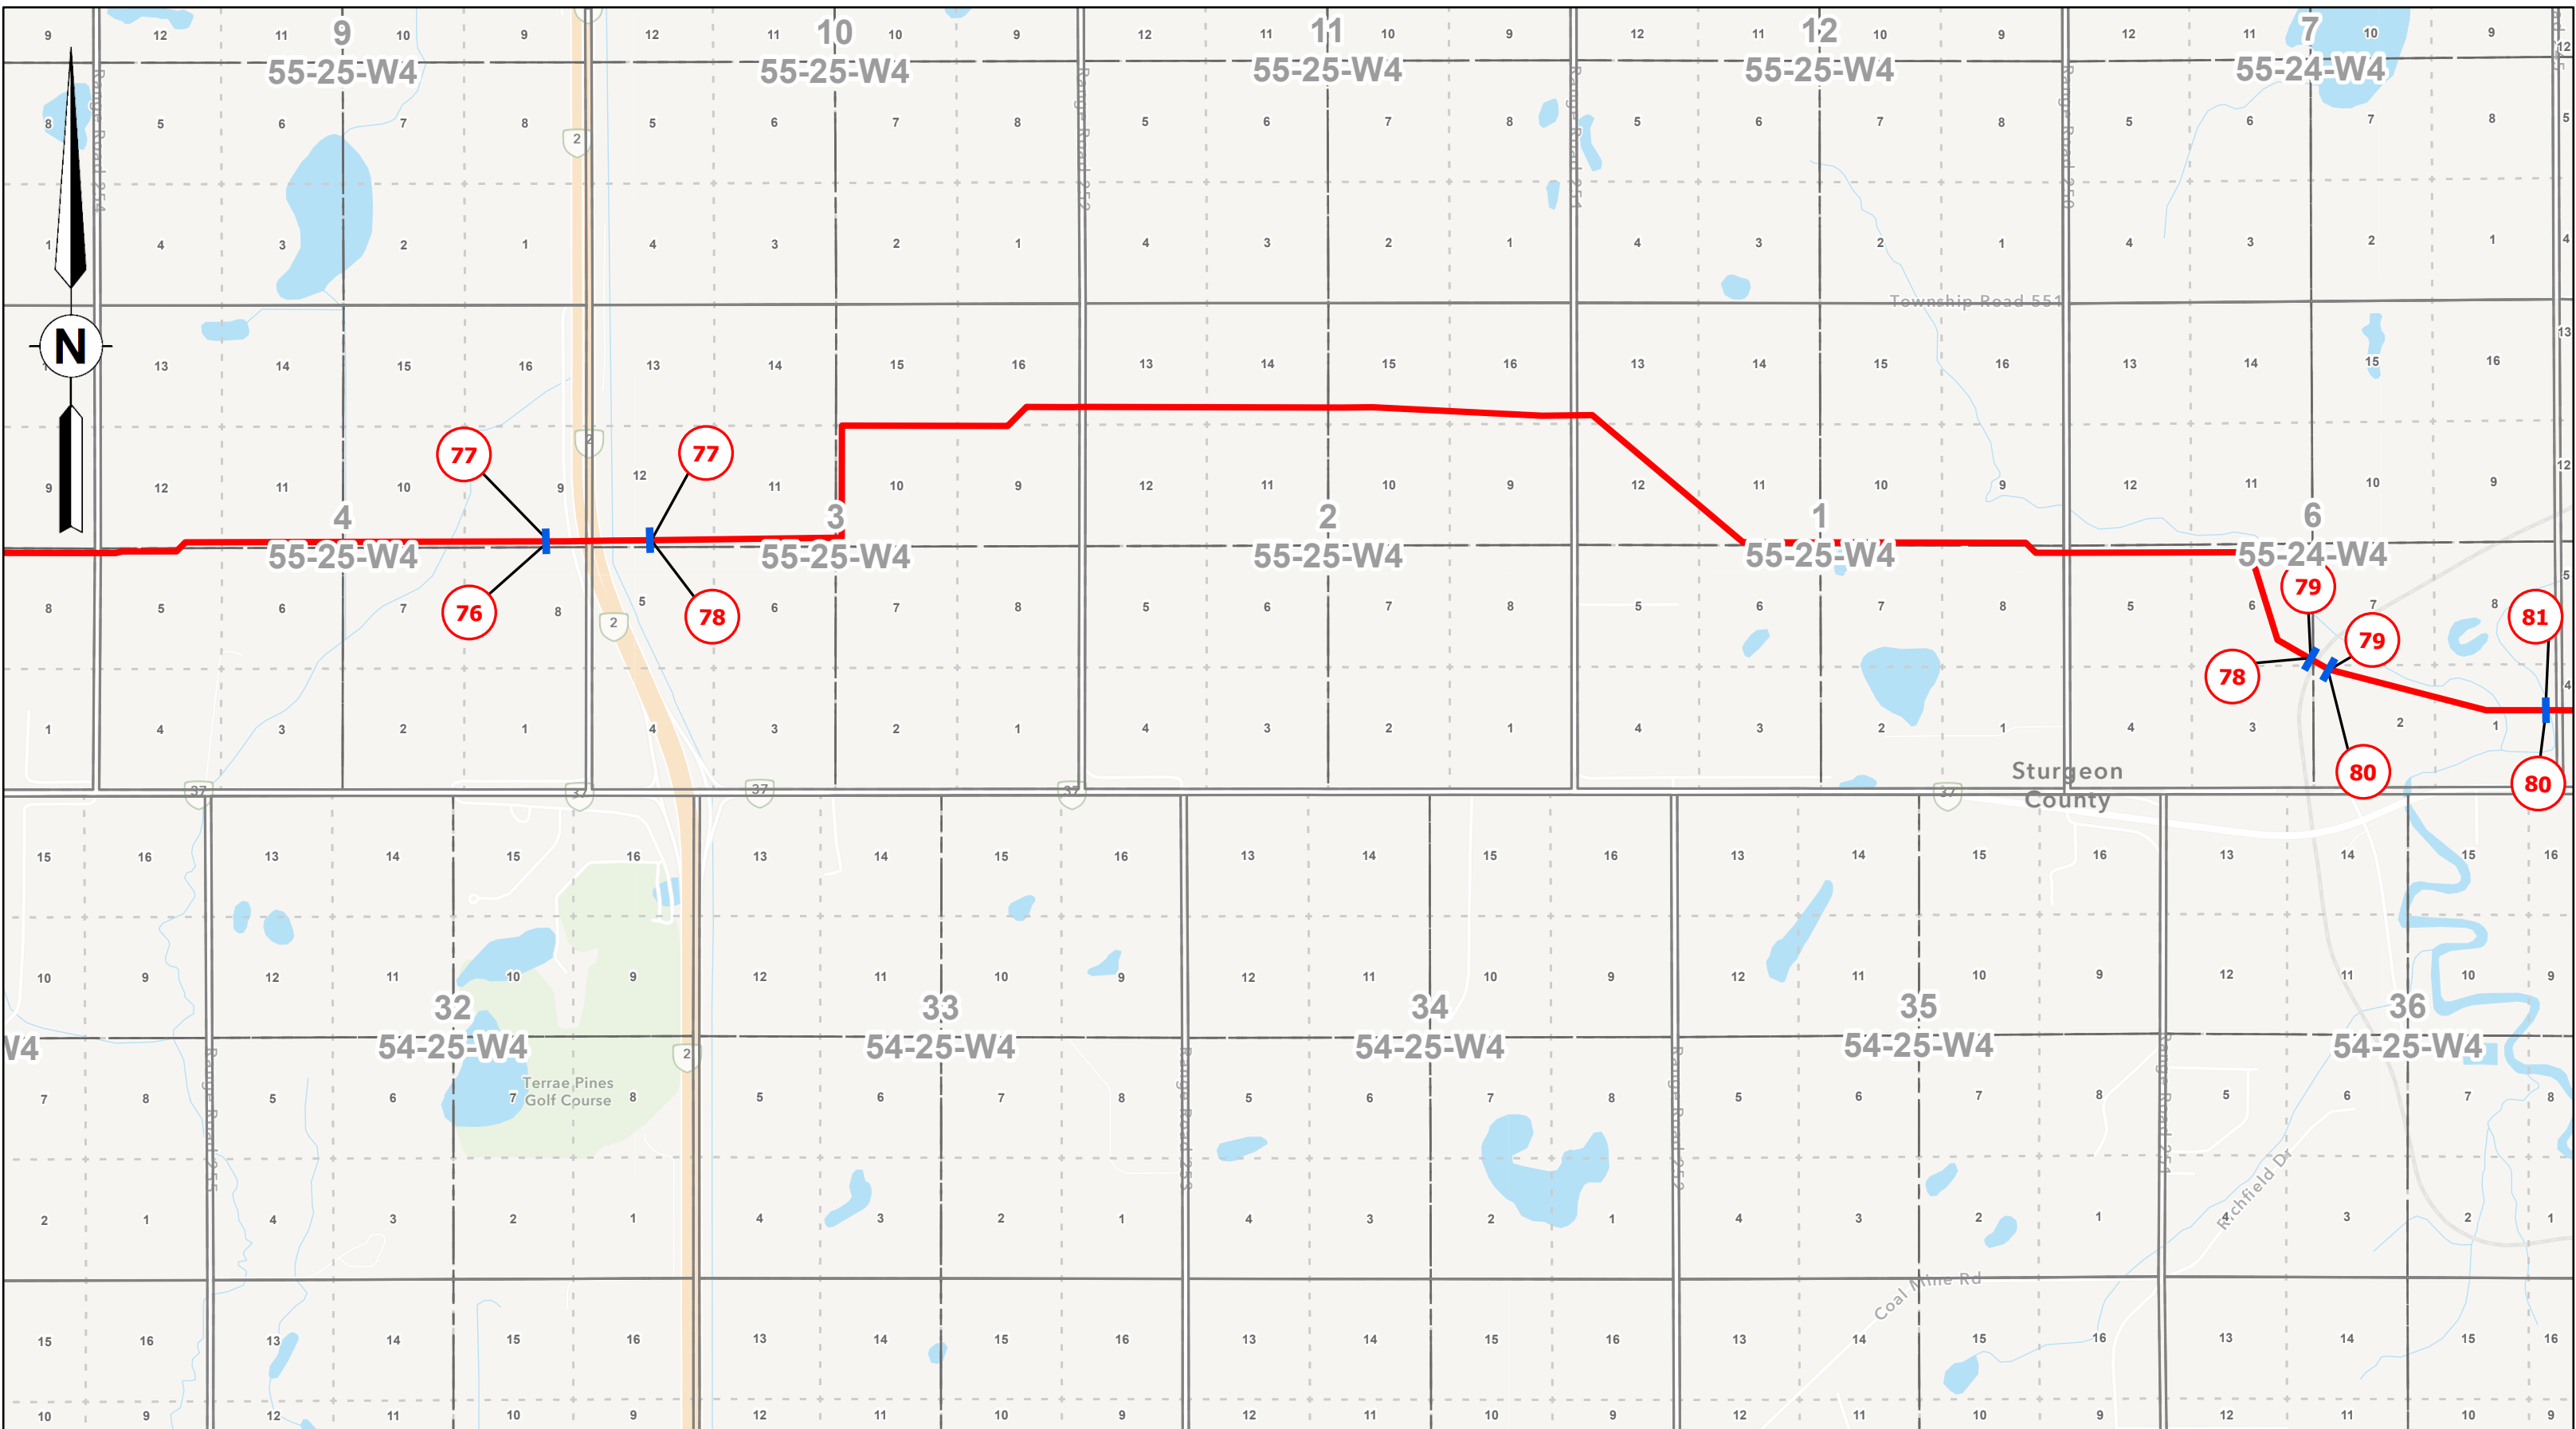




McElhanney Ltd.
100, 402 - 11th Avenue SE
Calgary, Alberta T2G 0Y4
T(403)245-4711



0	10/14/2025	Plan Issued
Rev	Date	Description

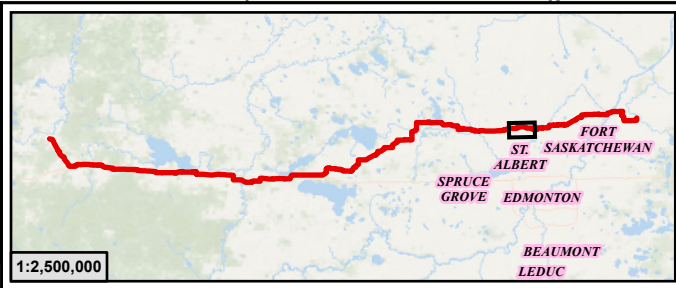

Legend

- PIPELINE PERMITTED, OPERATING OR DE-LICENSED
- ABANDONED OR REMOVED PIPELINE
- PIPELINE SPLIT LOCATION
- LINE NUMBER FOR PERMITTED, OPERATING OR DE-LICENCED PIPELINE
- LINE NUMBER FOR ABANDONED OR REMOVED PIPELINE
- INSTALLATION NUMBER (COMPRESSOR STATION)

**ATCO Yellowhead Pipeline
AUC Facility Application**

**Installation Location and Site Plans within
NE-27-54-14-W5M To SE-15-55-21-W4M**

SCALE: 1:20,000

DC Num: N/A

0 250 500 1,000 Metres

JOB: 301100635

PLAN ID: AUC Facilities Application

License No.:


REV
0

GIS TH

CHK RD

DATE 10/14/2025

Page 22 of 27

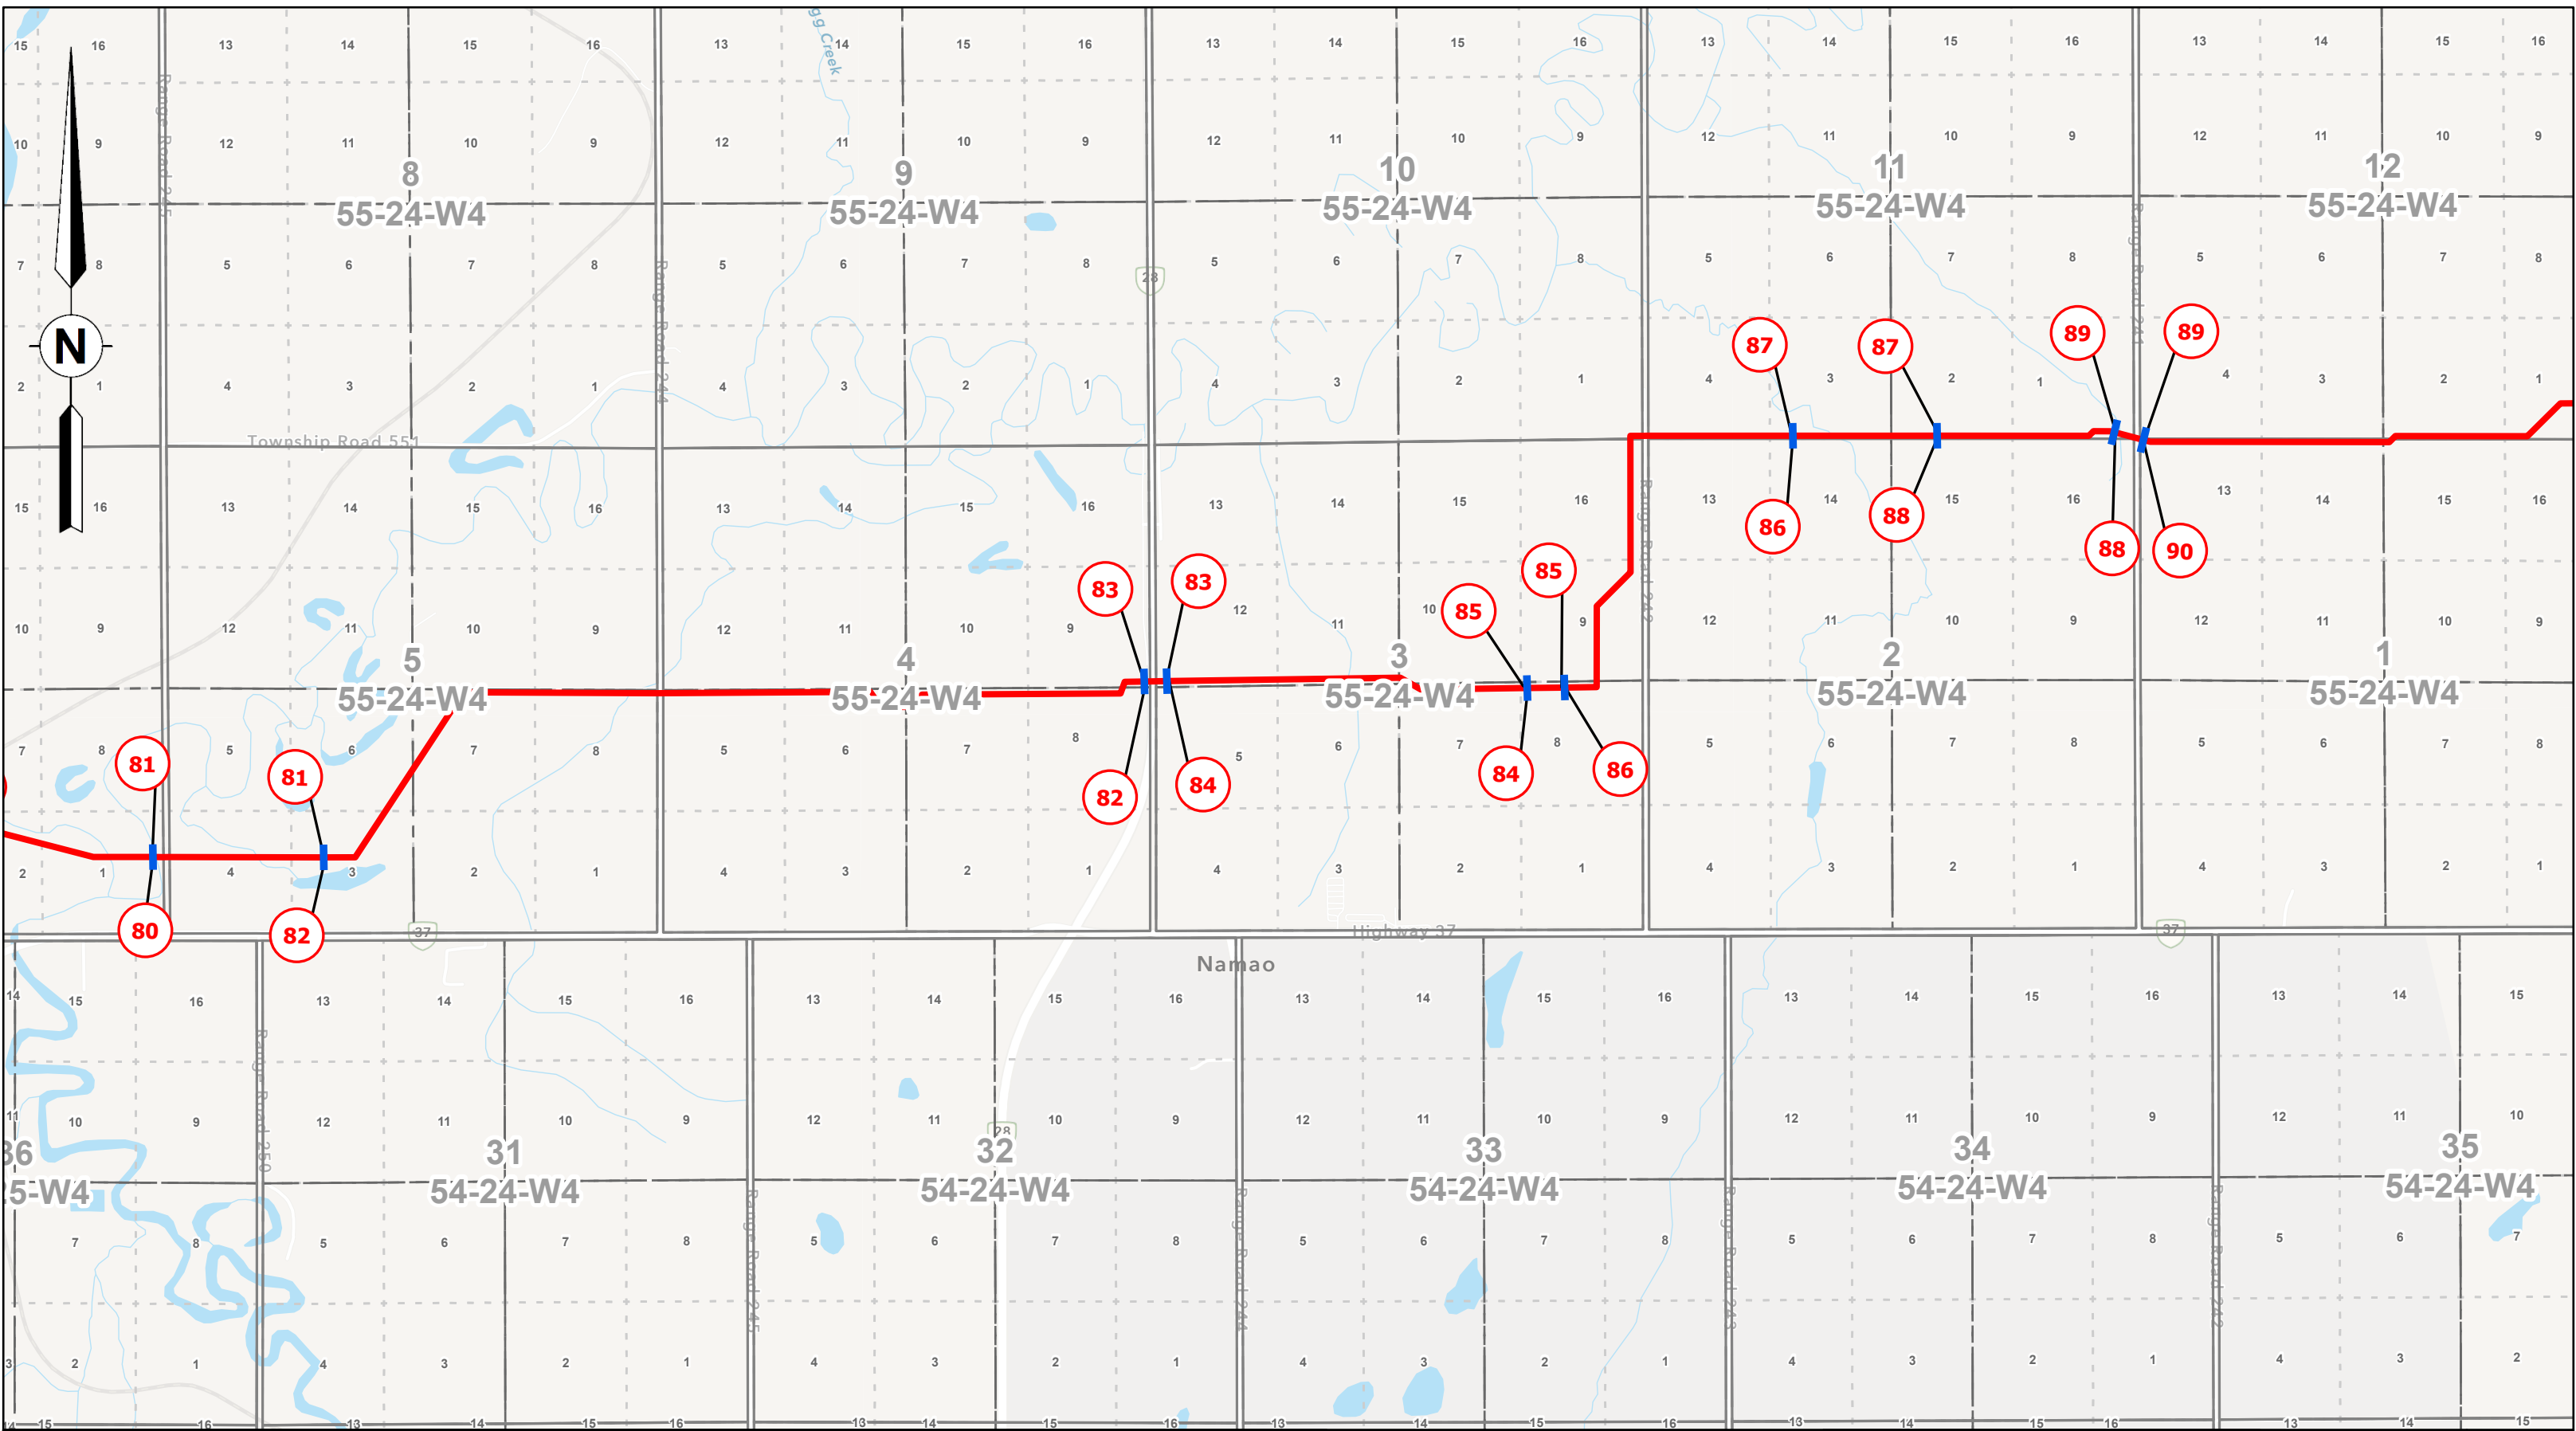




McElhanney Ltd.
100, 402 - 11th Avenue SE
Calgary, Alberta T2G 0Y4
T(403)245-4711



0	10/14/2025	Plan Issued
Rev	Date	Description

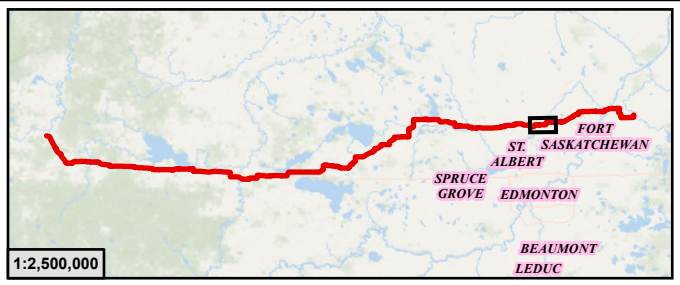

Legend

 
- PIPELINE PERMITTED, OPERATING OR DE-LICENSED
- ABANDONED OR REMOVED PIPELINE
- PIPELINE SPLIT LOCATION
- LINE NUMBER FOR PERMITTED, OPERATING OR DE-LICENCED PIPELINE
- LINE NUMBER FOR ABANDONED OR REMOVED PIPELINE
- INSTALLATION NUMBER (COMPRESSOR STATION)

**ATCO Yellowhead Pipeline
AUC Facility Application**

**Installation Location and Site Plans within
NE-27-54-14-W5M To SE-15-55-21-W4M**

SCALE: 1:20,000

DC Num: N/A



JOB: 301100635

PLAN ID: AUC Facilities Application

License No.:

REV
0

GIS

TH


CHK

RD

DATE

10/14/2025

Page 23 of 27

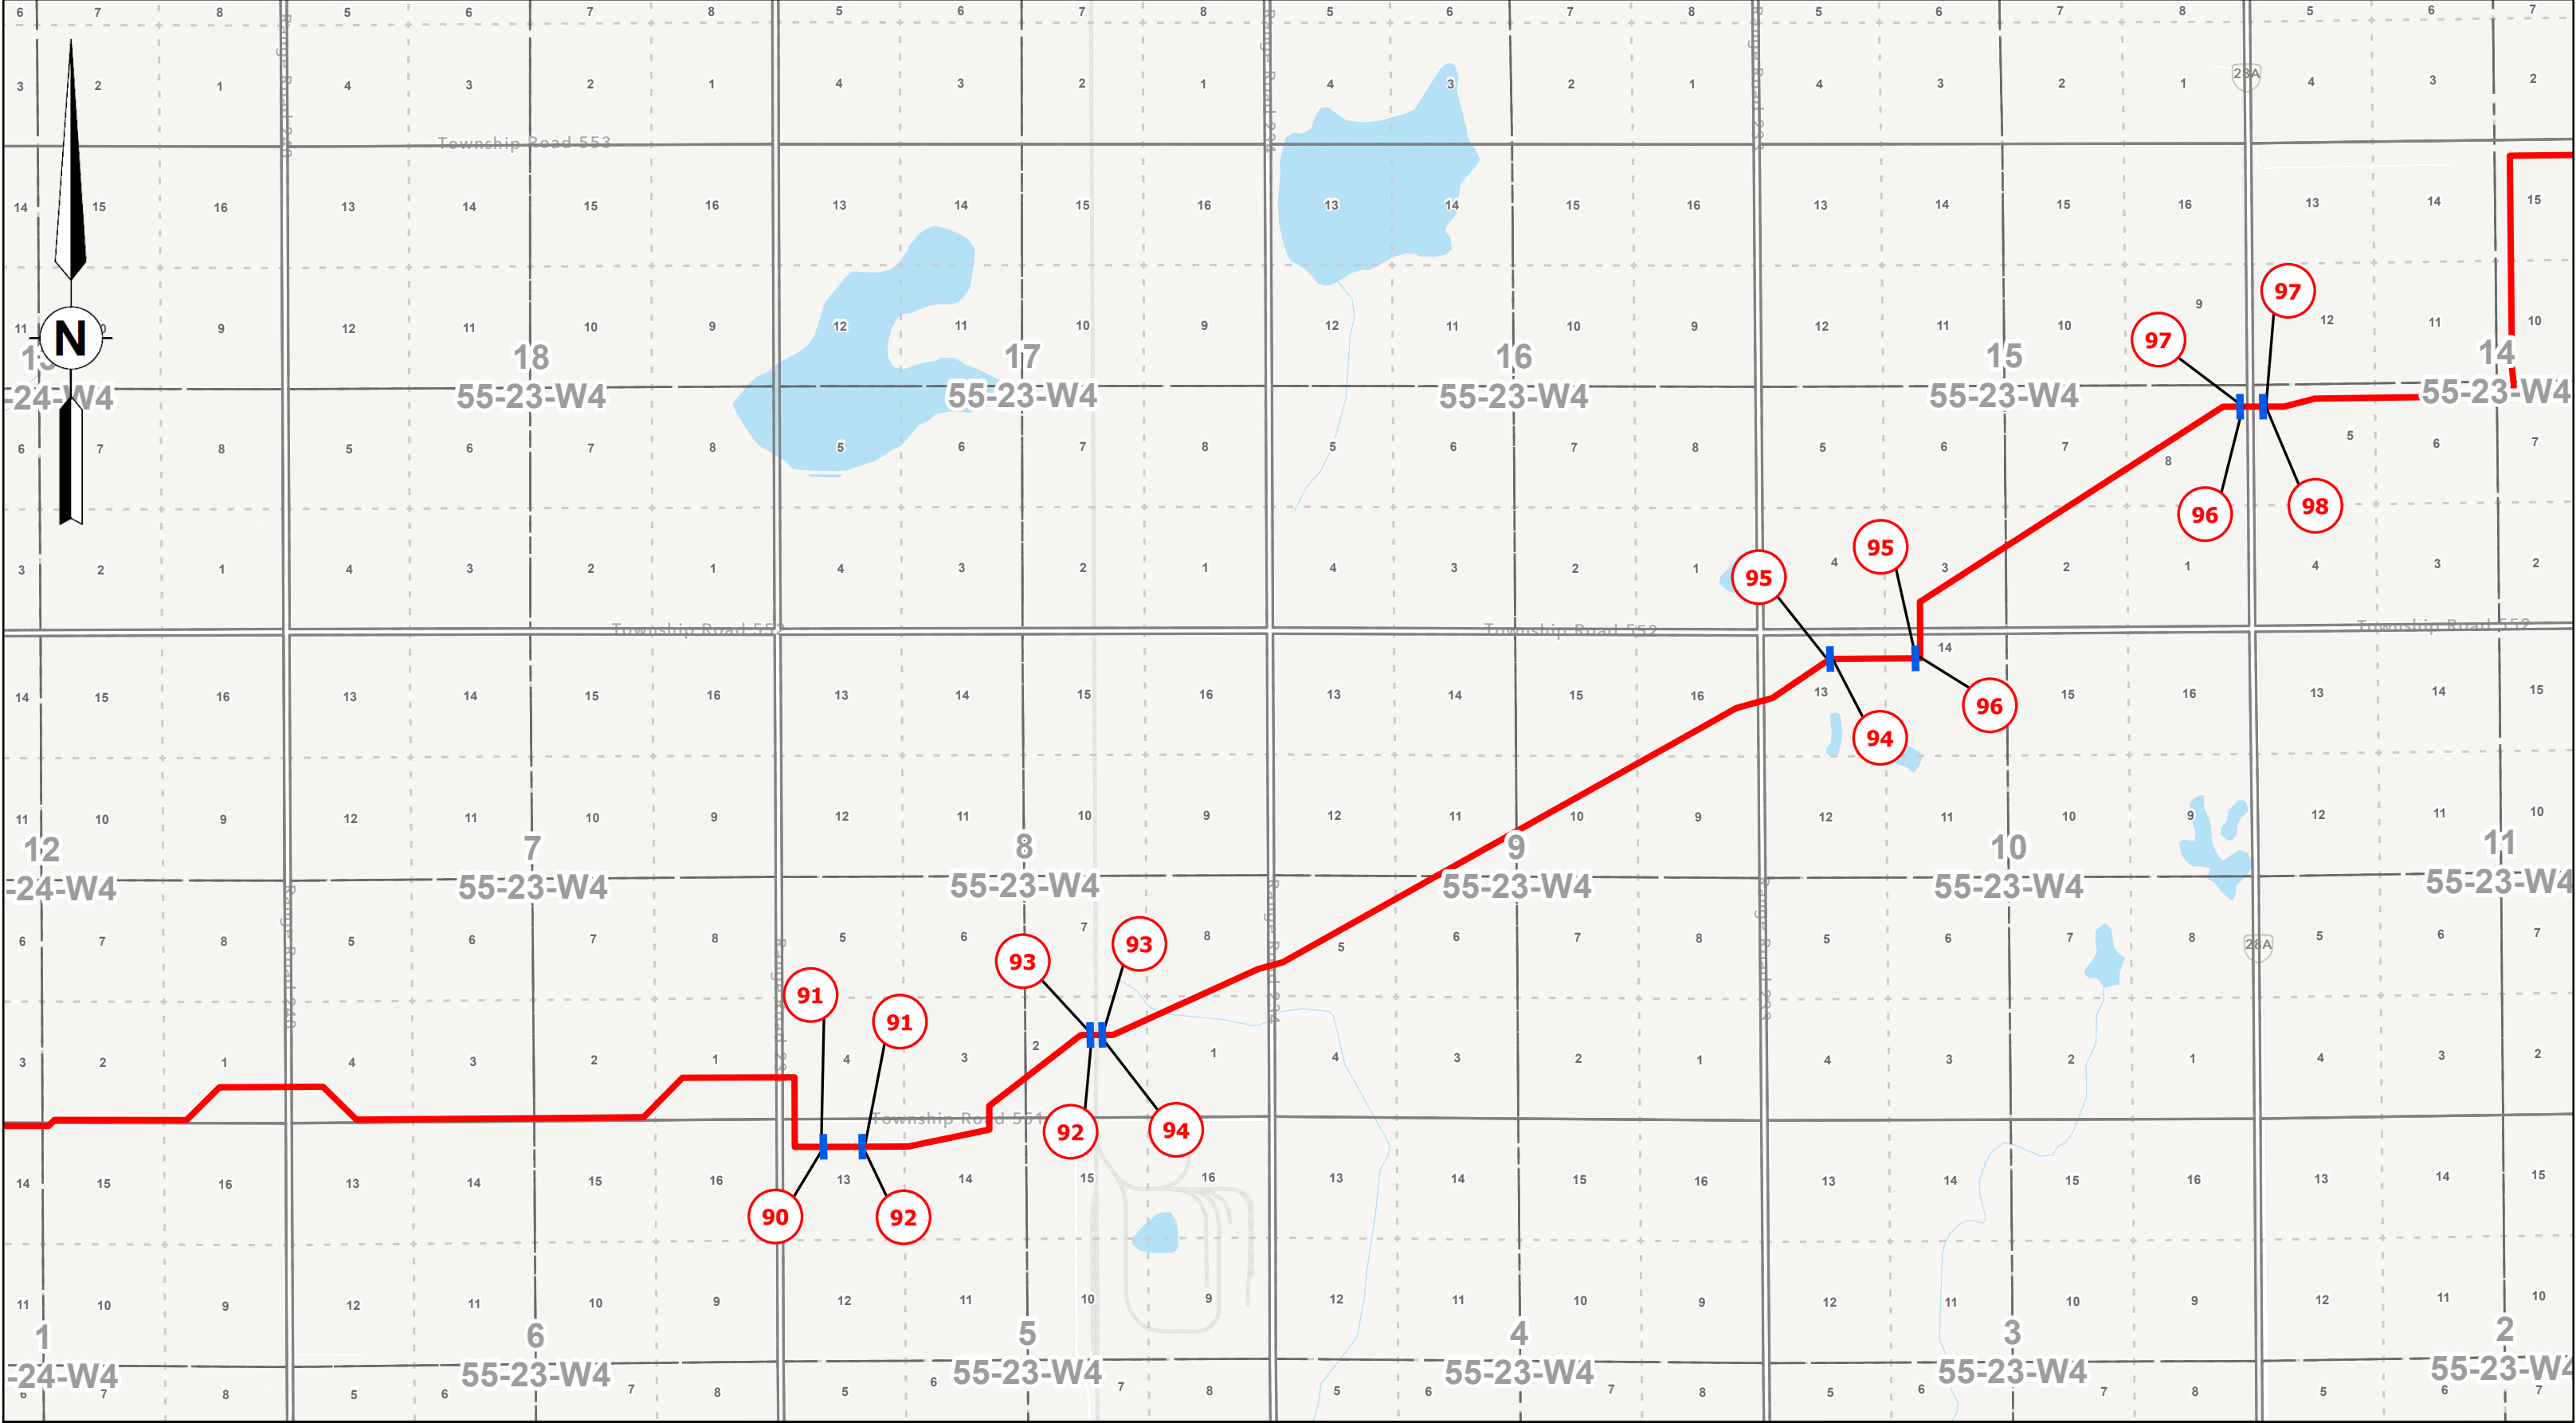



McElhanney Ltd.
100, 402 - 11th Avenue SE
Calgary, Alberta T2G 0Y4
T(403)245-4711





Legend

- PIPELINE PERMITTED, OPERATING OR DE-LICENSED
- ABANDONED OR REMOVED PIPELINE
- PIPELINE SPLIT LOCATION
- LINE NUMBER FOR PERMITTED, OPERATING OR DE-LICENCED PIPELINE
- LINE NUMBER FOR ABANDONED OR REMOVED PIPELINE
- INSTALLATION NUMBER (COMPRESSOR STATION)

**ATCO Yellowhead Pipeline
AUC Facility Application**

**Installation Location and Site Plans within
NE-27-54-14-W5M To SE-15-55-21-W4M**

SCALE: 1:20,000

DC Num: N/A

0 250 500 1,000 Metres

JOB: 301100635

PLAN ID: AUC Facilities Application

License No.:

REV 0

GIS

TH

CHK


RD

DATE

10/14/2025

Page 24 of 27

0	10/14/2025	Plan Issued
Rev	Date	Description

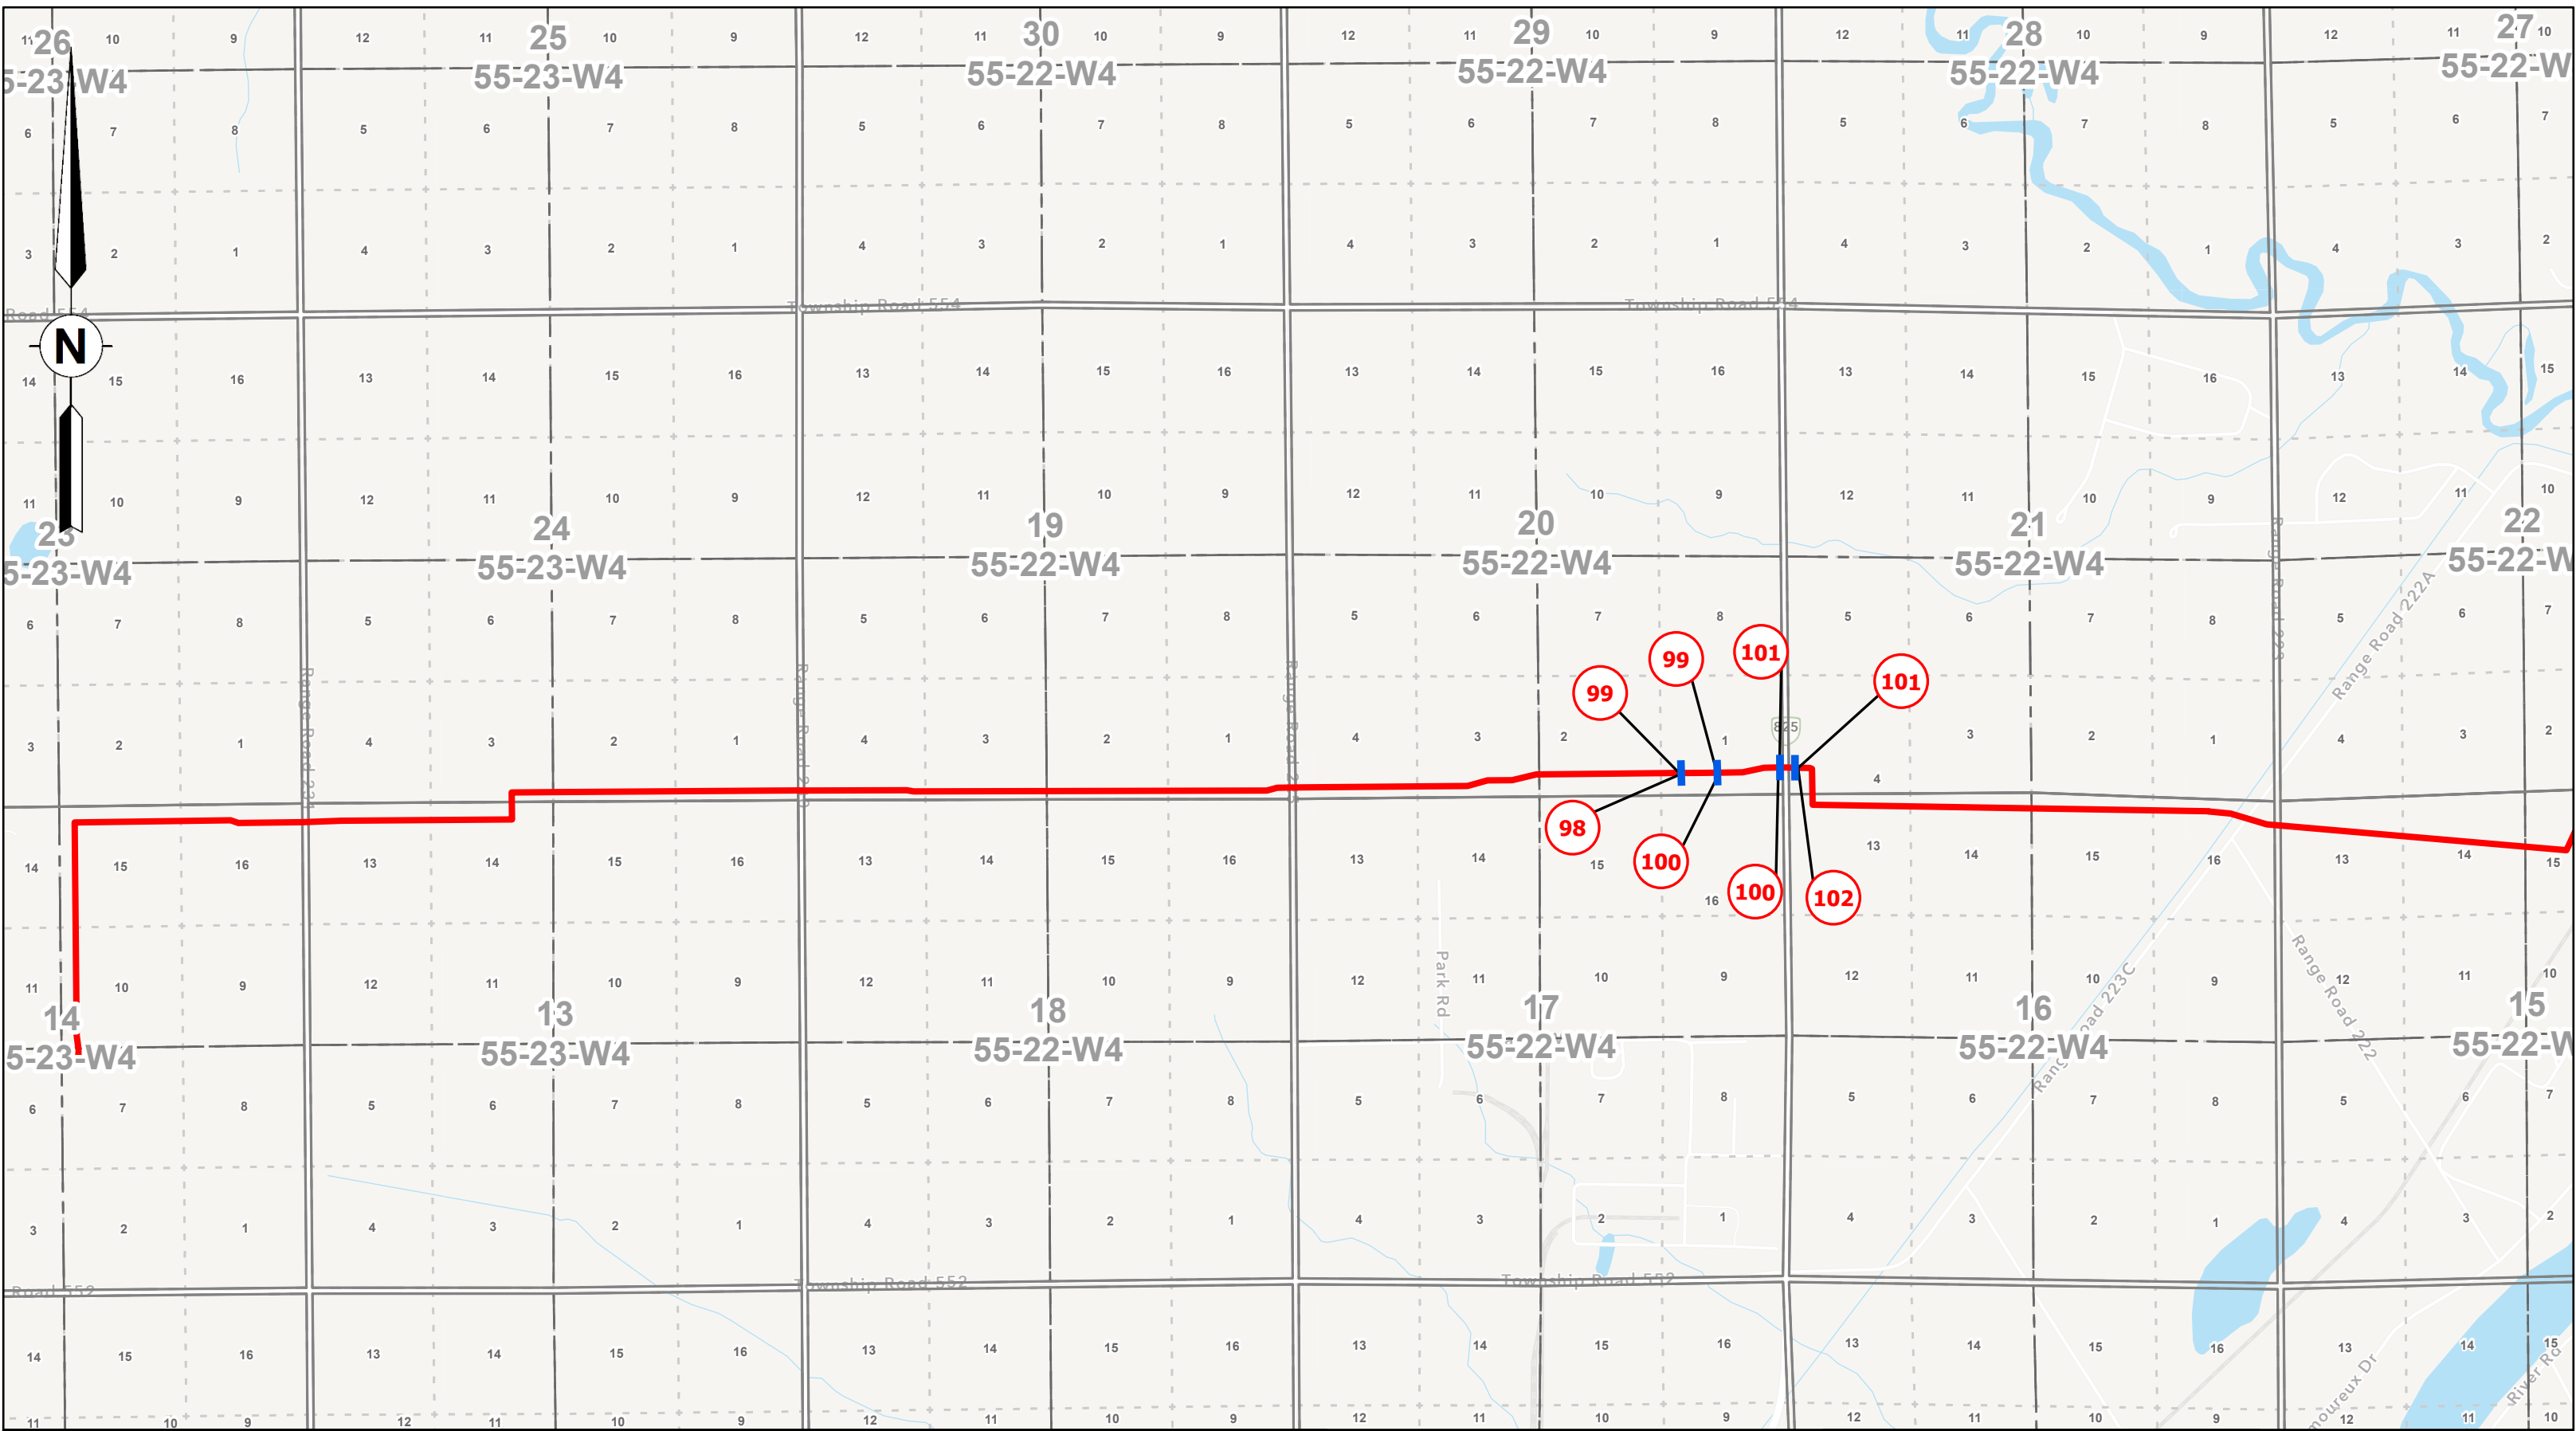




McElhanney Ltd.
100, 402 - 11th Avenue SE
Calgary, Alberta T2G 0Y4
T(403)245-4711



0	10/14/2025	Plan Issued
Rev	Date	Description

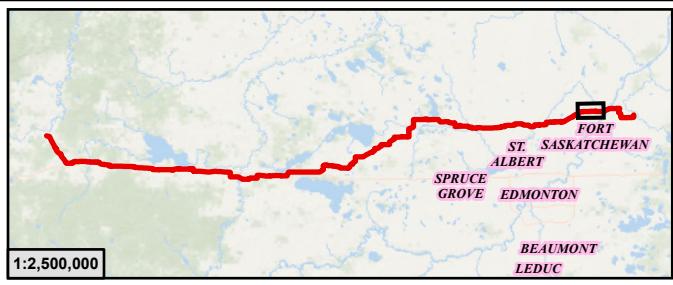

Legend

- PIPELINE PERMITTED, OPERATING OR DE-LICENSED
- ABANDONED OR REMOVED PIPELINE
- PIPELINE SPLIT LOCATION
- LINE NUMBER FOR PERMITTED, OPERATING OR DE-LICENCED PIPELINE
- LINE NUMBER FOR ABANDONED OR REMOVED PIPELINE
- INSTALLATION NUMBER (COMPRESSOR STATION)

**ATCO Yellowhead Pipeline
AUC Facility Application**

**Installation Location and Site Plans within
NE-27-54-14-W5M To SE-15-55-21-W4M**

SCALE: 1:20,000

DC Num: N/A

0 250 500 1,000 Metres

JOB: 301100635

PLAN ID: AUC Facilities Application

License No.:


REV
0

GIS TH

CHK RD

DATE 10/14/2025

Page 25 of 27

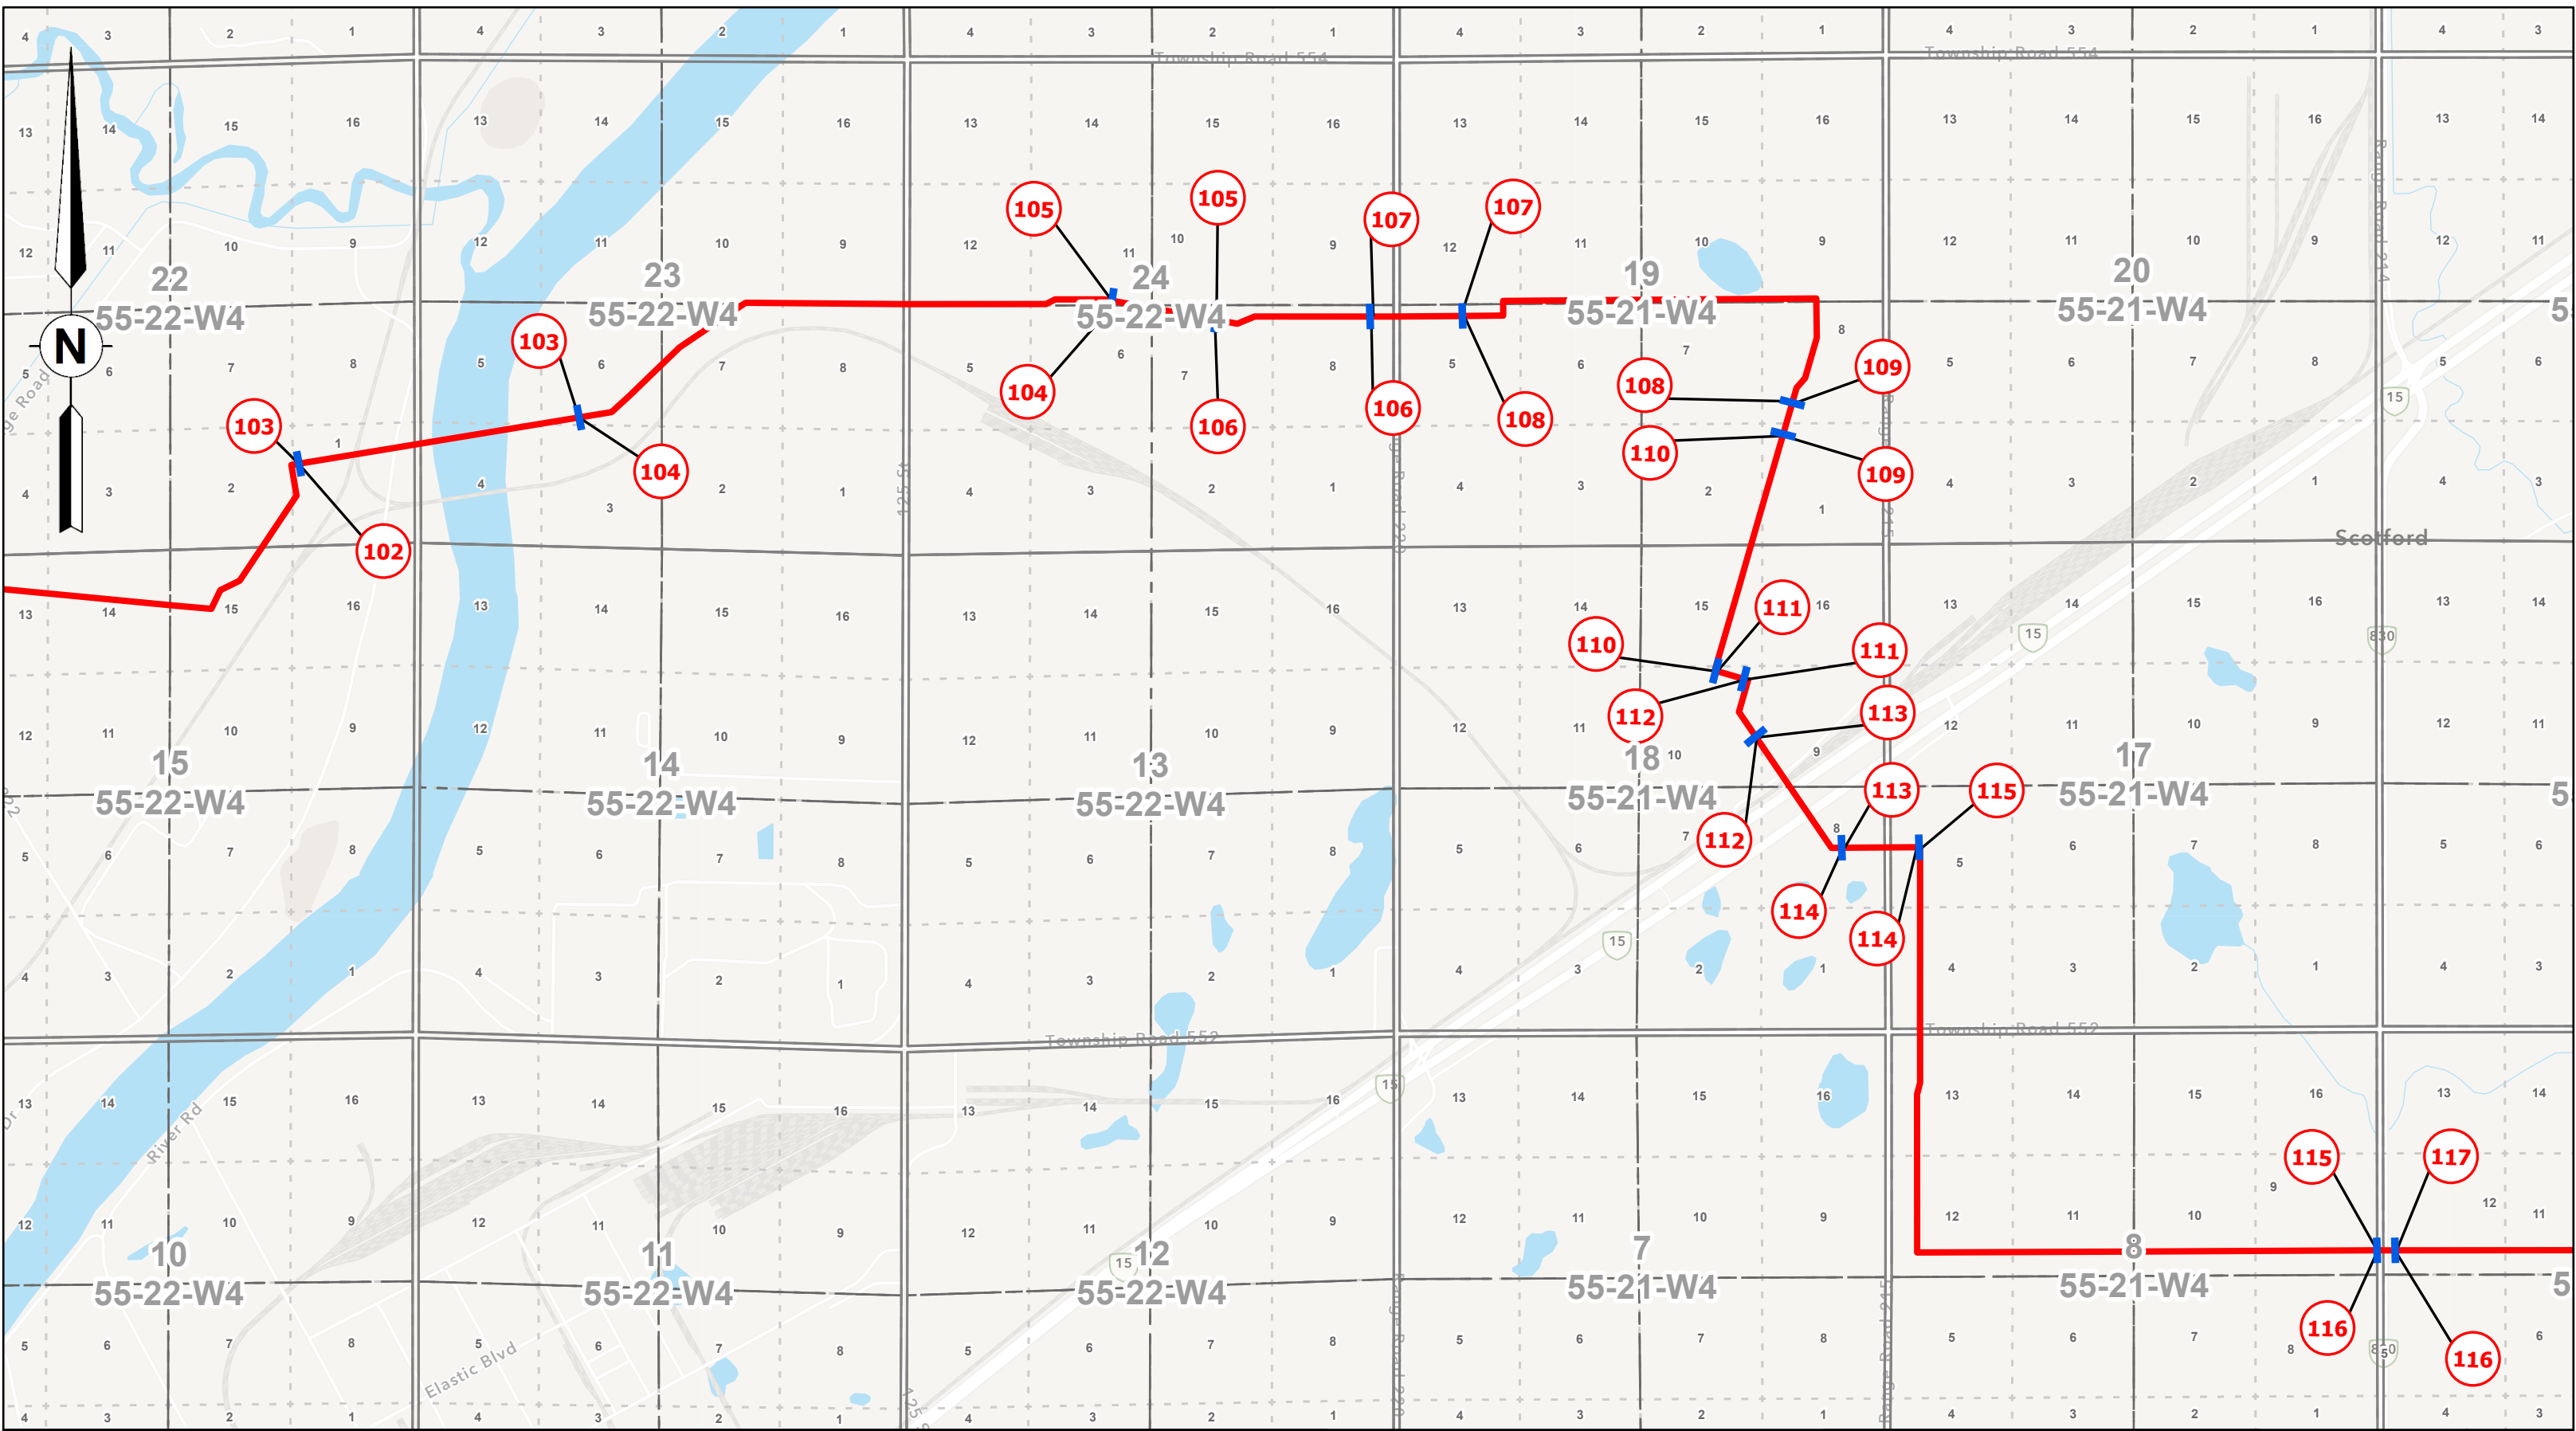



McElhanney Ltd.
100, 402 - 11th Avenue SE
Calgary, Alberta T2G 0Y4
T(403)245-4711





1:2,500,000

Legend

- PIPELINE PERMITTED, OPERATING OR DE-LICENSED
- ABANDONED OR REMOVED PIPELINE
- PIPELINE SPLIT LOCATION
- LINE NUMBER FOR PERMITTED, OPERATING OR DE-LICENCED PIPELINE
- LINE NUMBER FOR ABANDONED OR REMOVED PIPELINE
- INSTALLATION NUMBER (COMPRESSOR STATION)

**ATCO Yellowhead Pipeline
AUC Facility Application**

**Installation Location and Site Plans within
NE-27-54-14-W5M To SE-15-55-21-W4M**

SCALE: 1:20,000

DC Num: N/A

0 250 500 1,000 Metres

JOB: 301100635

PLAN ID: AUC Facilities Application

License No.:

REV
0

GIS

TH

CHK


RD

DATE

10/14/2025

Page 26 of 27

0	10/14/2025	Plan Issued
Rev	Date	Description

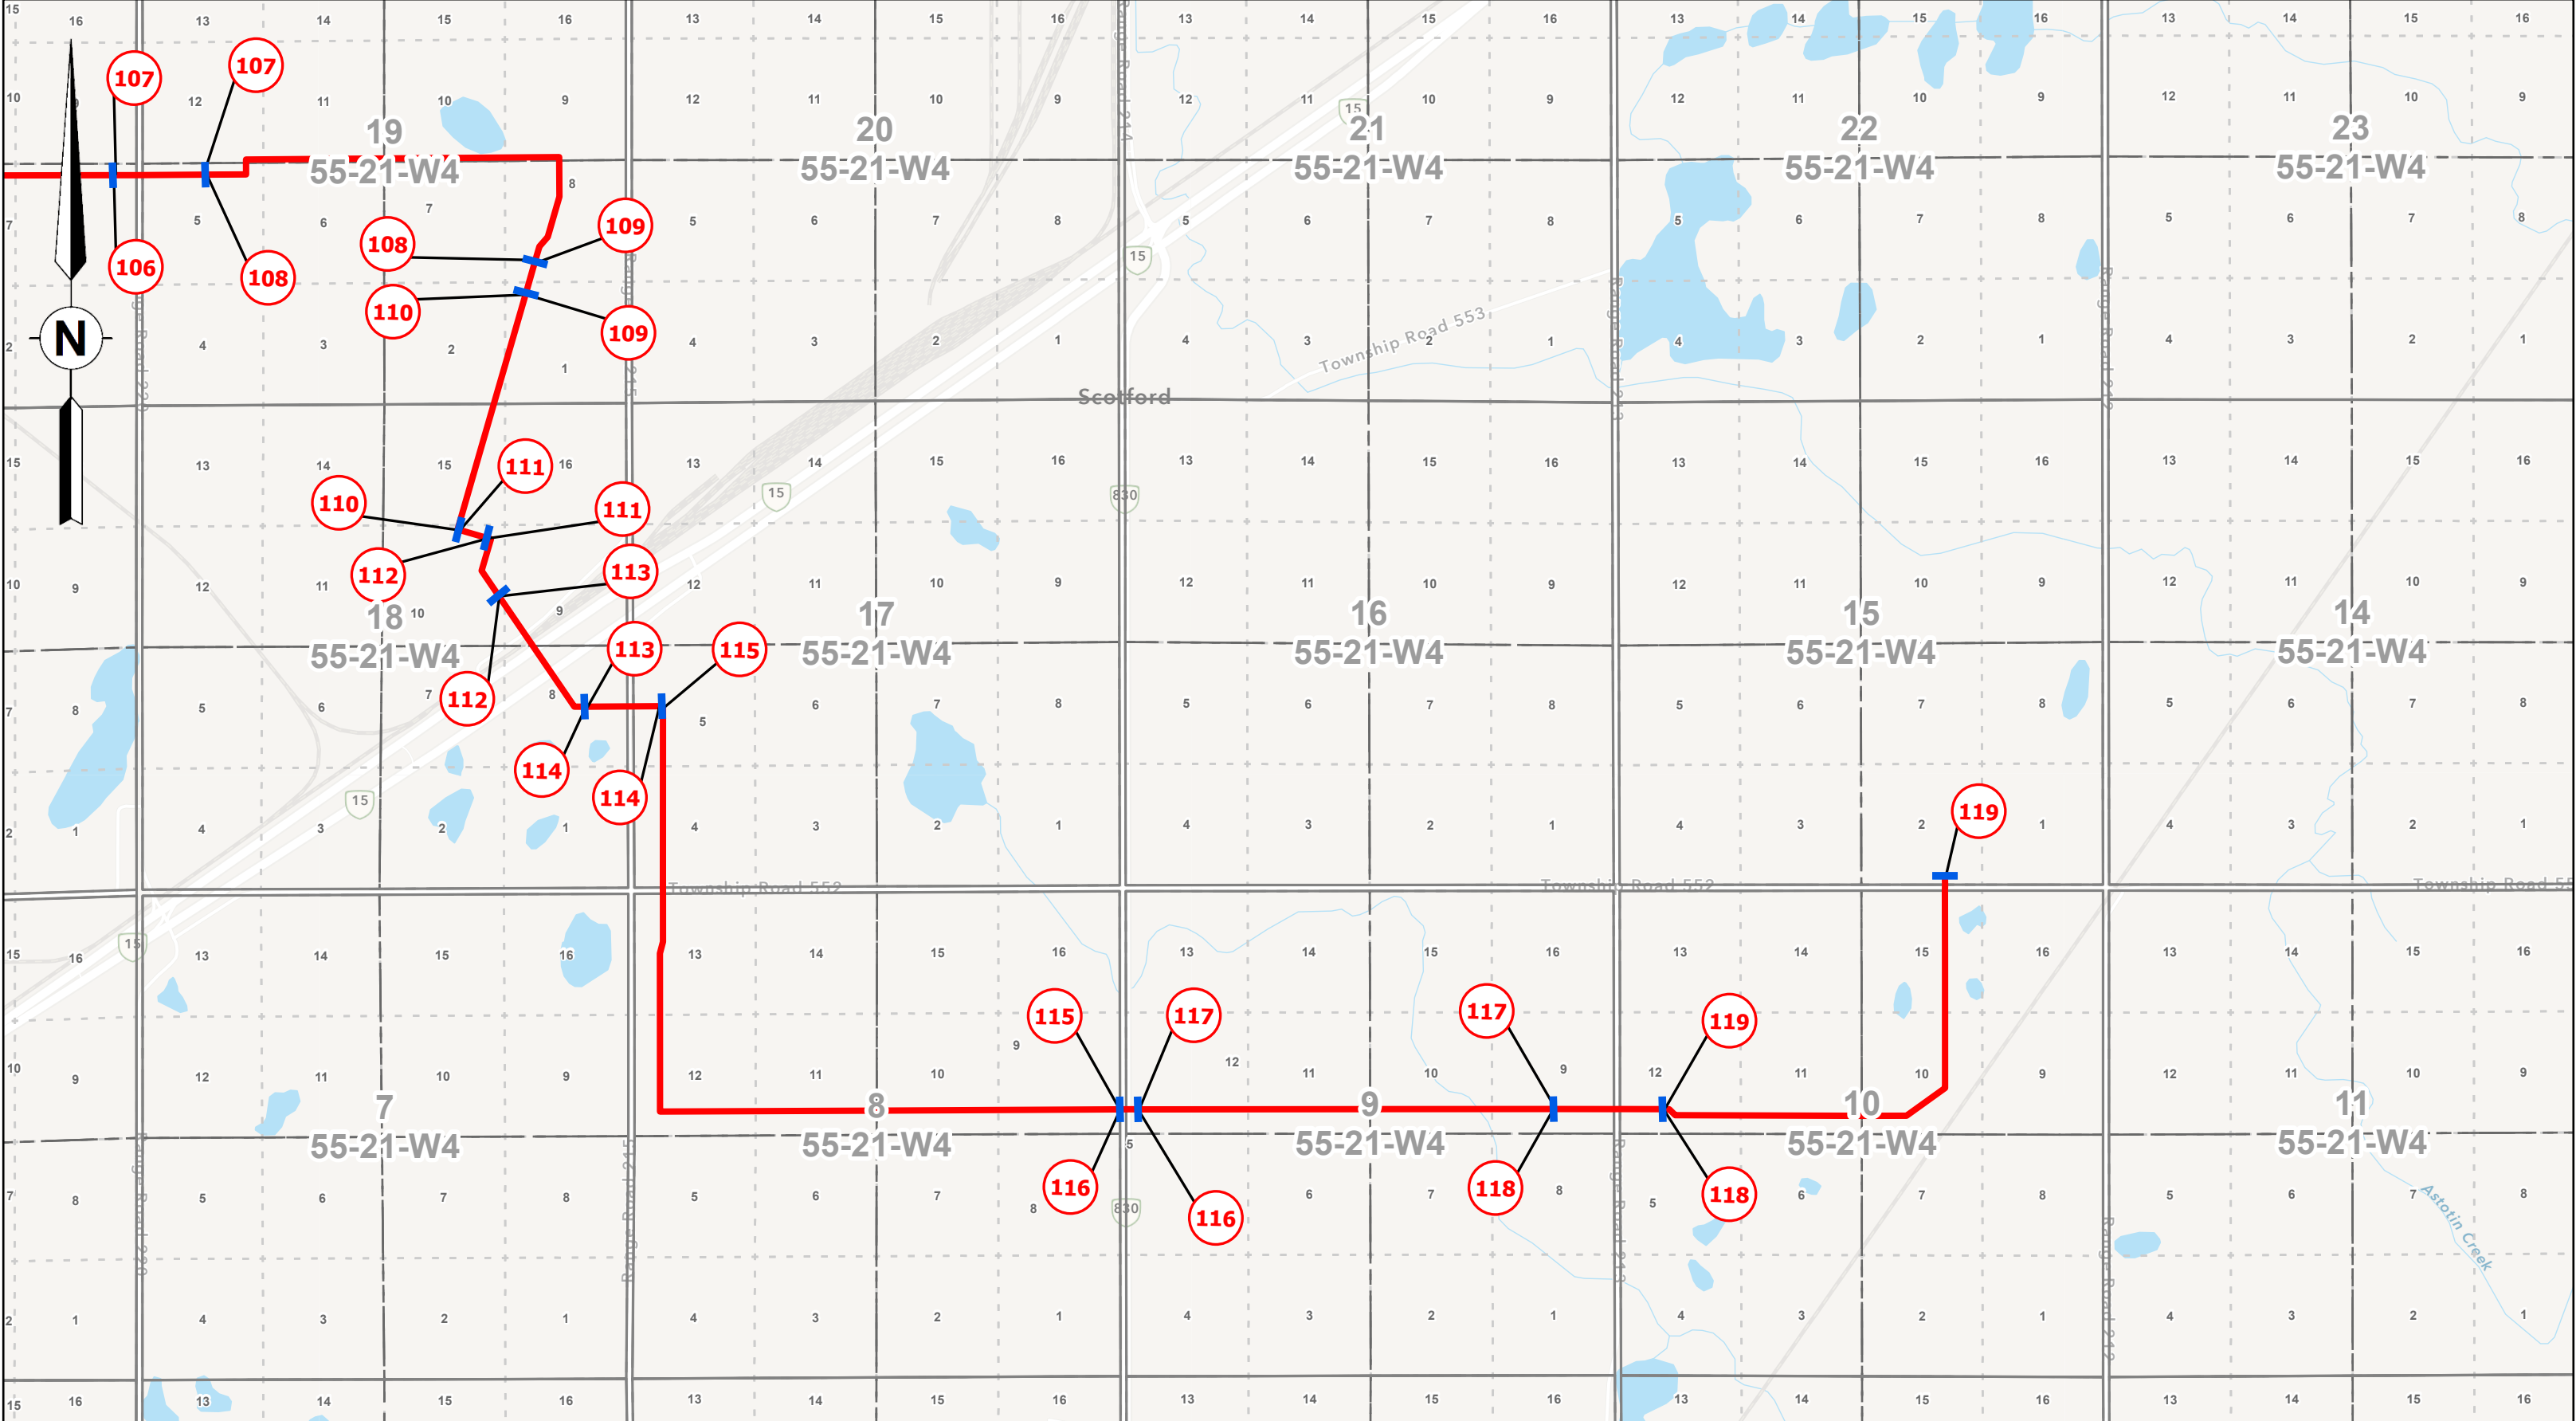




McElhanney Ltd.
100, 402 - 11th Avenue SE
Calgary, Alberta T2G 0Y4
T(403)245-4711



0	10/14/2025	Plan Issued
Rev	Date	Description

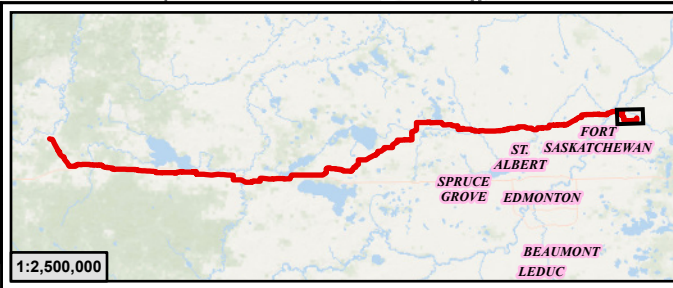

Legend

 
- PIPELINE PERMITTED, OPERATING OR DE-LICENSED
- ABANDONED OR REMOVED PIPELINE
- PIPELINE SPLIT LOCATION
- LINE NUMBER FOR PERMITTED, OPERATING OR DE-LICENCED PIPELINE
- LINE NUMBER FOR ABANDONED OR REMOVED PIPELINE
- INSTALLATION NUMBER (COMPRESSOR STATION)

**ATCO Yellowhead Pipeline
AUC Facility Application**

**Installation Location and Site Plans within
NE-27-54-14-W5M To SE-15-55-21-W4M**

SCALE: 1:20,000

DC Num: N/A



JOB: 301100635

PLAN ID: AUC Facilities Application

License No.:

REV
0

GIS

TH

CHK

RD

DATE

10/14/2025

Page 27 of 27